


SLUDGE PUMP (P-R300C)



SLUDGE PUMP (P-R400C)

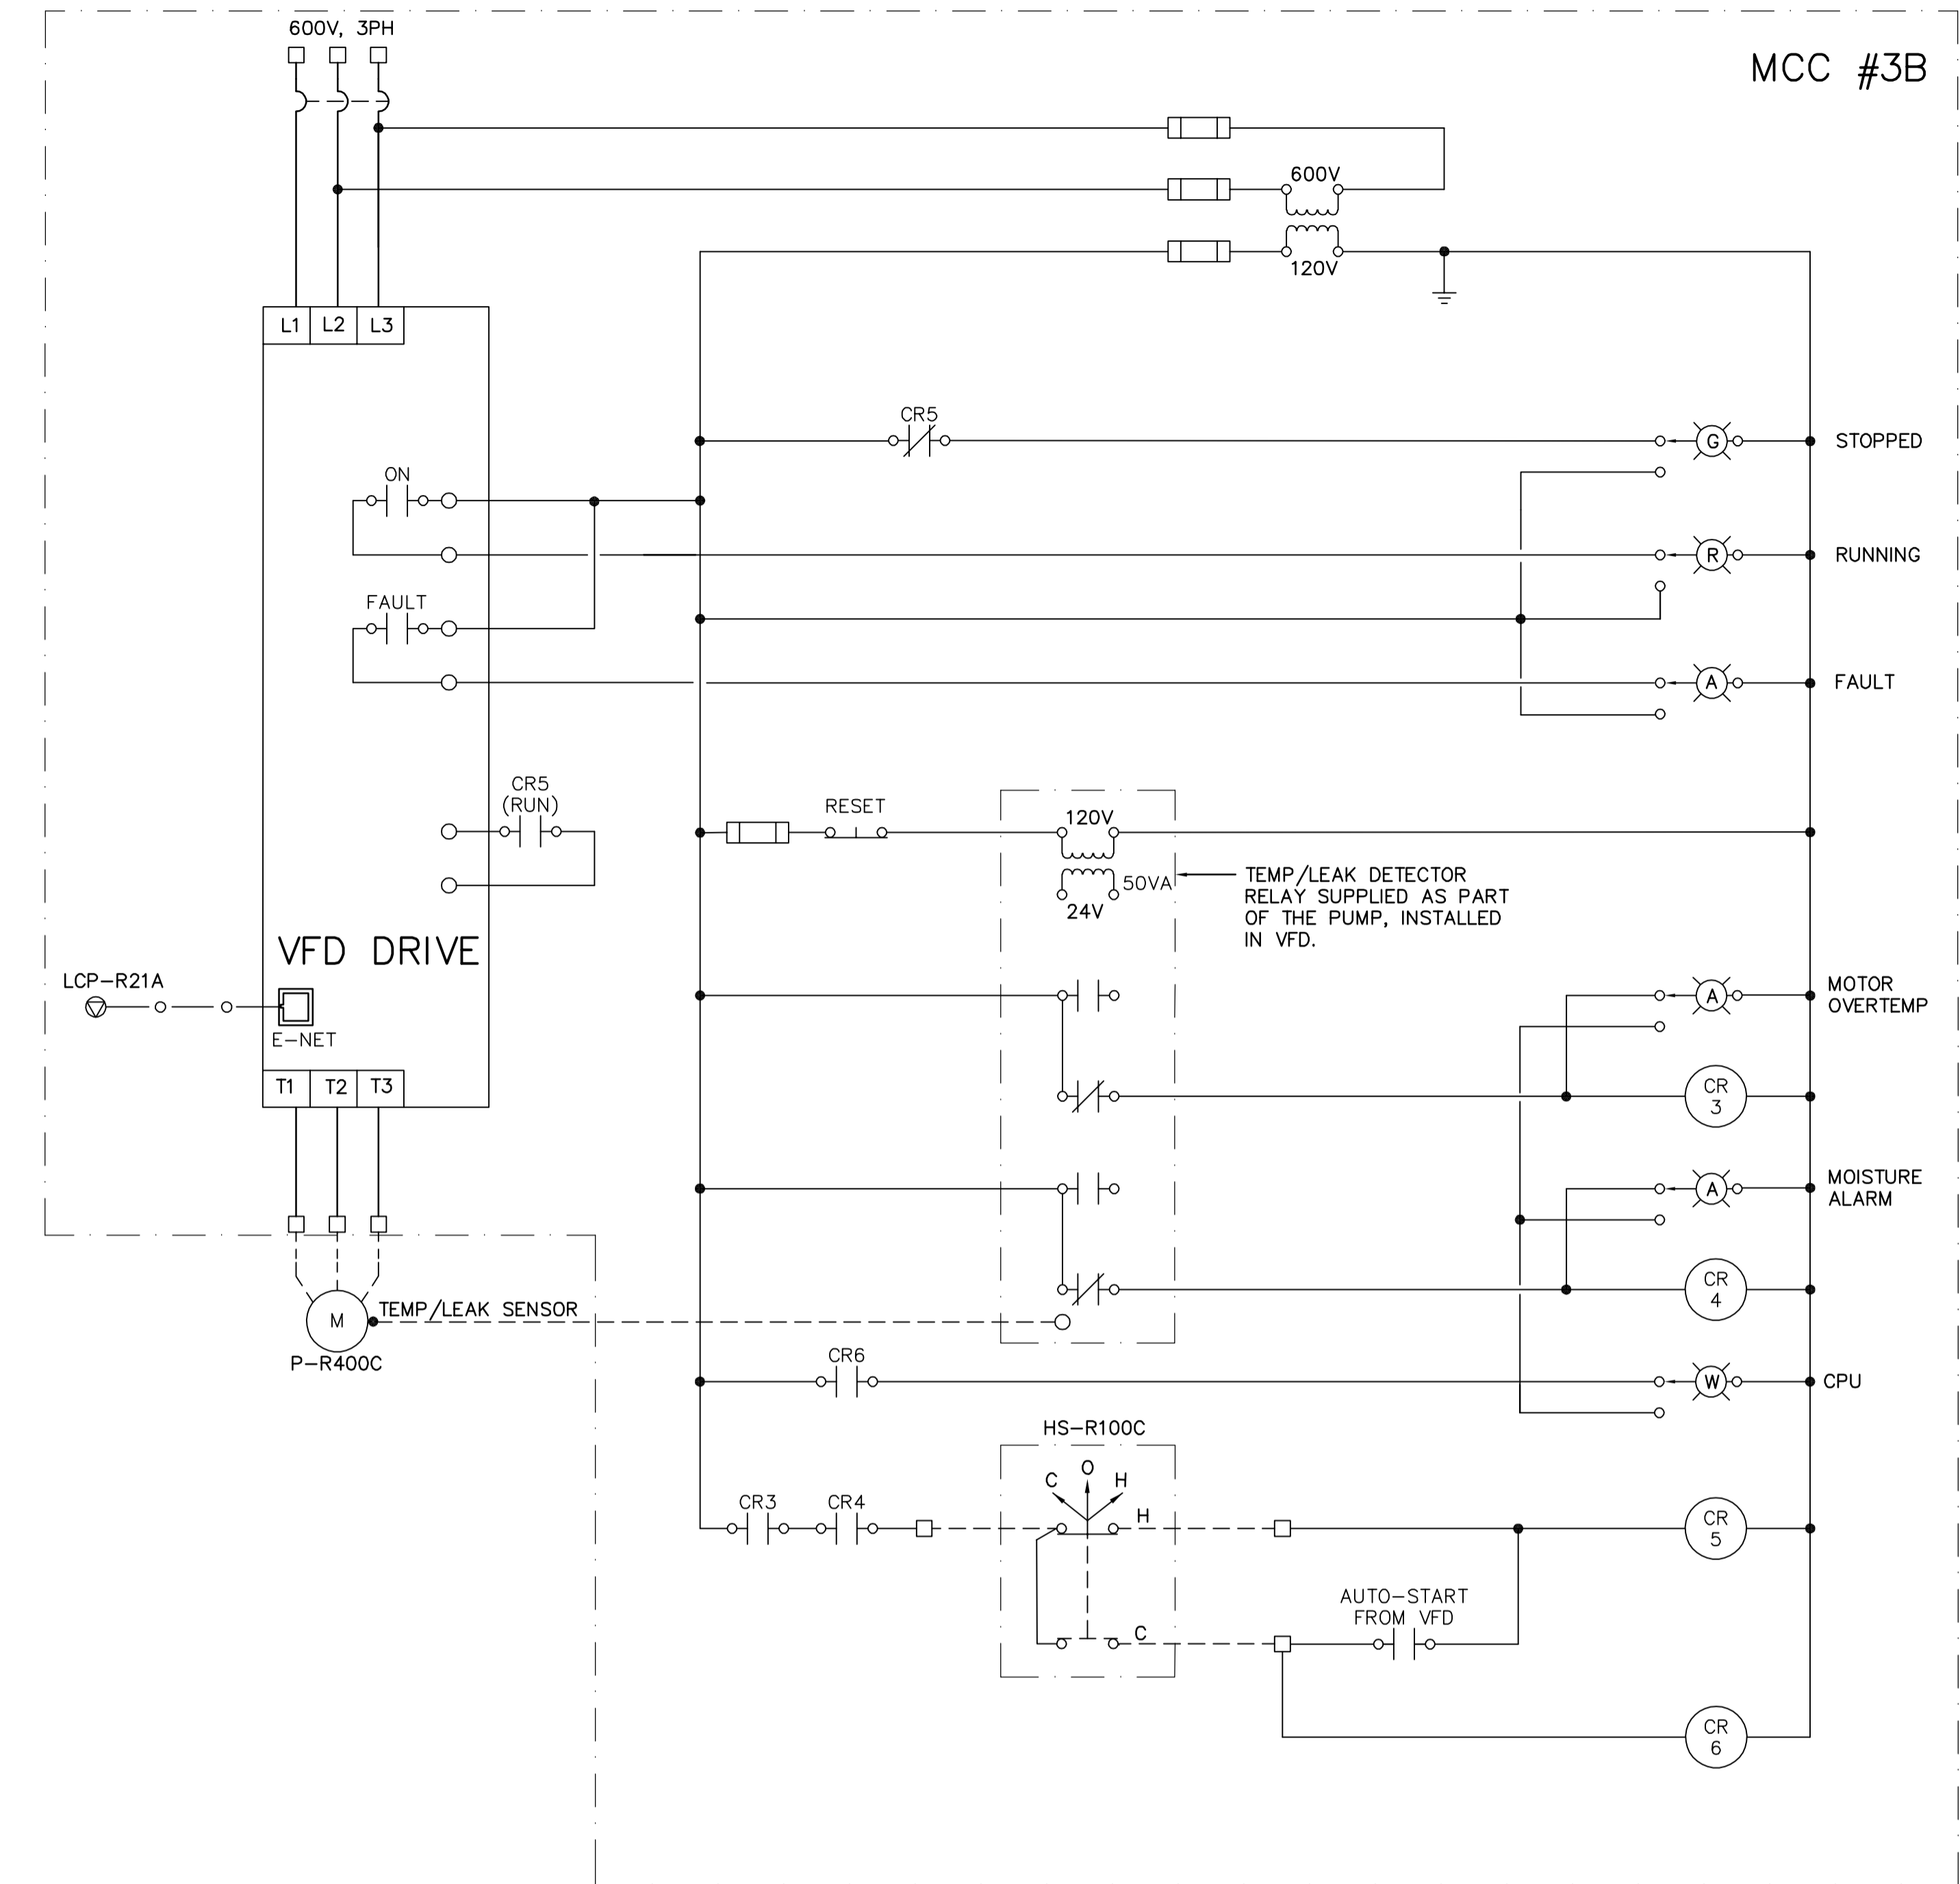

B.M. ELEV.	
DESIGNED BY	JT
DRAWN BY	KJ
SCALE:	NTS
ISSUED FOR TENDER	06/03/29
NO. REVISIONS	DATE BY
	DATE 2005/11/08

 Frederickson Cooper ARCHITECTS		 A Yeo International Ltd. Company	
DESIGNED BY	JT	CHECKED BY	ND
DRAWN BY	KJ	APPROVED BY	AHL
SCALE:	NTS	RELEASED FOR CONSTRUCTION BY:	R. SOROKOWSKI
DATE	2005/11/08	DATE	2006/03/29

ENGINEER'S SEAL
 ORIGINAL SIGNED BY
 L.D. LLÉWELLYN
 2006/03/29
 CONSULTANT DRAWING NO.
 WB-E0557

THE CITY OF WINNIPEG WATER AND WASTE DEPARTMENT ENGINEERING DIVISION	
WATER TREATMENT PLANT MAIN BUILDING MECHANICAL AND ELECTRICAL	CITY FILE NUMBER SHEET OF
ELECTRICAL CONTROL DIAGRAM	CITY DRAWING NUMBER 1-0601B-H-E0557-001-000