
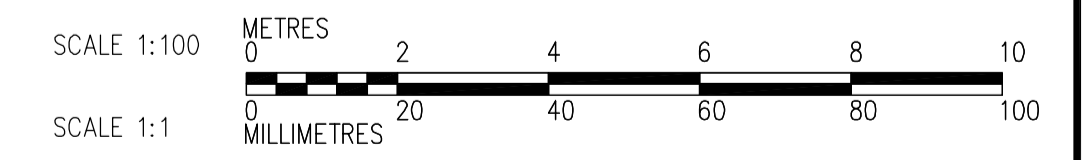


- NOTES:**
1. ALL 120V AND 208V LOADS ARE FED FROM LP-C11.
  2. EMERGENCY LIGHTING EM-X-1, -2 ETC ARE FED FROM BATTERY PACK EM-X.

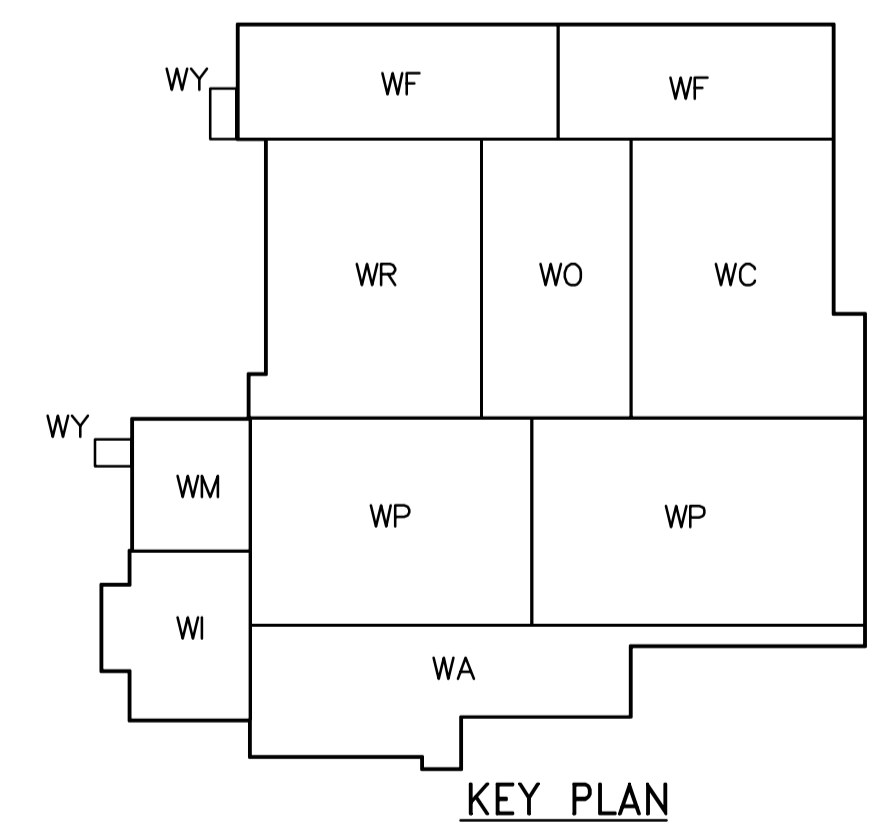

**FIRST FLOOR POWER AND LIGHTING PLAN**  
1:100

<p><b>Certificate of Authorization</b> CH2M HILL Canada Ltd. No. 1441 Expiry: April 30, 2006</p>	<p>B.M. ELEV.</p>		<p>Frederickson Cooper ARCHITECTS</p>	<p>A Terra International Ltd. Company</p>	<p>ENGINEER'S SEAL</p>	<p><b>THE CITY OF WINNIPEG</b> WATER AND WASTE DEPARTMENT ENGINEERING DIVISION</p>
	<p>DESIGNED BY KJ CHECKED BY ND</p>				<p>ORIGINAL SIGNED BY L.D. LLEWELLYN</p>	
	<p>DRAWN BY JT APPROVED BY AHL</p>				<p>2006/03/29</p>	
	<p>SCALE: 1:100 RELEASED FOR CONSTRUCTION BY: R. SOROKOWSKI</p>				<p>CONSULTANT DRAWING NO. WC-E0113</p>	
<p>00 ISSUED FOR TENDER 06/03/29 LL</p>	<p>NO. REVISIONS DATE BY DATE 2005/07/08 DATE 2006/03/29</p>	<p>WATER TREATMENT PLANT CHEMICAL FEED SYSTEMS MECHANICAL AND ELECTRICAL</p>		<p>CITY FILE NUMBER</p>	<p>CITY DRAWING NUMBER 1-0601C-A-E0113-001-000</p>	