
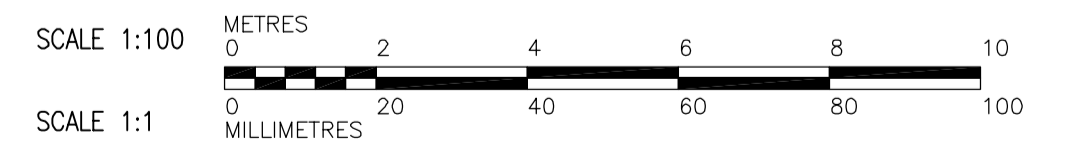


- NOTES:**
1. CONSTANT VOLUME VENTURI VALVE BY E.H. PRICE, MODEL MA-CV SIZE 200. ADJUST FOR 118 L/S
 2. PROVIDE FIRE DAMPER AT ALL DUCT PENETRATION THRU FLOOR.
 3. PROVIDE DRIP LEG ON GAS PIPES AS REQUIRED BY APPLICABLE GAS CODE.

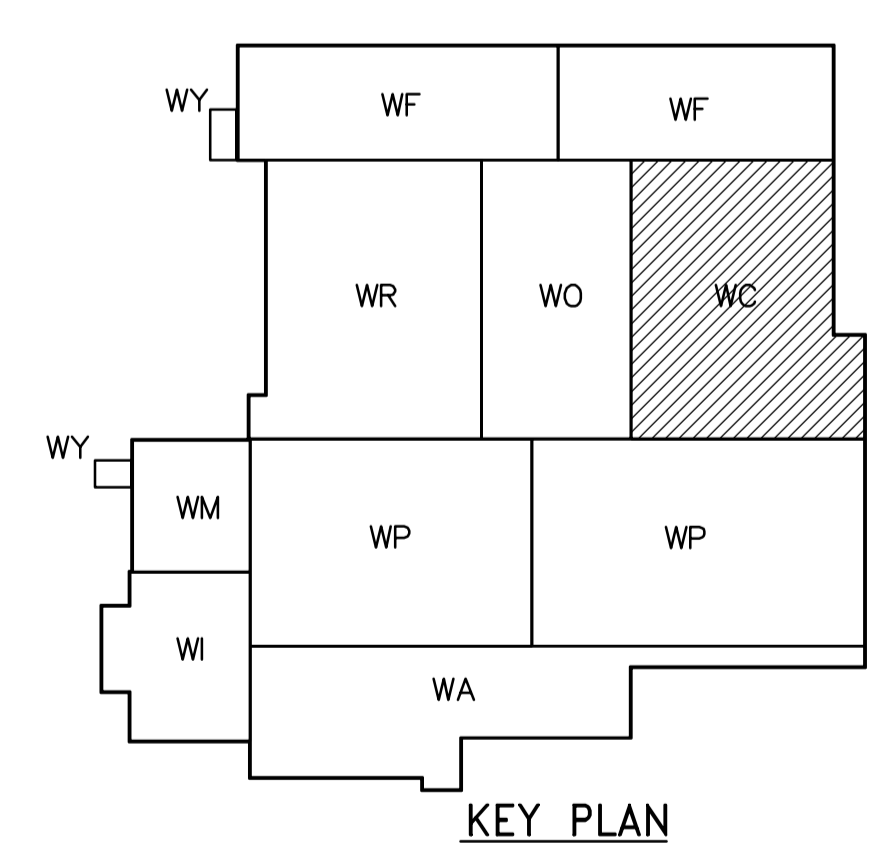

THIRD FLOOR PLAN
1:100

APEGN
Certificate of Authorization
CH2M HILL Canada Ltd.
No. 1441 Expiry: April 30, 2006

DESIGNED BY TT		CHECKED BY DL	
DRAWN BY AM		APPROVED BY AHL	
SCALE: 1:100		RELEASED FOR CONSTRUCTION BY: R. SOROKOWSKI	
DATE 2005/07/04		DATE 2006/03/29	

ENGINEER'S SEAL
ORIGINAL SIGNED BY
D.K. CUDDINGTON
2006/03/29
CONSULTANT DRAWING NO.
WC-H0131

THE CITY OF WINNIPEG
WATER AND WASTE DEPARTMENT
ENGINEERING DIVISION

WATER TREATMENT PLANT
CHEMICAL FEED SYSTEMS
MECHANICAL AND ELECTRICAL

HVAC
CHEMICAL AREA
THIRD FLOOR PLAN

CITY FILE NUMBER
SHEET OF
CITY DRAWING NUMBER
1-0601C-A-H0131-001-000