



1
-
1:50
DETAIL

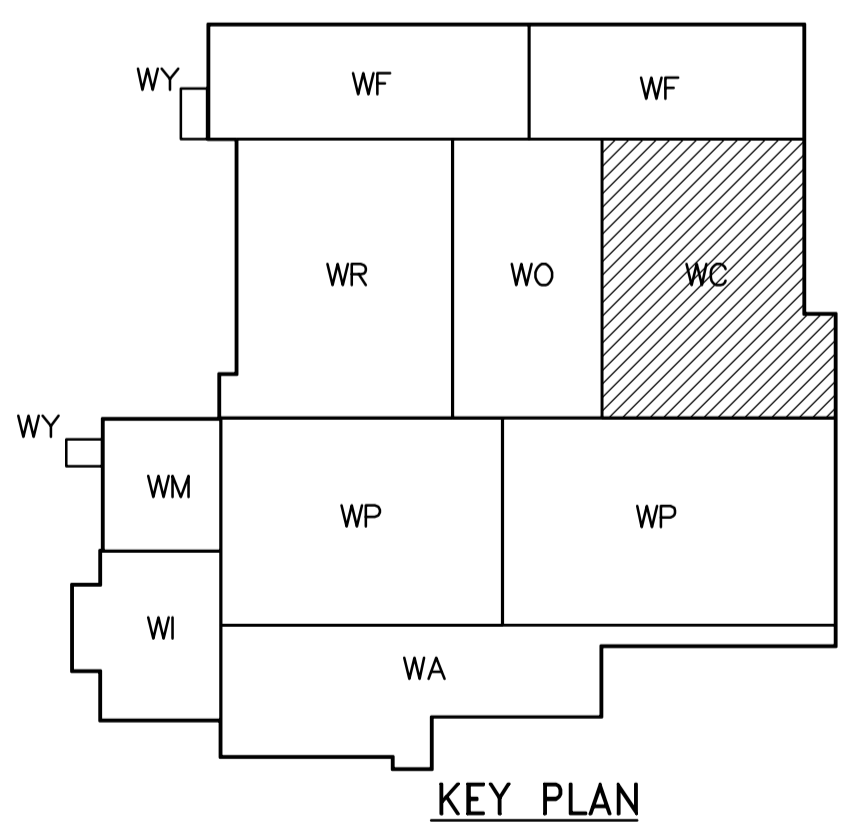

FIRST FLOOR PLAN
1:100

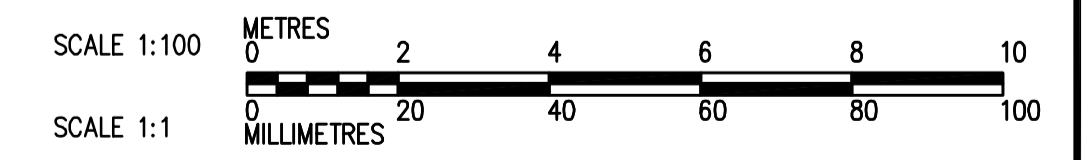

<p>APEGN Certificate of Authorization CH2M HILL Canada Ltd. No. 1441 Expiry: April 30, 2006</p>	<p>Frederickson Cooper ARCHITECTS</p>		<p>EarthTech A Tyco International Ltd. Company</p>		ENGINEER'S SEAL ORIGINAL SIGNED BY D.K. CUDDINGTON 2006/02/06	<p>THE CITY OF WINNIPEG WATER AND WASTE DEPARTMENT ENGINEERING DIVISION</p> <p>WATER TREATMENT PLANT CHEMICAL FEED SYSTEMS FOUNDATIONS AND CONCRETE STRUCTURES</p> <p>PLUMBING PIPE EMBEDS CHEMICAL AREA FIRST FLOOR PLAN</p>	CITY FILE NUMBER SHEET OF
	DESIGNED BY JZ/SW DRAWN BY JmCP SCALE: 1:100		CHECKED BY DL APPROVED BY DJT RELEASED FOR CONSTRUCTION BY: R. SOROKOWSKI		CONSULTANT DRAWING NO. WC-H9112		CITY DRAWING NUMBER 1-0601C-A-H9112-001-00D
	B.M. ELEV.		INO. REVISIONS		DATE BY DATE		DATE
	00 ISSUED FOR TENDER 2006/02/03 SW		2005/08/02		2006/02/08		DATE