



1  
-  
1:50  
DETAIL

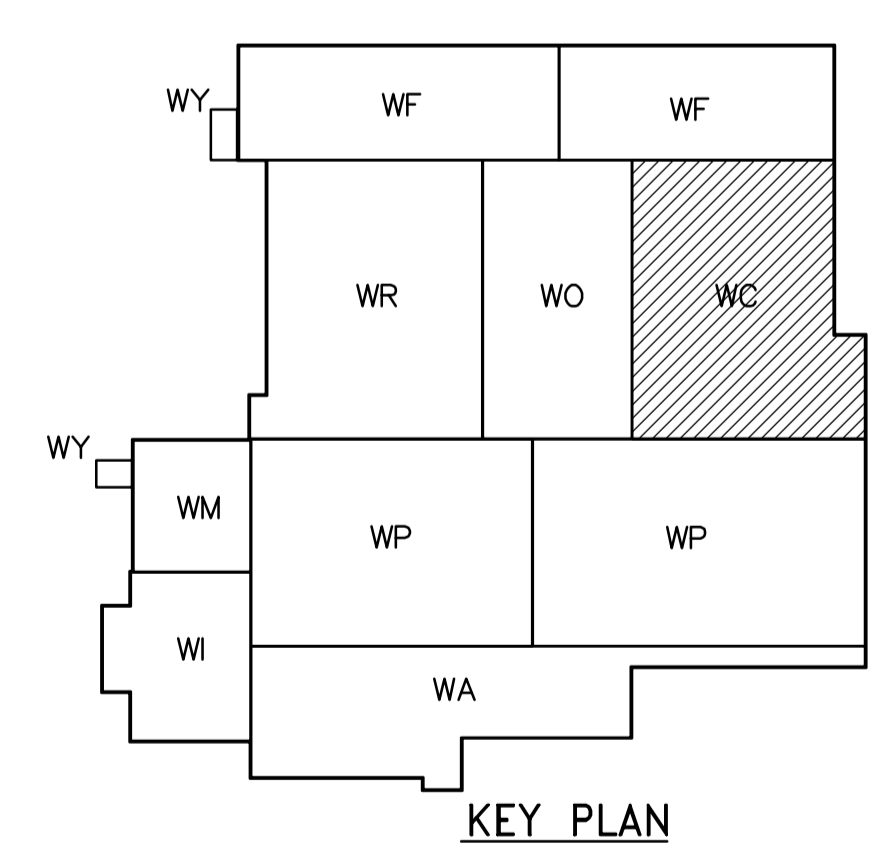

THIRD FLOOR PLAN  
1:100

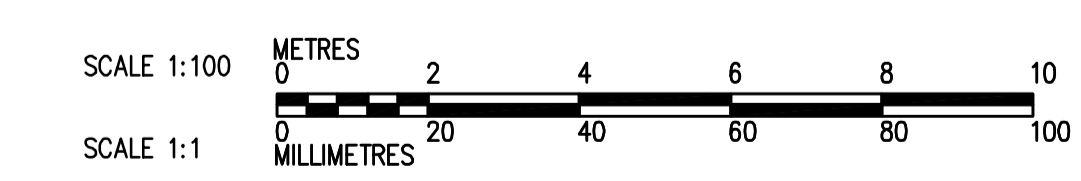

NOT IN CONTRACT FOR INFORMATION ONLY

**APEGN**  
Certificate of Authorization  
CH2M HILL Canada Ltd.  
No. 1441 Expiry: April 30, 2006

B.M. ELEV.			
00 ISSUED FOR TENDER	2006/02/03	SW	
NO. REVISIONS	DATE	BY	DATE
			2005/08/02

<b>CH2MHILL</b> Frederickson Cooper ARCHITECTS	<b>EarthTech</b> A Tyco International Ltd. Company
DESIGNED BY: JZ/SW	CHECKED BY: DL
DRAWN BY: JMcP	APPROVED BY: DJT
SCALE: 1:100	RELEASED FOR CONSTRUCTION BY: R. SOROKOWSKI
DATE: 2005/08/02	DATE: 2006/02/08

ENGINEER'S SEAL  
ORIGINAL SIGNED BY: D.K. CUDDINGTON  
2006/02/06  
CONSULTANT DRAWING NO. WC-H9132

**THE CITY OF WINNIPEG**  
WATER AND WASTE DEPARTMENT  
ENGINEERING DIVISION

WATER TREATMENT PLANT  
CHEMICAL FEED SYSTEMS  
FOUNDATIONS AND CONCRETE STRUCTURES

PLUMBING  
PIPE EMBEDS  
CHEMICAL AREA THIRD FLOOR PLAN

CITY FILE NUMBER  
SHEET OF  
CITY DRAWING NUMBER  
**1-0601C-A-H9132-001-000**