

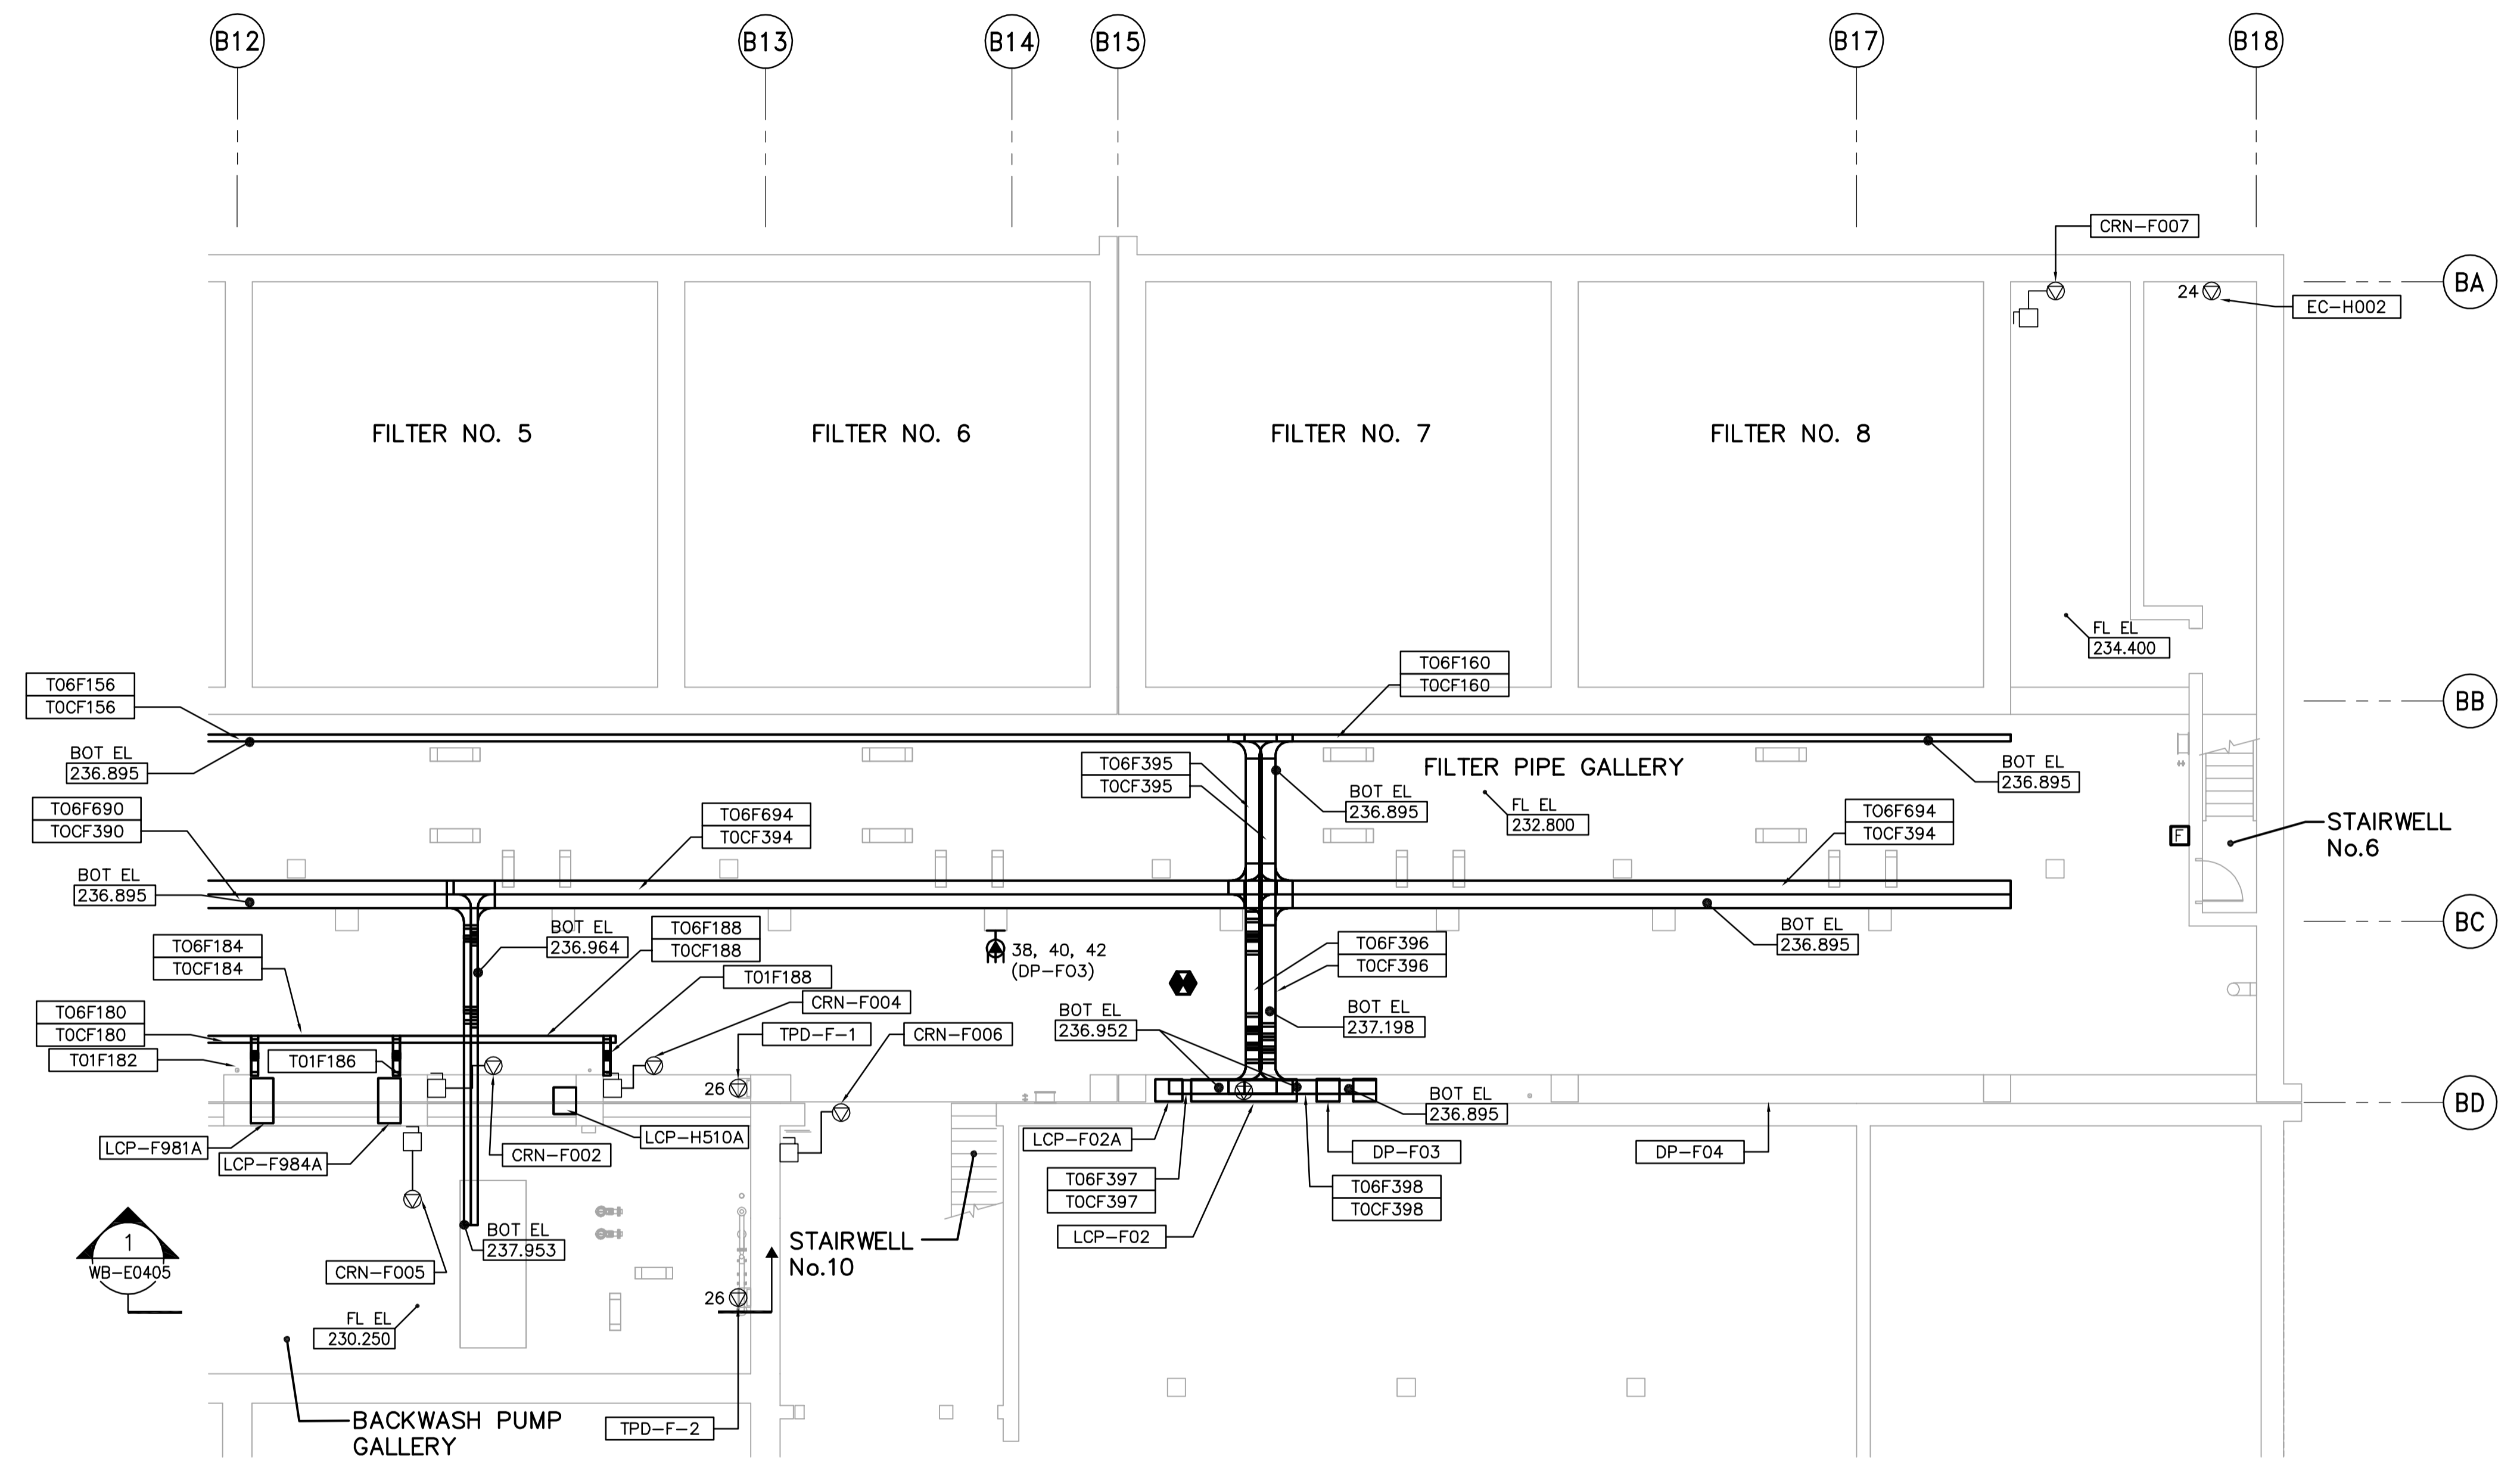


- NOTES:**
- SEE MCC #1A & #1B SINGLE LINE DIAGRAM AND DP-F03 AND DP-F04 POWER DISTRIBUTION FOR 600V POWER REQUIREMENT.
 - SEE LP-F01 FOR 120/208V POWER DISTRIBUTION.
 - PROVIDE STAIRWELL SMOKE DETECTORS AT EVERY THIRD FLOOR AND AT TOP.

FOR CABLE TRAY TAGGING SEE DETAIL 3
WB-E0455

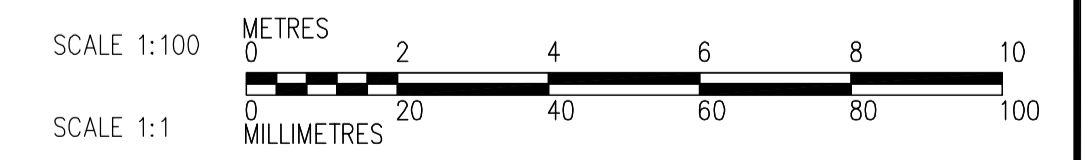

LOWER LEVEL FACILITY PLAN (AREA 2)
1:100

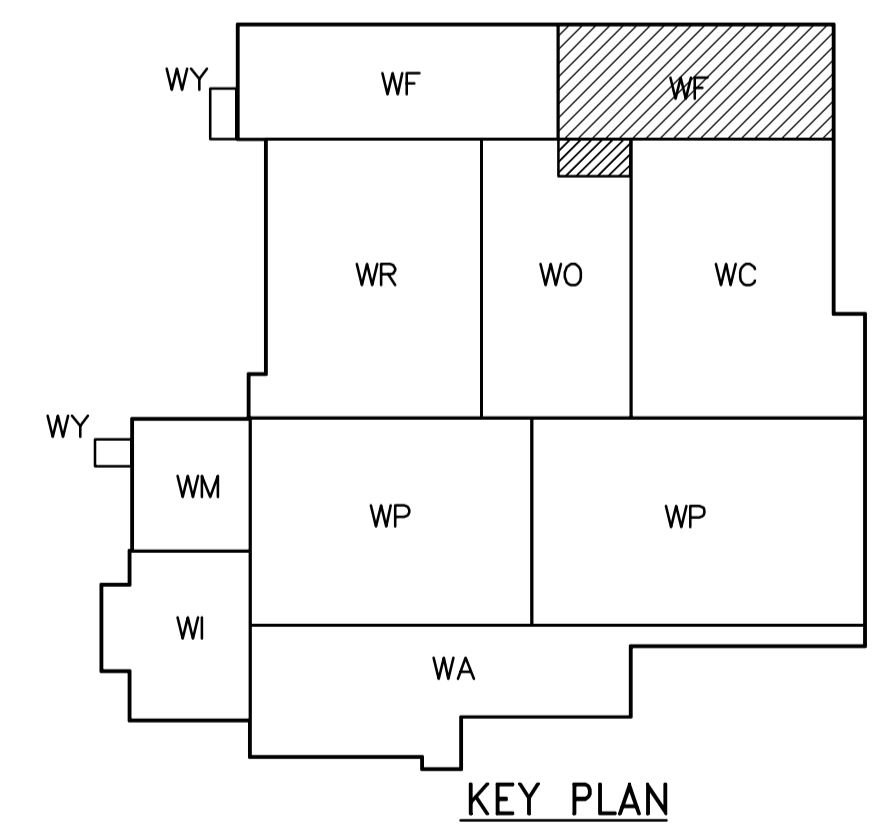

 APEGN Certificate of Authorization CH2M HILL Canada Ltd. No. 1441 Expiry: April 30, 2006	B.M. ELEV.	 Frederickson Cooper ARCHITECTS	 A Terra International Ltd. Company	ENGINEER'S SEAL ORIGINAL SIGNED BY L.D. LLEWELLYN 2006/03/29	 THE CITY OF WINNIPEG WATER AND WASTE DEPARTMENT ENGINEERING DIVISION
	DESIGNED BY: JT DRAWN BY: KJ SCALE: 1:100	CHECKED BY: ND APPROVED BY: AHL RELEASED FOR CONSTRUCTION BY: R. SOROKOWSKI	CONSULTANT DRAWING NO. WF-E0102	WATER TREATMENT PLANT FILTRATION MECHANICAL AND ELECTRICAL	CITY FILE NUMBER SHEET OF
00 ISSUED FOR TENDER 06/03/29 LL NO. REVISIONS DATE BY	DATE 2005/07/13 DATE 2006/03/29	ELECTRICAL FILTRATION AREA 2 LOWER LEVEL FACILITY PLAN			