
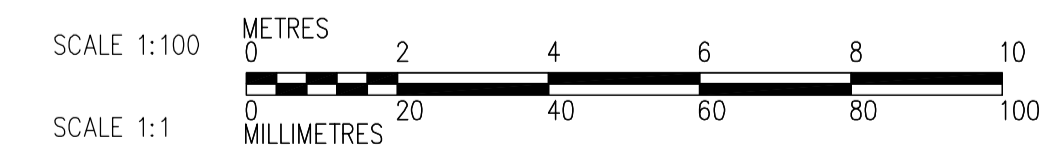


- NOTES:
1. ALL 120V AND 208V LOADS ARE FED FROM LP-H31
 2. EMERGENCY LIGHTING EM-X-1 ARE FED FROM BATTERY PACK EM-X.
 3. MOUNT TYPE A LUMINAIRE AT 3.0m ABOVE THE FLOOR
 4. SEE DWG WB-E0401 FOR TYPE A FIXTURE MOUNTING DETAILS
 5. SEE DWG WB-E402 DET 2 FOR TYPE J FIXTURE MOUNTING DETAILS

THIRD FLOOR POWER AND LIGHTING PLAN (AREA 2)
1:100

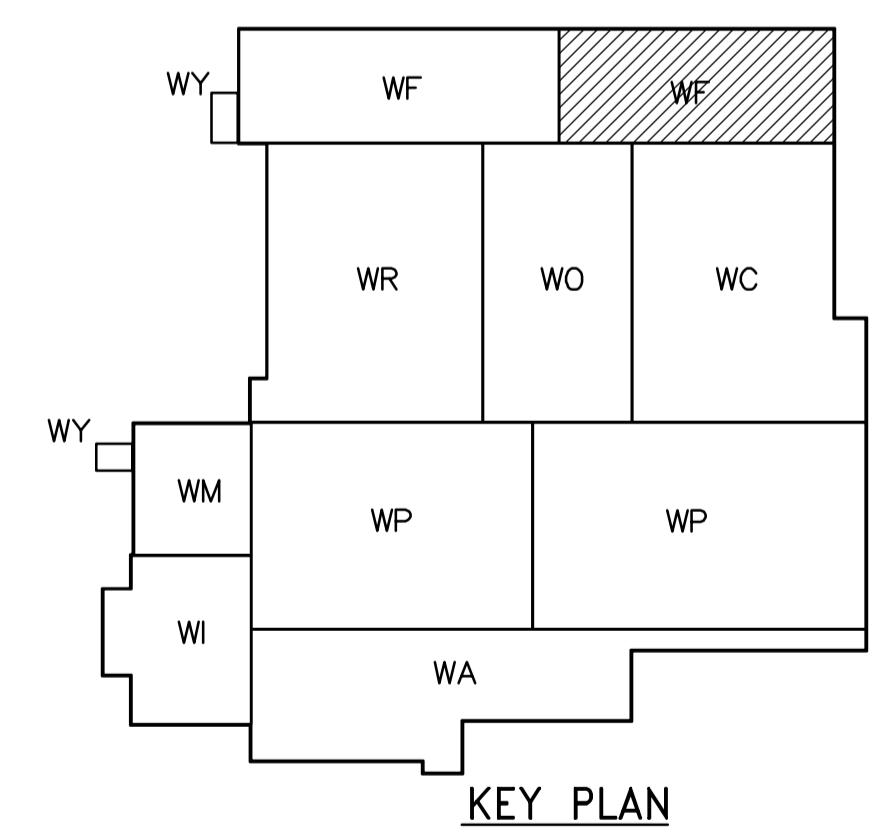

<p>APEGN Certificate of Authorization CH2M HILL Canada Ltd. No. 1441 Expiry: April 30, 2006</p>	<p>Frederickson Cooper ARCHITECTS</p>	<p>EarthTech A Geo International Ltd. Company</p>	ENGINEER'S SEAL	<p>THE CITY OF WINNIPEG WATER AND WASTE DEPARTMENT ENGINEERING DIVISION</p>
			<p>DESIGNED BY: LL</p> <p>CHECKED BY: ND</p> <p>DRAWN BY: TL</p> <p>APPROVED BY: AHL</p> <p>SCALE: 1:100</p> <p>RELEASED FOR CONSTRUCTION BY: R. SOROKOWSKI</p>	
<p>00 ISSUED FOR TENDER 06/03/29 LL</p>			<p>ELECTRICAL FILTRATION AREA 2 THIRD FLOOR POWER AND LIGHTING PLAN</p>	
<p>NO. REVISIONS DATE BY DATE 2005/07/13 DATE 2006/03/29</p>			<p>CITY DRAWING NUMBER 1-0601F-A-E0136-001-000</p>	