



FIRST FLOOR PLAN
1:100

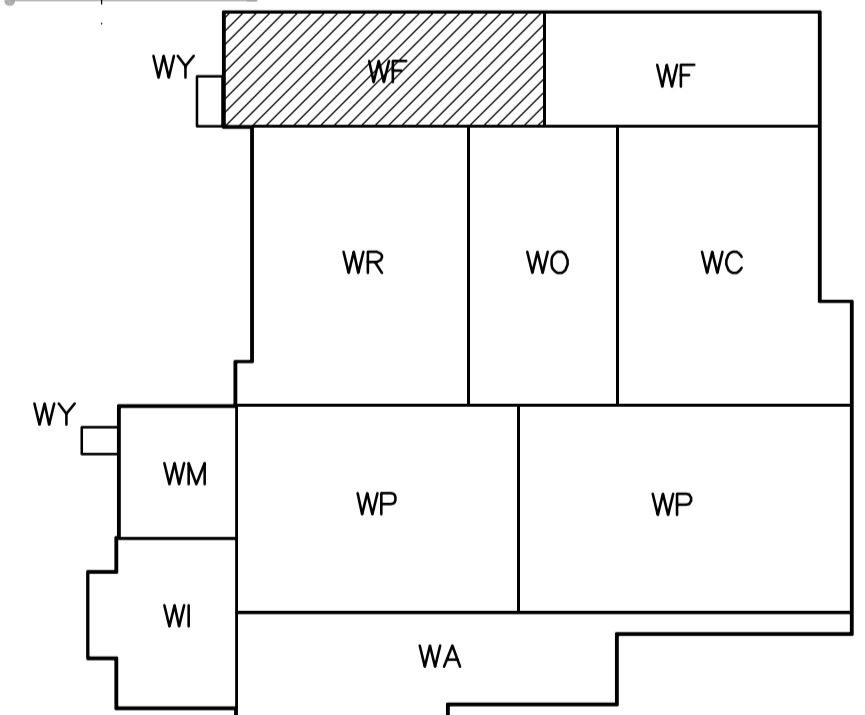

KEY PLAN

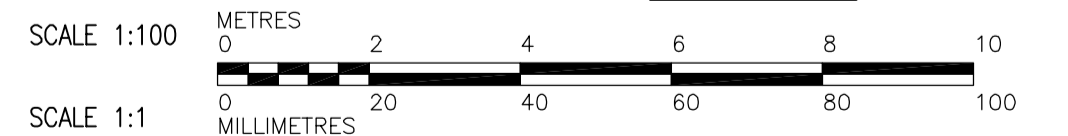

<p>APEGN Certificate of Authorization CH2M HILL Canada Ltd. No. 1441 Expiry: April 30, 2006</p>	<p>Frederickson Cooper ARCHITECTS</p>		<p>EarthTech A Tyco International Ltd. Company</p>		ENGINEER'S SEAL ORIGINAL SIGNED BY D.K. CUDDINGTON 2006/03/29	<p>THE CITY OF WINNIPEG WATER AND WASTE DEPARTMENT ENGINEERING DIVISION</p>
	DESIGNED BY TT CHECKED BY DL		DRAWN BY AM APPROVED BY AHL		CONSULTANT DRAWING NO. WF-H0111	
	SCALE: 1:100		RELEASED FOR CONSTRUCTION BY: R. SOROKOWSKI			
	00 ISSUED FOR TENDER 06/03/29 TT		2005/07/04		CITY FILE NUMBER SHEET OF CITY DRAWING NUMBER 1-0601F-A-H0111-001-000	