



SECTION A-A
1:50

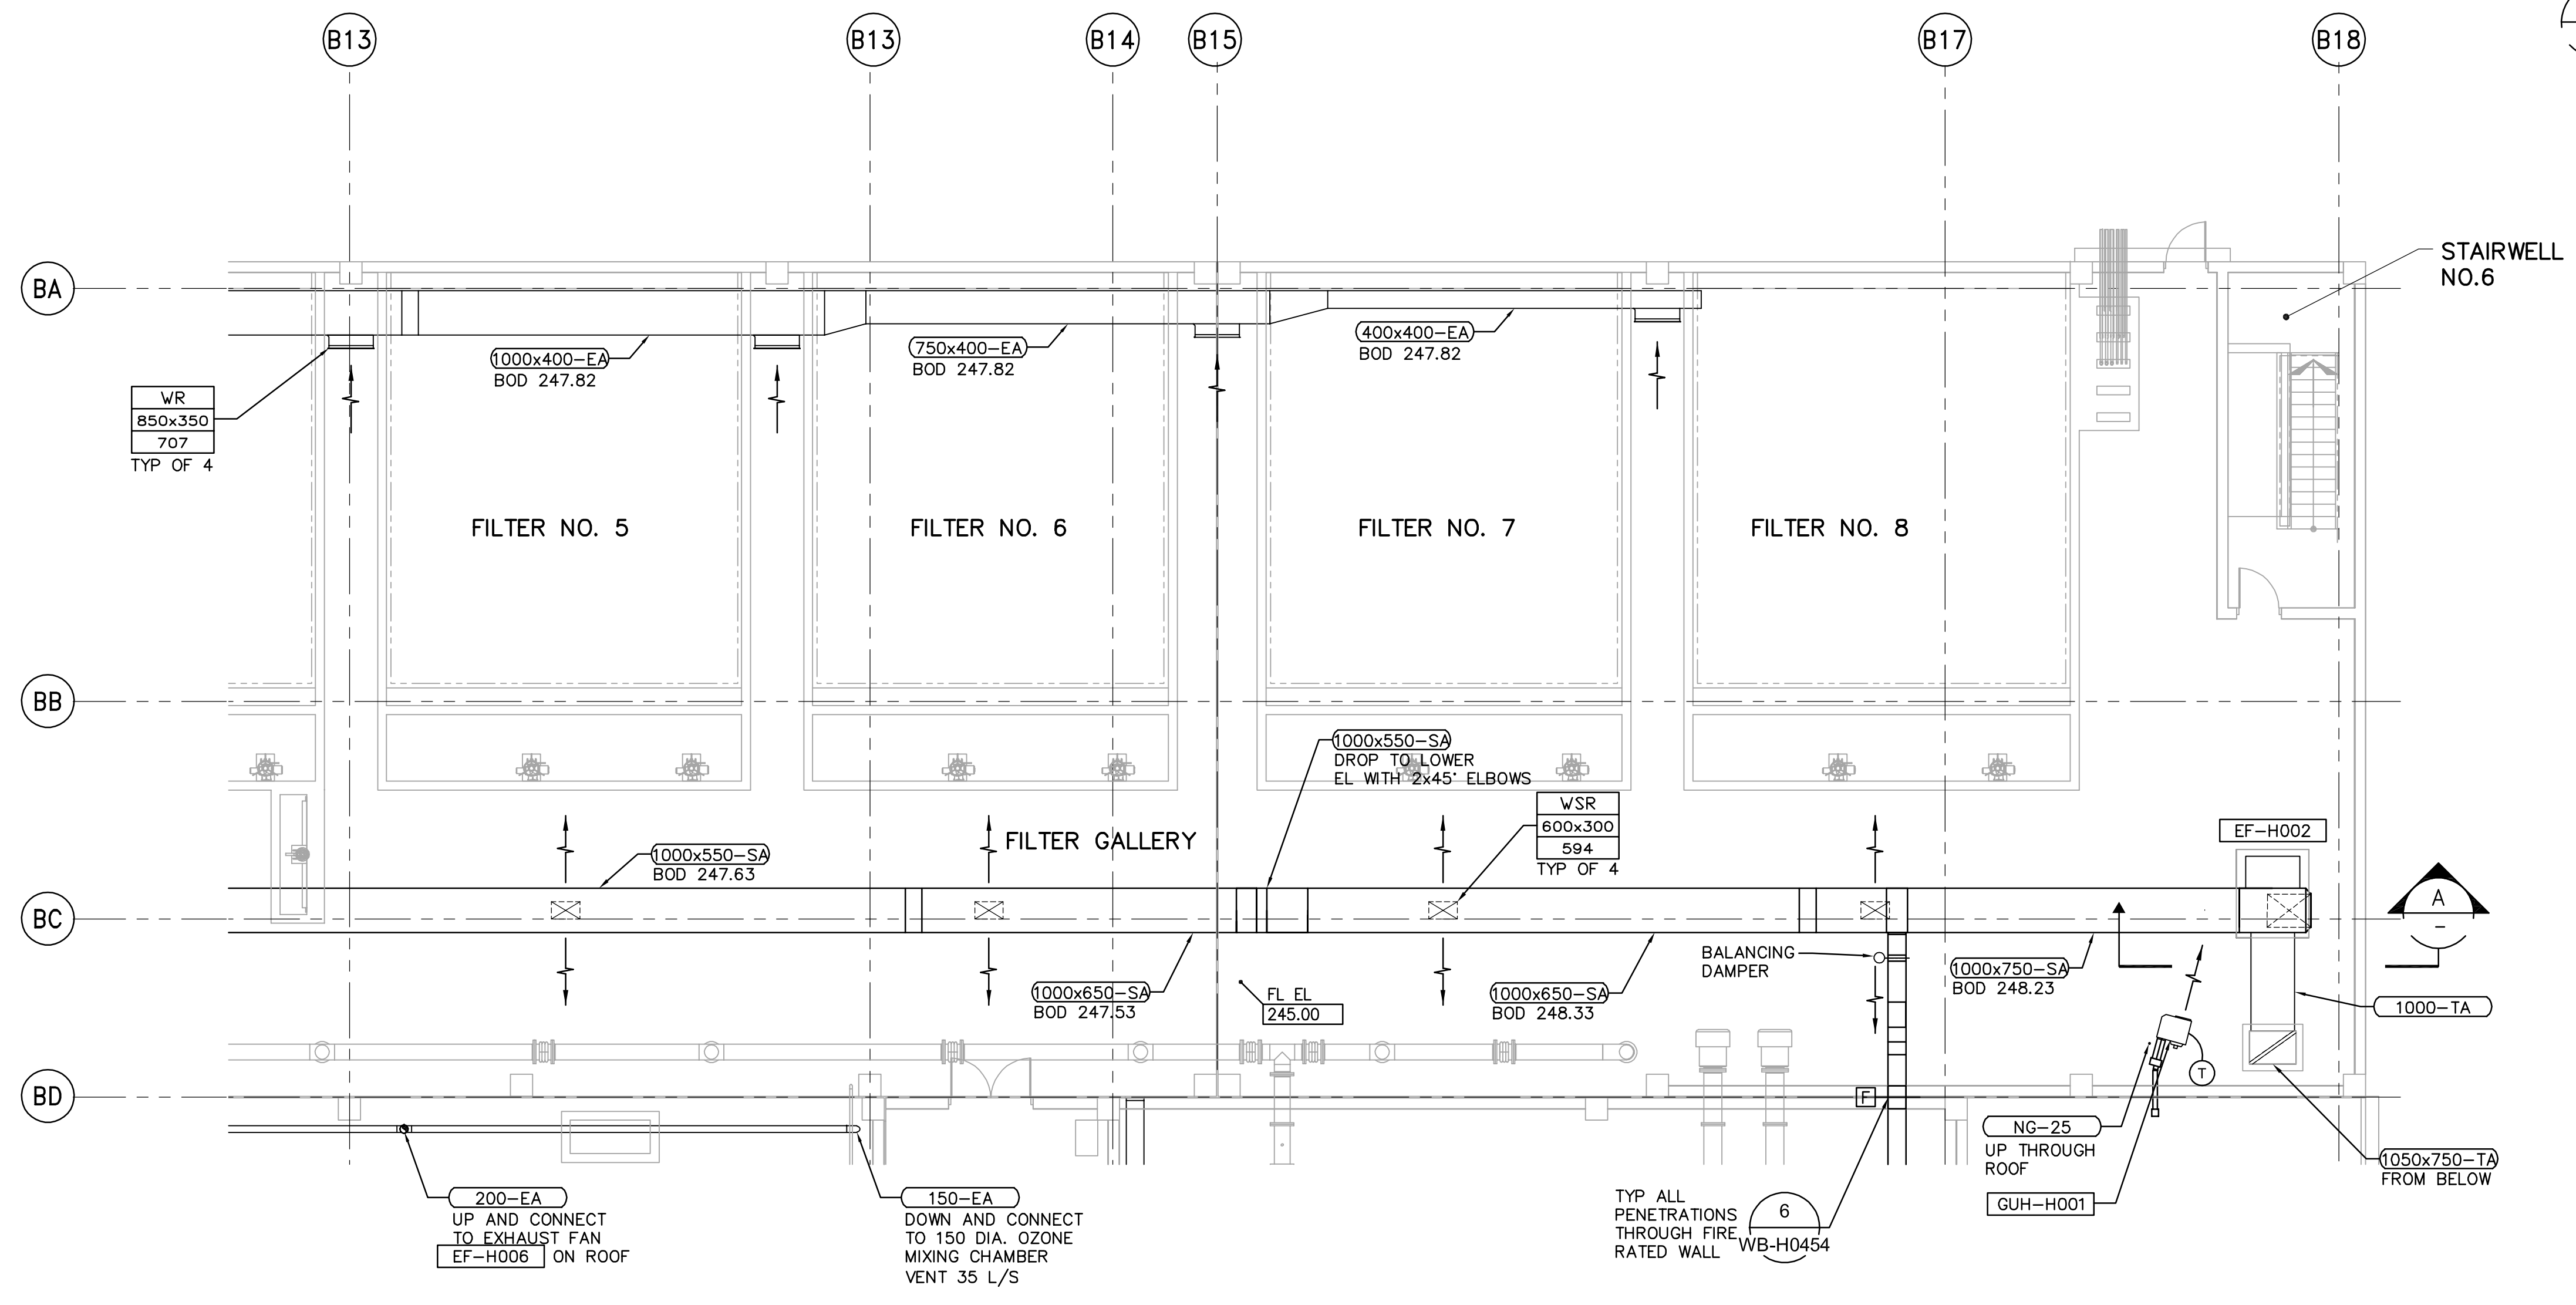


THIRD FLOOR PLAN
1:100

- NOTES:
1. PROVIDE FIRE DAMPER AT ALL DUCT PENETRATION THRU FLOOR.

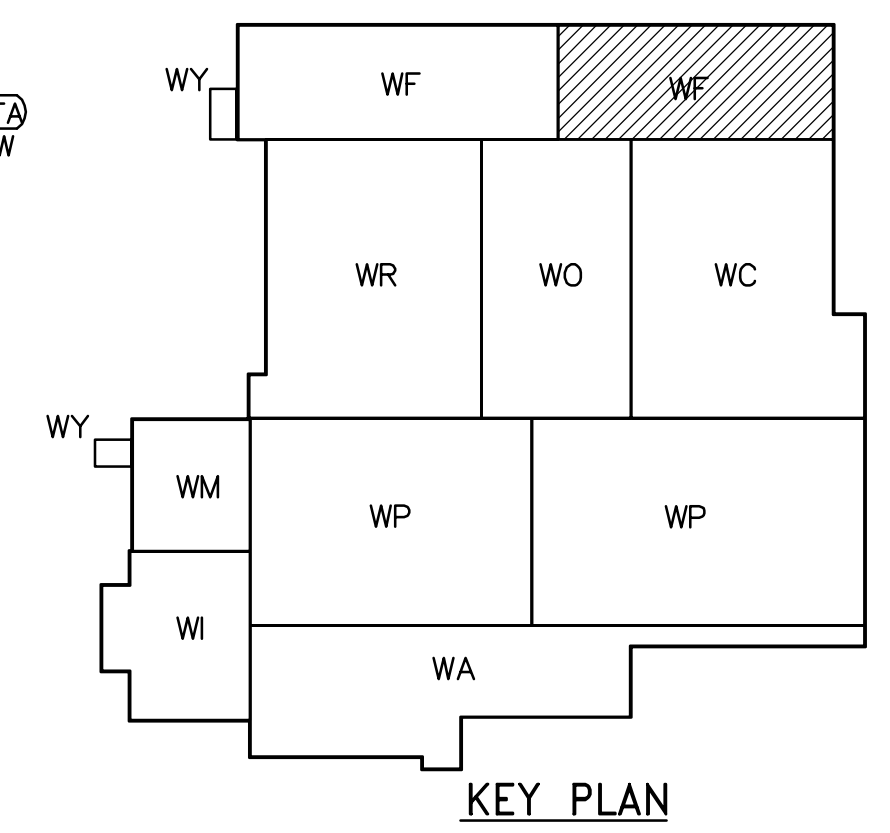

KEY PLAN

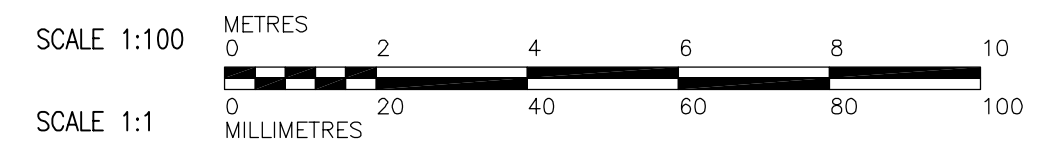

 APEGN Certificate of Authorization CH2M HILL Canada Ltd. No. 1441 Expiry: April 30, 2006	B.M. ELEV.	 Frederickson Cooper ARCHITECTS	 A Tyco International Ltd. Company	ENGINEER'S SEAL ORIGINAL SIGNED BY D.K. CUDDINGTON 2006/03/29	 THE CITY OF WINNIPEG WATER AND WASTE DEPARTMENT ENGINEERING DIVISION WATER TREATMENT PLANT FILTRATION MECHANICAL AND ELECTRICAL HVAC FILTRATION AREA 2 THIRD FLOOR PLAN	CITY FILE NUMBER
	00 ISSUED FOR TENDER 06/03/29 TT	DESIGNED BY TT CHECKED BY DL DRAWN BY AM APPROVED BY AHL	CONSULTANT DRAWING NO. WF-H0132	SHEET OF		
	NO. REVISIONS DATE BY DATE 2005/08/19 DATE 2006/03/29	SCALE: 1:100 RELEASED FOR CONSTRUCTION BY: R. SOROKOWSKI	CITY DRAWING NUMBER 1-0601F-A-H0132-001-000			