



PARTIAL SECOND FLOOR PLAN
1:100

THIRD FLOOR PLAN
1:100

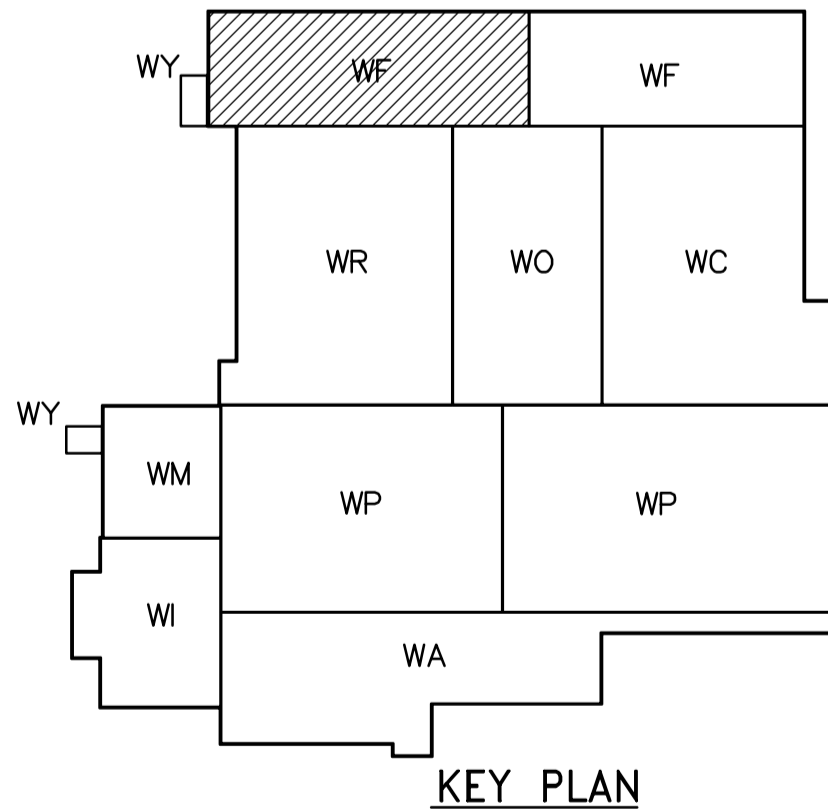

KEY PLAN

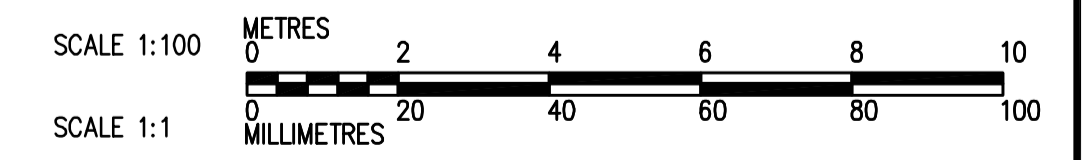

<p>APEGN Certificate of Authorization CH2M HILL Canada Ltd. No. 1441 Expiry: April 30, 2006</p>	<p>Frederickson Cooper ARCHITECTS</p>	<p>EarthTech A Tyco International Ltd. Company</p>	ENGINEER'S SEAL	<p>THE CITY OF WINNIPEG WATER AND WASTE DEPARTMENT ENGINEERING DIVISION</p>															
			DESIGNED BY: JZ/SW		CHECKED BY: DL	ORIGINAL SIGNED BY: D.K. CUDDINGTON													
			DRAWN BY: JMcP		APPROVED BY: AHL	2006/03/29													
			SCALE: 1:100		RELEASED FOR CONSTRUCTION BY: R. SOROKOWSKI	CONSULTANT DRAWING NO. WF-H0133													
<table border="1"> <tr> <td>B.M. ELEV.</td> <td></td> </tr> <tr> <td>00 ISSUED FOR TENDER</td> <td>06/03/29 SW</td> </tr> <tr> <td>NO. REVISIONS</td> <td>DATE BY</td> </tr> </table>	B.M. ELEV.		00 ISSUED FOR TENDER	06/03/29 SW	NO. REVISIONS	DATE BY	<table border="1"> <tr> <td>DATE</td> <td>2005/08/02</td> </tr> <tr> <td>DATE</td> <td>2006/03/29</td> </tr> </table>	DATE	2005/08/02	DATE	2006/03/29	<table border="1"> <tr> <td>CITY FILE NUMBER</td> <td></td> </tr> <tr> <td>SHEET OF</td> <td></td> </tr> <tr> <td>CITY DRAWING NUMBER</td> <td>1-0601F-A-H0133-001-000</td> </tr> </table>	CITY FILE NUMBER		SHEET OF		CITY DRAWING NUMBER	1-0601F-A-H0133-001-000	<p>PLUMBING FILTRATION AREA 1 PARTIAL SECOND FLOOR AND THIRD FLOOR PLAN</p>
B.M. ELEV.																			
00 ISSUED FOR TENDER	06/03/29 SW																		
NO. REVISIONS	DATE BY																		
DATE	2005/08/02																		
DATE	2006/03/29																		
CITY FILE NUMBER																			
SHEET OF																			
CITY DRAWING NUMBER	1-0601F-A-H0133-001-000																		