
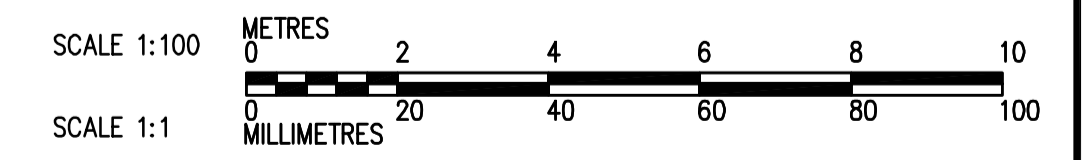


THIRD FLOOR PLAN
1:100

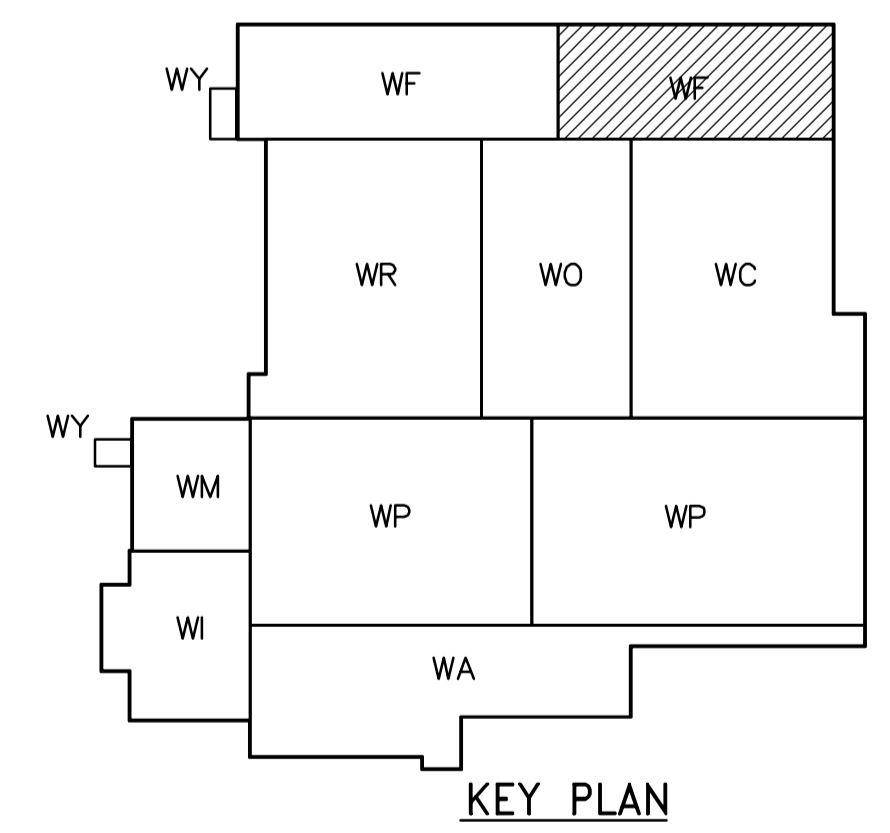

<p>Certificate of Authorization CH2M HILL Canada Ltd. No. 1441 Expiry: April 30, 2006</p>	<p>Frederickson Cooper ARCHITECTS</p>	<p>A You International Ltd. Company</p>	ENGINEER'S SEAL	<p>THE CITY OF WINNIPEG WATER AND WASTE DEPARTMENT ENGINEERING DIVISION</p>
			<p>DESIGNED BY JZ/SW CHECKED BY DL</p> <p>DRAWN BY JMcP APPROVED BY AHL</p> <p>SCALE: 1:100 RELEASED FOR CONSTRUCTION BY: R. SOROKOWSKI</p>	
<p>00 ISSUED FOR TENDER 06/03/29 SW</p> <p>NO. REVISIONS DATE BY</p>	<p>DATE 2005/08/02</p> <p>DATE 2006/03/29</p>	<p>PLUMBING FILTRATION AREA 2 THIRD FLOOR PLAN</p>	<p>CITY DRAWING NUMBER 1-0601F-A-H0134-001-000</p>	