



ROOF PLAN
1:100

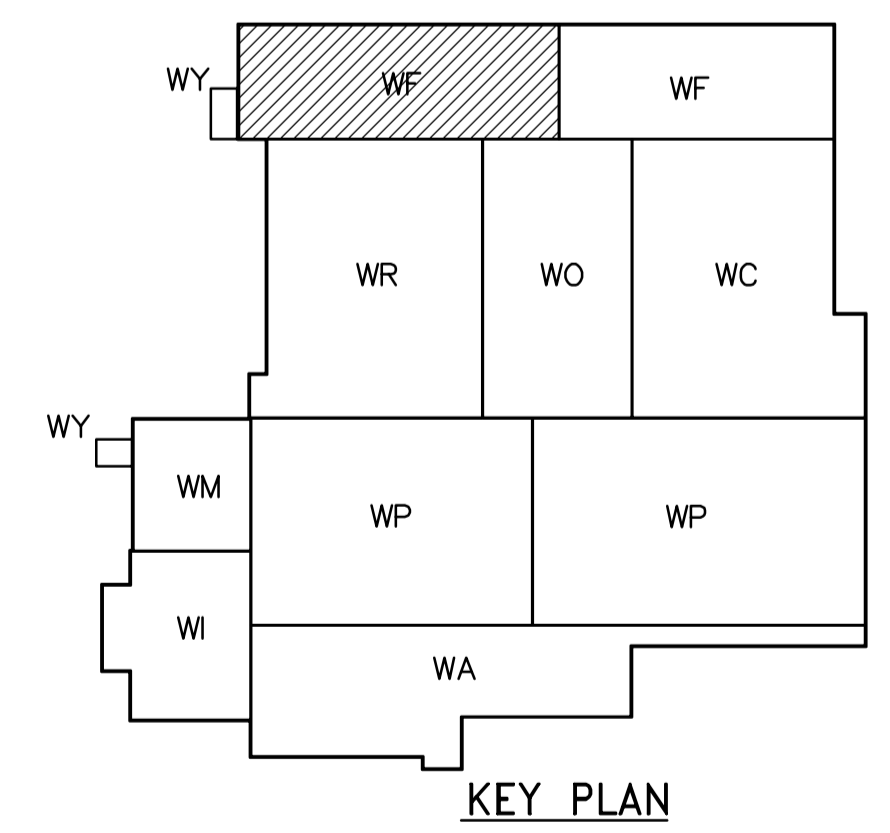

KEY PLAN

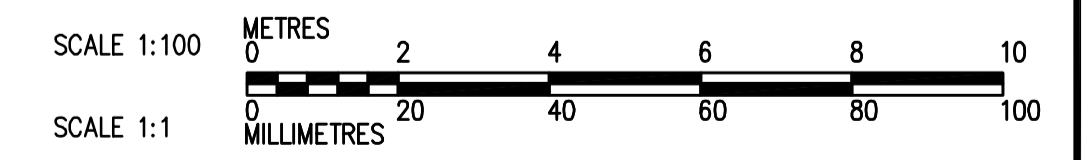

 APEGN Certificate of Authorization CH2M HILL Canada Ltd. No. 1441 Expiry: April 30, 2006	B.M. ELEV.	 Frederickson Cooper ARCHITECTS	 A Terra International Ltd. Company	ENGINEER'S SEAL ORIGINAL SIGNED BY D.K. CUDDINGTON 2006/03/29	 THE CITY OF WINNIPEG WATER AND WASTE DEPARTMENT ENGINEERING DIVISION
	DESIGNED BY: JZ/SW DRAWN BY: JMcP SCALE: 1:100	CHECKED BY: DL APPROVED BY: AHL RELEASED FOR CONSTRUCTION BY: R. SOROKOWSKI	CONSULTANT DRAWING NO. WF-H0143	WATER TREATMENT PLANT FILTRATION MECHANICAL AND ELECTRICAL	PLUMBING FILTRATION AREA 1 ROOF PLAN
	00 ISSUED FOR TENDER 06/03/29 SW	2005/08/02	2006/03/29		