
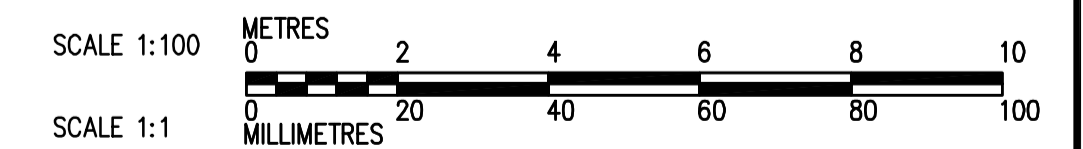


NOT IN CONTRACT - FOR INFORMATION ONLY

THIRD FLOOR PLAN
1:100

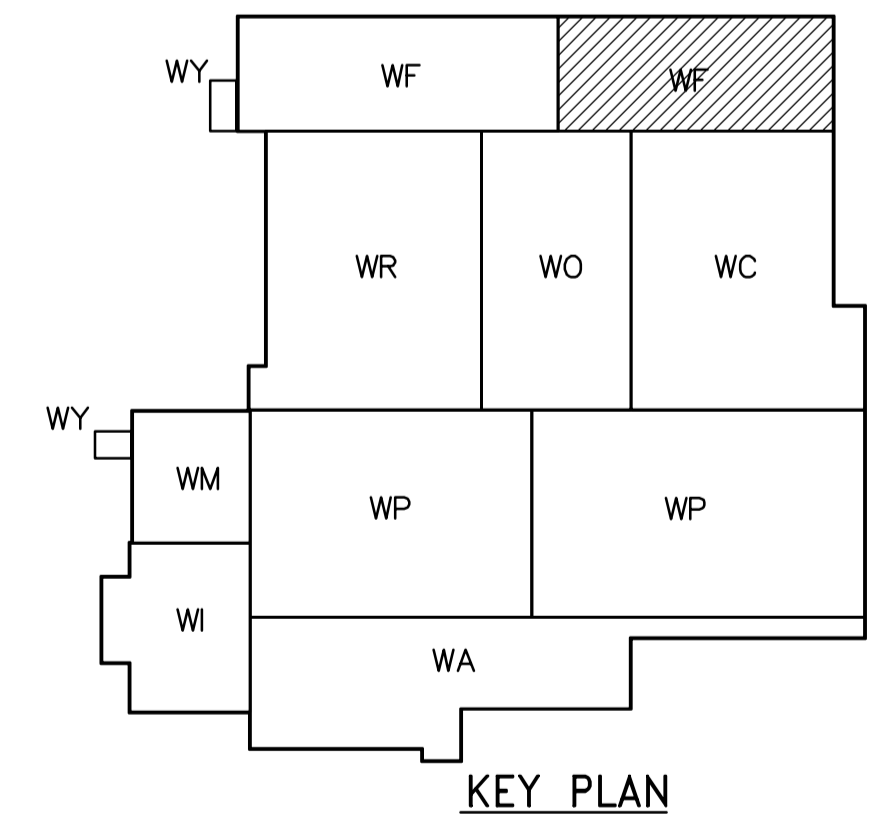

 Certificate of Authorization CH2M HILL Canada Ltd. No. 1441 Expiry: April 30, 2006	 Frederickson Cooper ARCHITECTS	 A Terra International Ltd. Company	ENGINEER'S SEAL ORIGINAL SIGNED BY D.K. CUDDINGTON 2006/02/06	 THE CITY OF WINNIPEG WATER AND WASTE DEPARTMENT ENGINEERING DIVISION	CITY FILE NUMBER SHEET OF CITY DRAWING NUMBER 1-060F-A-H9134-001-00D
	DESIGNED BY JZ/SW CHECKED BY DL	DRAWN BY JMcP APPROVED BY DJT	CONSULTANT DRAWING NO. WF-H9134	WATER TREATMENT PLANT FILTRATION FOUNDATIONS AND CONCRETE STRUCTURES	
	SCALE: 1:100	RELEASED FOR CONSTRUCTION BY: R. SOROKOWSKI	PLUMBING PIPE EMBEDS FILTRATION AREA 2 THIRD FLOOR PLAN		
	00 ISSUED FOR TENDER 2006/02/03 SW	INO. REVISIONS DATE BY DATE 2005/08/02 DATE 2006/02/08			