



NOT IN CONTRACT - FOR INFORMATION ONLY

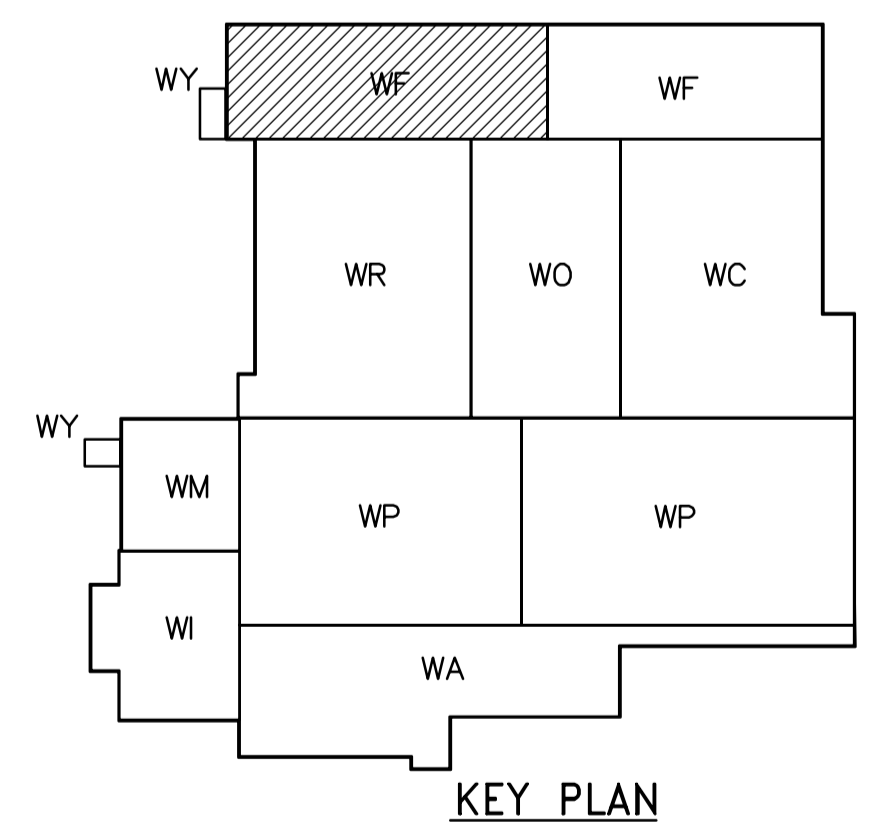

PLAN AT ELEVATION 245.000  
1:100

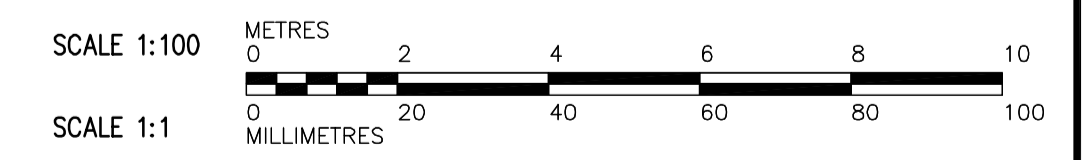

 <b>APEGN</b> Certificate of Authorization CH2M HILL Canada Ltd. No. 1441 Expiry: April 30, 2006	 Frederickson Cooper ARCHITECTS	 A You International Ltd. Company	B.M. ELEV.	ENGINEER'S SEAL  ORIGINAL SIGNED BY P. WOBMA 2006/02/06	 <b>THE CITY OF WINNIPEG</b> WATER AND WASTE DEPARTMENT ENGINEERING DIVISION
			DESIGNED BY: TB/PW CHECKED BY: LS DRAWN BY: TAR/EK APPROVED BY: DJT SCALE: 1:100 RELEASED FOR CONSTRUCTION BY: R. SOROKOWSKI		
WATER TREATMENT PLANT FILTRATION FOUNDATION AND CONCRETE STRUCTURES			PROCESS MECHANICAL PIPE EMBEDS FILTRATION AREA 1 THIRD FLOOR PLAN	CITY FILE NUMBER SHEET OF CITY DRAWING NUMBER <b>1-0607-A-M9131-001-00D</b>	