
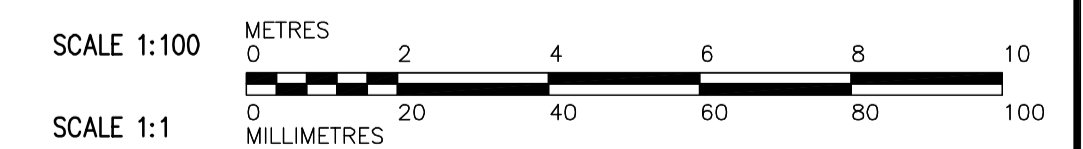


NOT IN CONTRACT - FOR INFORMATION ONLY

**NOTES:**

1. BACKGROUND HIDDEN LINES REVISED OR SHOWN FOR CLARITY.

PLAN AT ELEVATION 245.000  
1:100

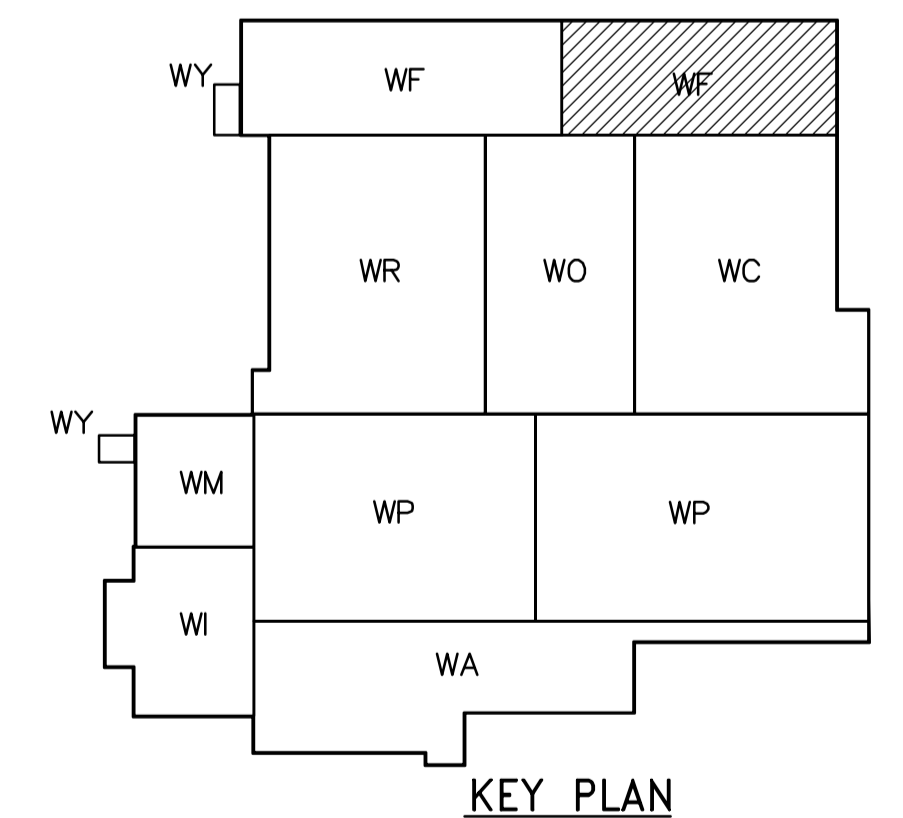

 <b>APEGN</b> Certificate of Authorization CH2M HILL Canada Ltd. No. 1441 Expiry: April 30, 2006	B.M. ELEV.	 Frederickson Cooper ARCHITECTS	 A Terra International Ltd. Company	ENGINEER'S SEAL		 <b>THE CITY OF WINNIPEG</b> WATER AND WASTE DEPARTMENT ENGINEERING DIVISION	WATER TREATMENT PLANT FILTRATION FOUNDATION AND CONCRETE STRUCTURES	CITY FILE NUMBER		
				DESIGNED BY: TB/PW	CHECKED BY: LS			ORIGINAL SIGNED BY: P. WOBMA		SHEET OF
				DRAWN BY: TAR/EK	APPROVED BY: DJT			2006/02/06		CITY DRAWING NUMBER
				SCALE: 1:100	RELEASED FOR CONSTRUCTION BY: R. SOROKOWSKI			CONSULTANT DRAWING NO. WF-M9132		<b>1-060F-A-M9132-001-01D</b>
	NO. REVISIONS	DATE	BY	DATE	DATE	PROCESS MECHANICAL PIPE EMBEDS FILTRATION AREA 2 THIRD FLOOR PLAN				