
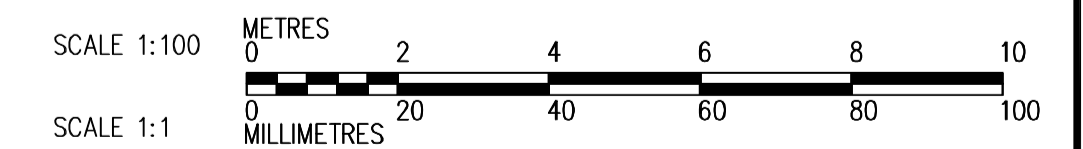


- NOTES:**
1. ALL 120V AND 208V LOADS ARE FED FROM LP-M11.
 2. EMERGENCY LIGHTING EM-X-1 ARE FED FROM BATTERY PACK EM-X.
 3. MOUNT TYPE A LUMINAIRE AT 3.0m ABOVE THE FLOOR.

THIRD FLOOR POWER AND LIGHTING PLAN
1:100

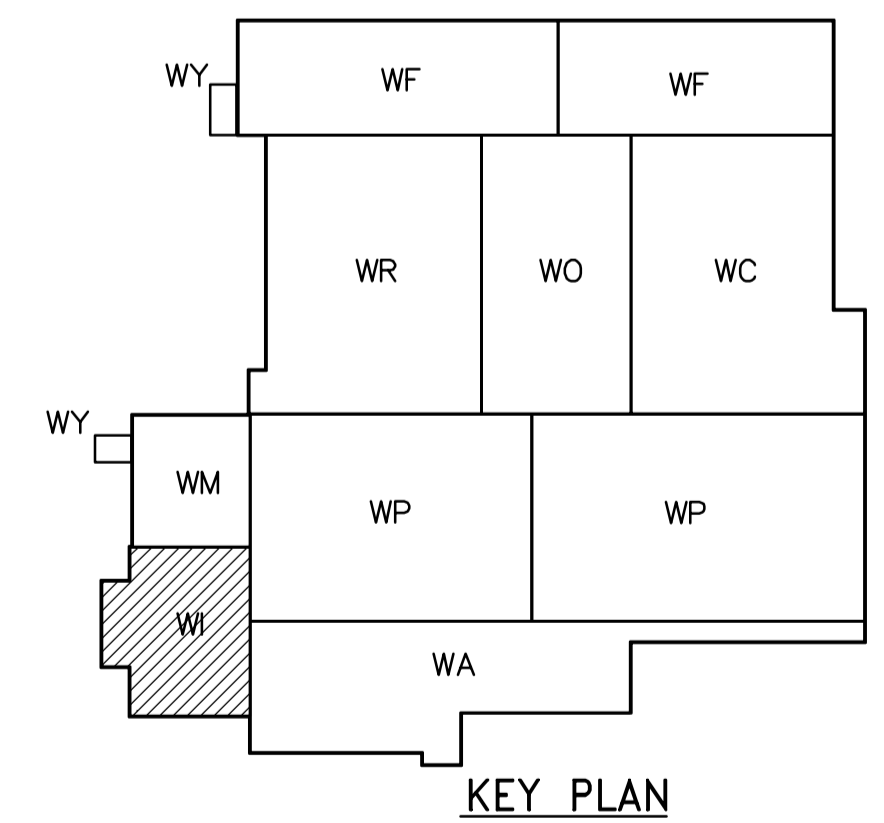

<p>APEGN Certificate of Authorization CH2M HILL Canada Ltd. No. 1441 Expiry: April 30, 2006</p>	<p>Frederickson Cooper ARCHITECTS</p>	<p>A You International Ltd. Company</p>	ENGINEER'S SEAL ORIGINAL SIGNED BY L.D. LLEWELLYN 2006/03/29	<p>THE CITY OF WINNIPEG WATER AND WASTE DEPARTMENT ENGINEERING DIVISION</p>
	DESIGNED BY: LL CHECKED BY: ND	DRAWN BY: TL APPROVED BY: AHL	CONSULTANT DRAWING NO. WI-E0133	
	SCALE: 1:100 RELEASED FOR CONSTRUCTION BY: R. SOROKOWSKI	DATE: 2005/07/13 DATE: 2006/03/29		
	B.M. ELEV.	NO. REVISIONS DATE BY	WATER TREATMENT PLANT INLET WORKS AND RAW WATER PUMPING MECHANICAL AND ELECTRICAL	