


FIRST FLOOR PLAN
1:100

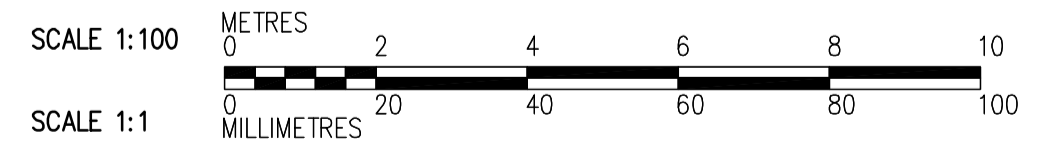

<p>APEGN Certificate of Authorization CH2M HILL Canada Ltd. No. 1441 Expiry: April 30, 2006</p>	B.M. ELEV.	 Frederickson Cooper ARCHITECTS	 A Terra International Ltd. Company	ENGINEER'S SEAL ORIGINAL SIGNED BY D.K. CUDDINGTON 2006/03/29	<p>THE CITY OF WINNIPEG WATER AND WASTE DEPARTMENT ENGINEERING DIVISION</p> <p>WATER TREATMENT PLANT INLET WORKS AND RAW WATER PUMPING MECHANICAL AND ELECTRICAL</p> <p>HVAC RAW WATER PUMP STATION AREA FIRST FLOOR PLAN</p>	CITY FILE NUMBER
	00 ISSUED FOR TENDER 06/03/29 TT	DESIGNED BY TT CHECKED BY DL DRAWN BY AM APPROVED BY AHL	CONSULTANT DRAWING NO. WI-H0111	SHEET OF		
	NO. REVISIONS DATE BY	SCALE: 1:100 RELEASED FOR CONSTRUCTION BY: R. SOROKOWSKI DATE 2005/07/04 DATE 2006/03/29	CITY DRAWING NUMBER 1-06011-A-H0111-001-000			