




LOWER LEVEL PLAN
1:100

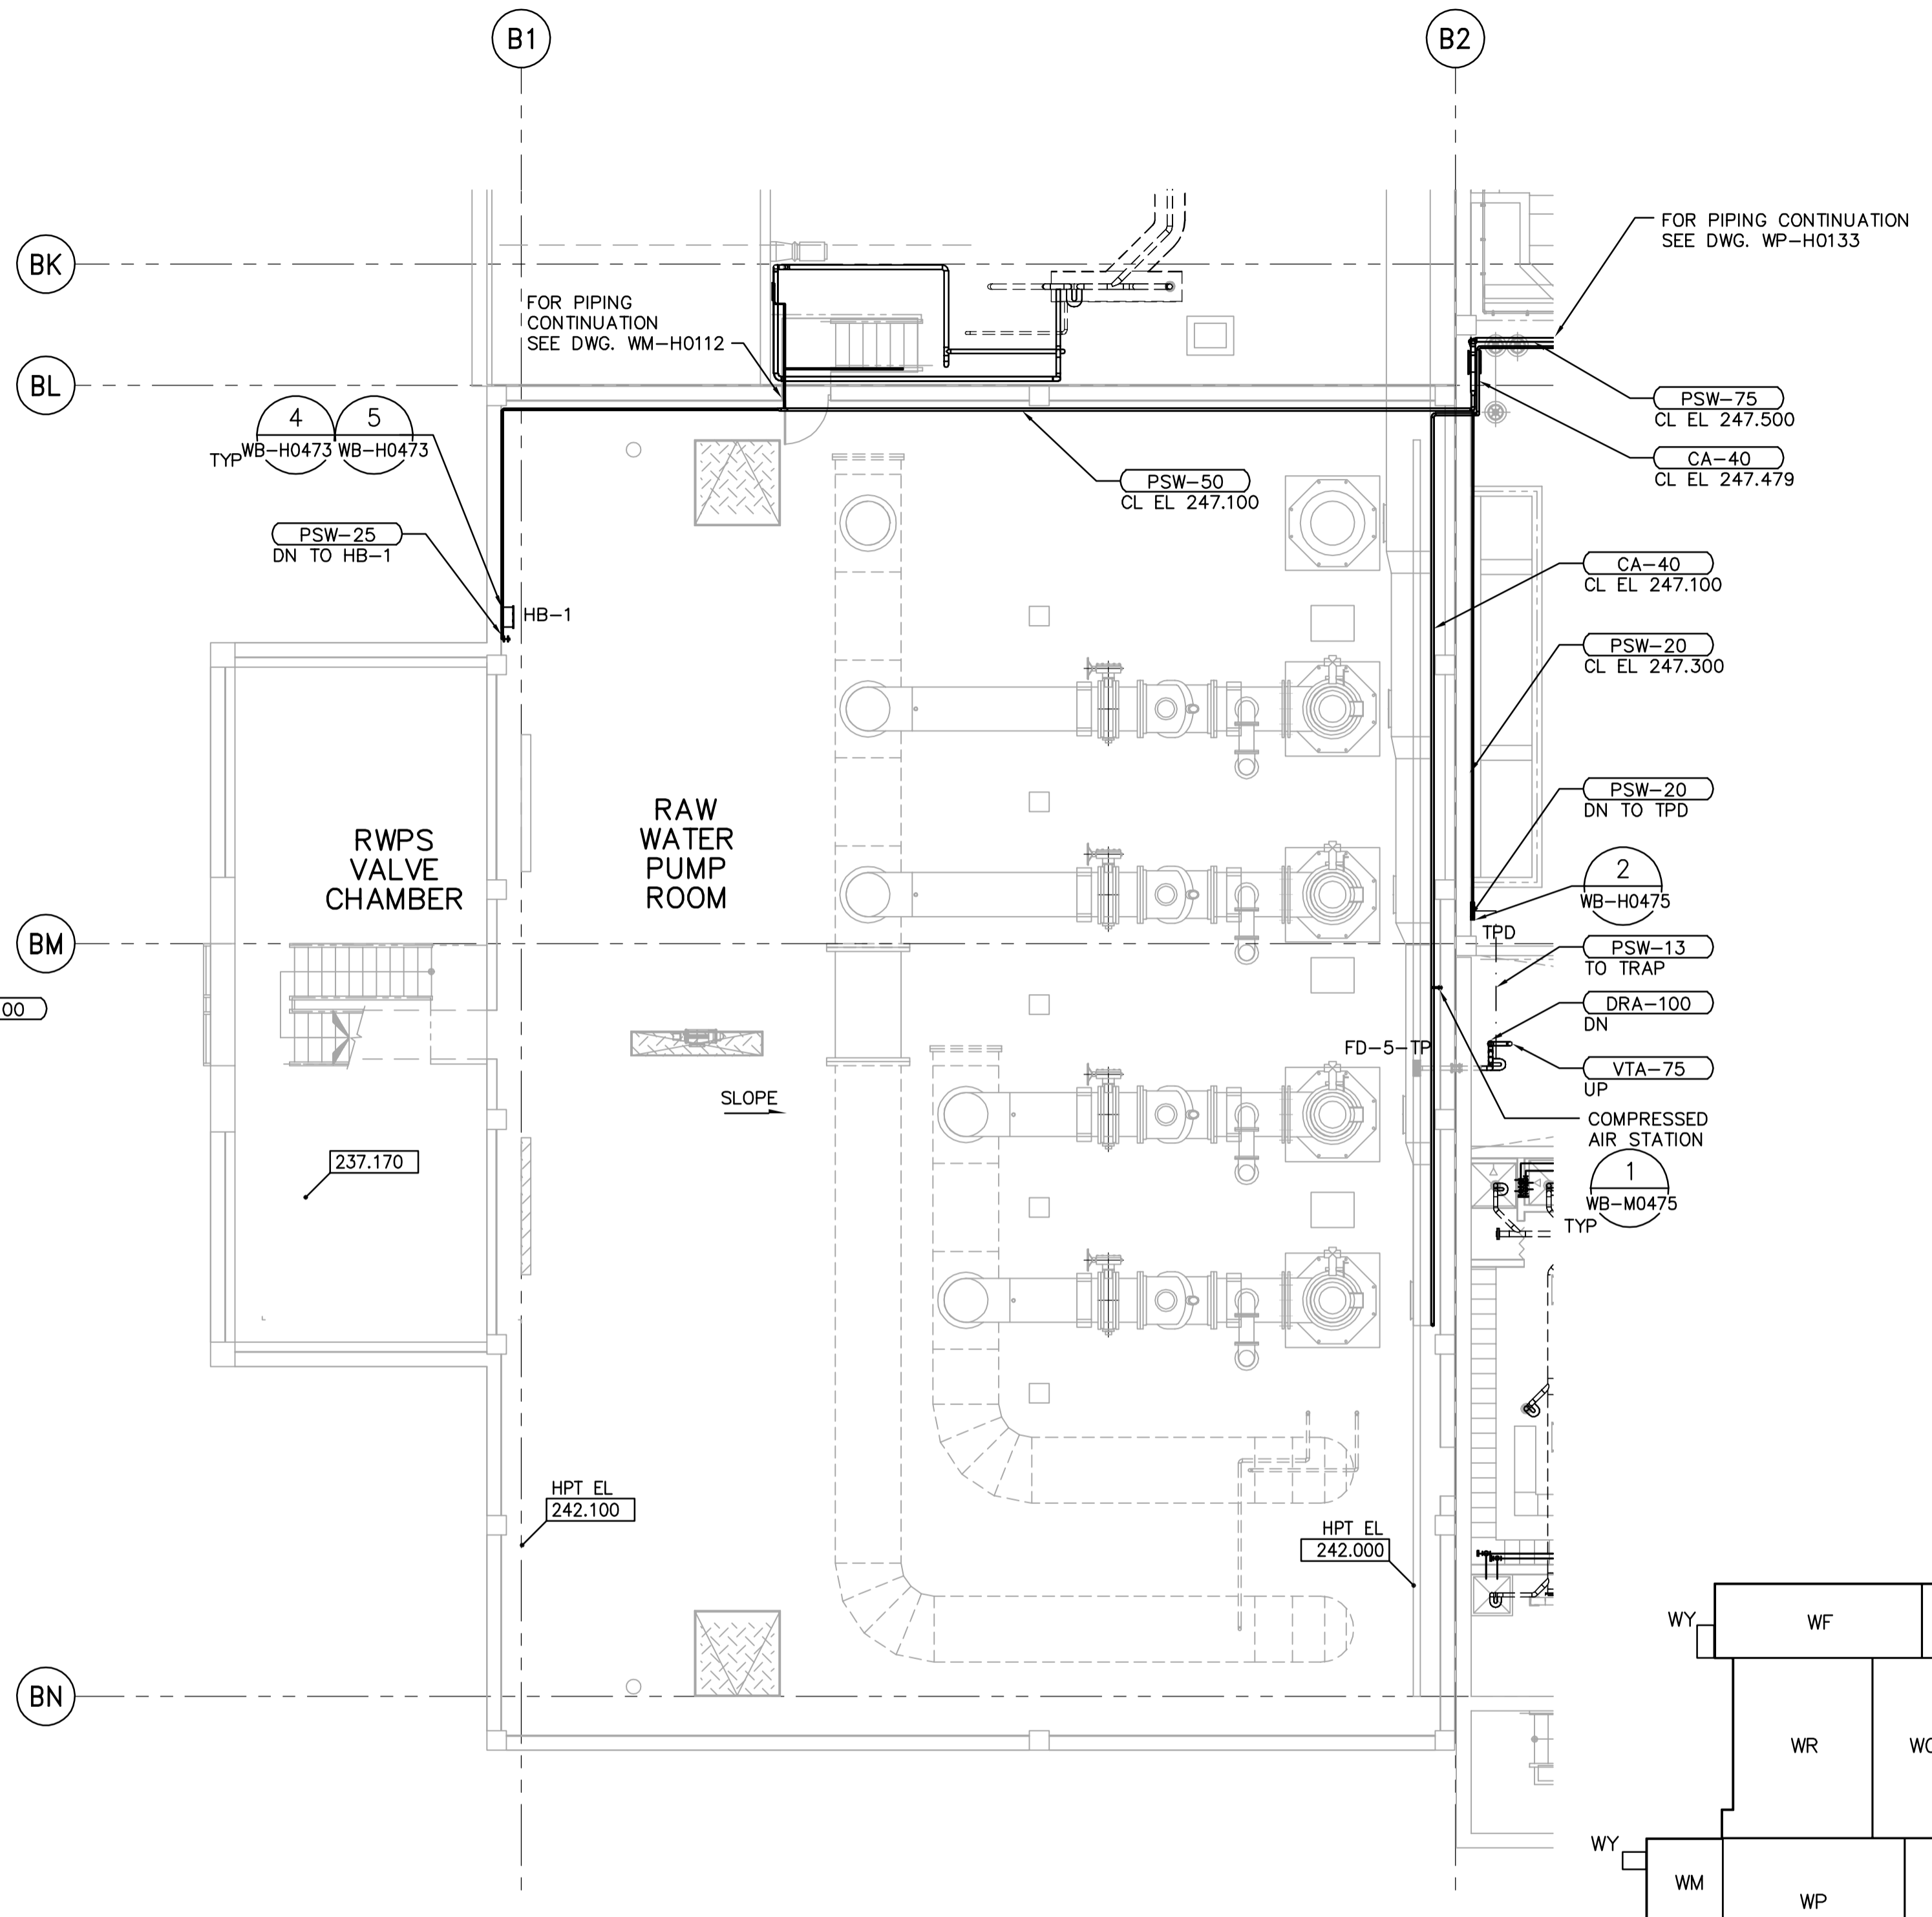

THIRD FLOOR PLAN
1:100

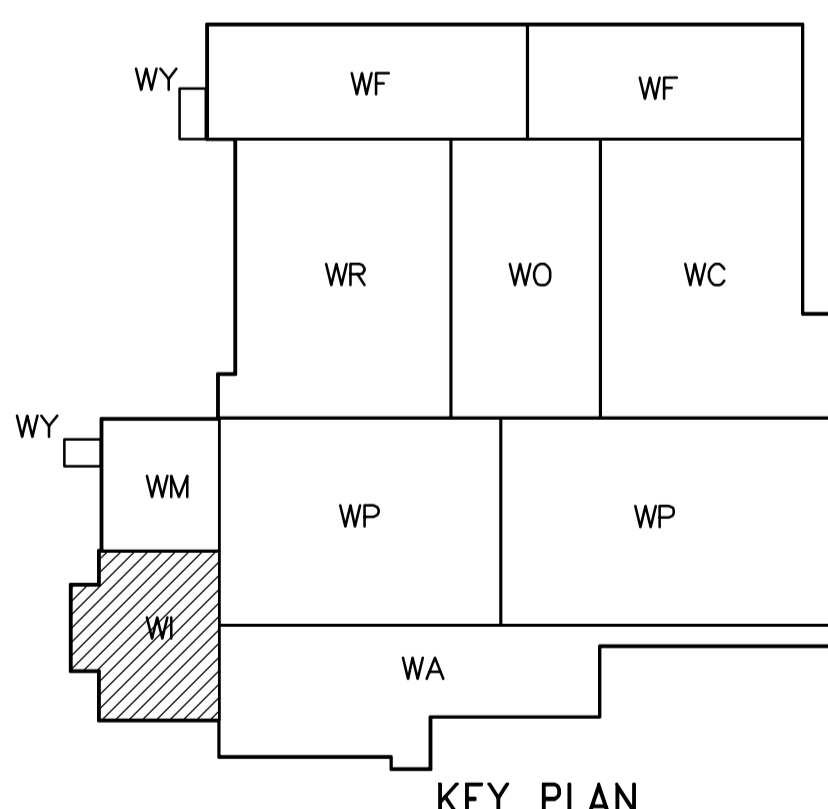

KEY PLAN

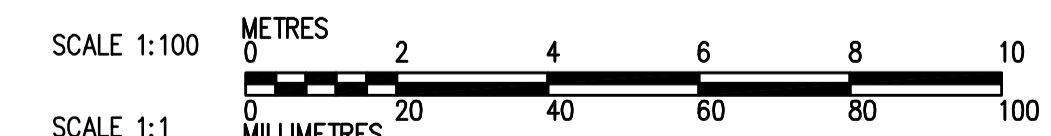

<p>APEGN Certificate of Authorization CH2M HILL Canada Ltd. No. 1441 Expiry: April 30, 2006</p>	<p>Frederickson Cooper ARCHITECTS</p>	<p>EarthTech A Tyco International Ltd. Company</p>	ENGINEER'S SEAL ORIGINAL SIGNED BY D.K. CUDDINGTON 2006/03/29	<p>THE CITY OF WINNIPEG WATER AND WASTE DEPARTMENT ENGINEERING DIVISION</p>
			CONSULTANT DRAWING NO. W-H0122	
DESIGNED BY: JZ/SW CHECKED BY: DL DRAWN BY: JMcP APPROVED BY: AHL SCALE: 1:100 RELEASED FOR CONSTRUCTION BY: R. SOROKOWSKI			PLUMBING RAW WATER PUMP STATION LOWER LEVEL AND THIRD FLOOR PLANS	CITY DRAWING NUMBER 1-06011-A-H0122-001-000
B.M. ELEV. NO. REVISIONS DATE BY	00 ISSUED FOR TENDER 06/03/29 SW	DATE BY 2005/08/02	DATE BY 2006/03/29	