




LOWER LEVEL PLAN
1:50

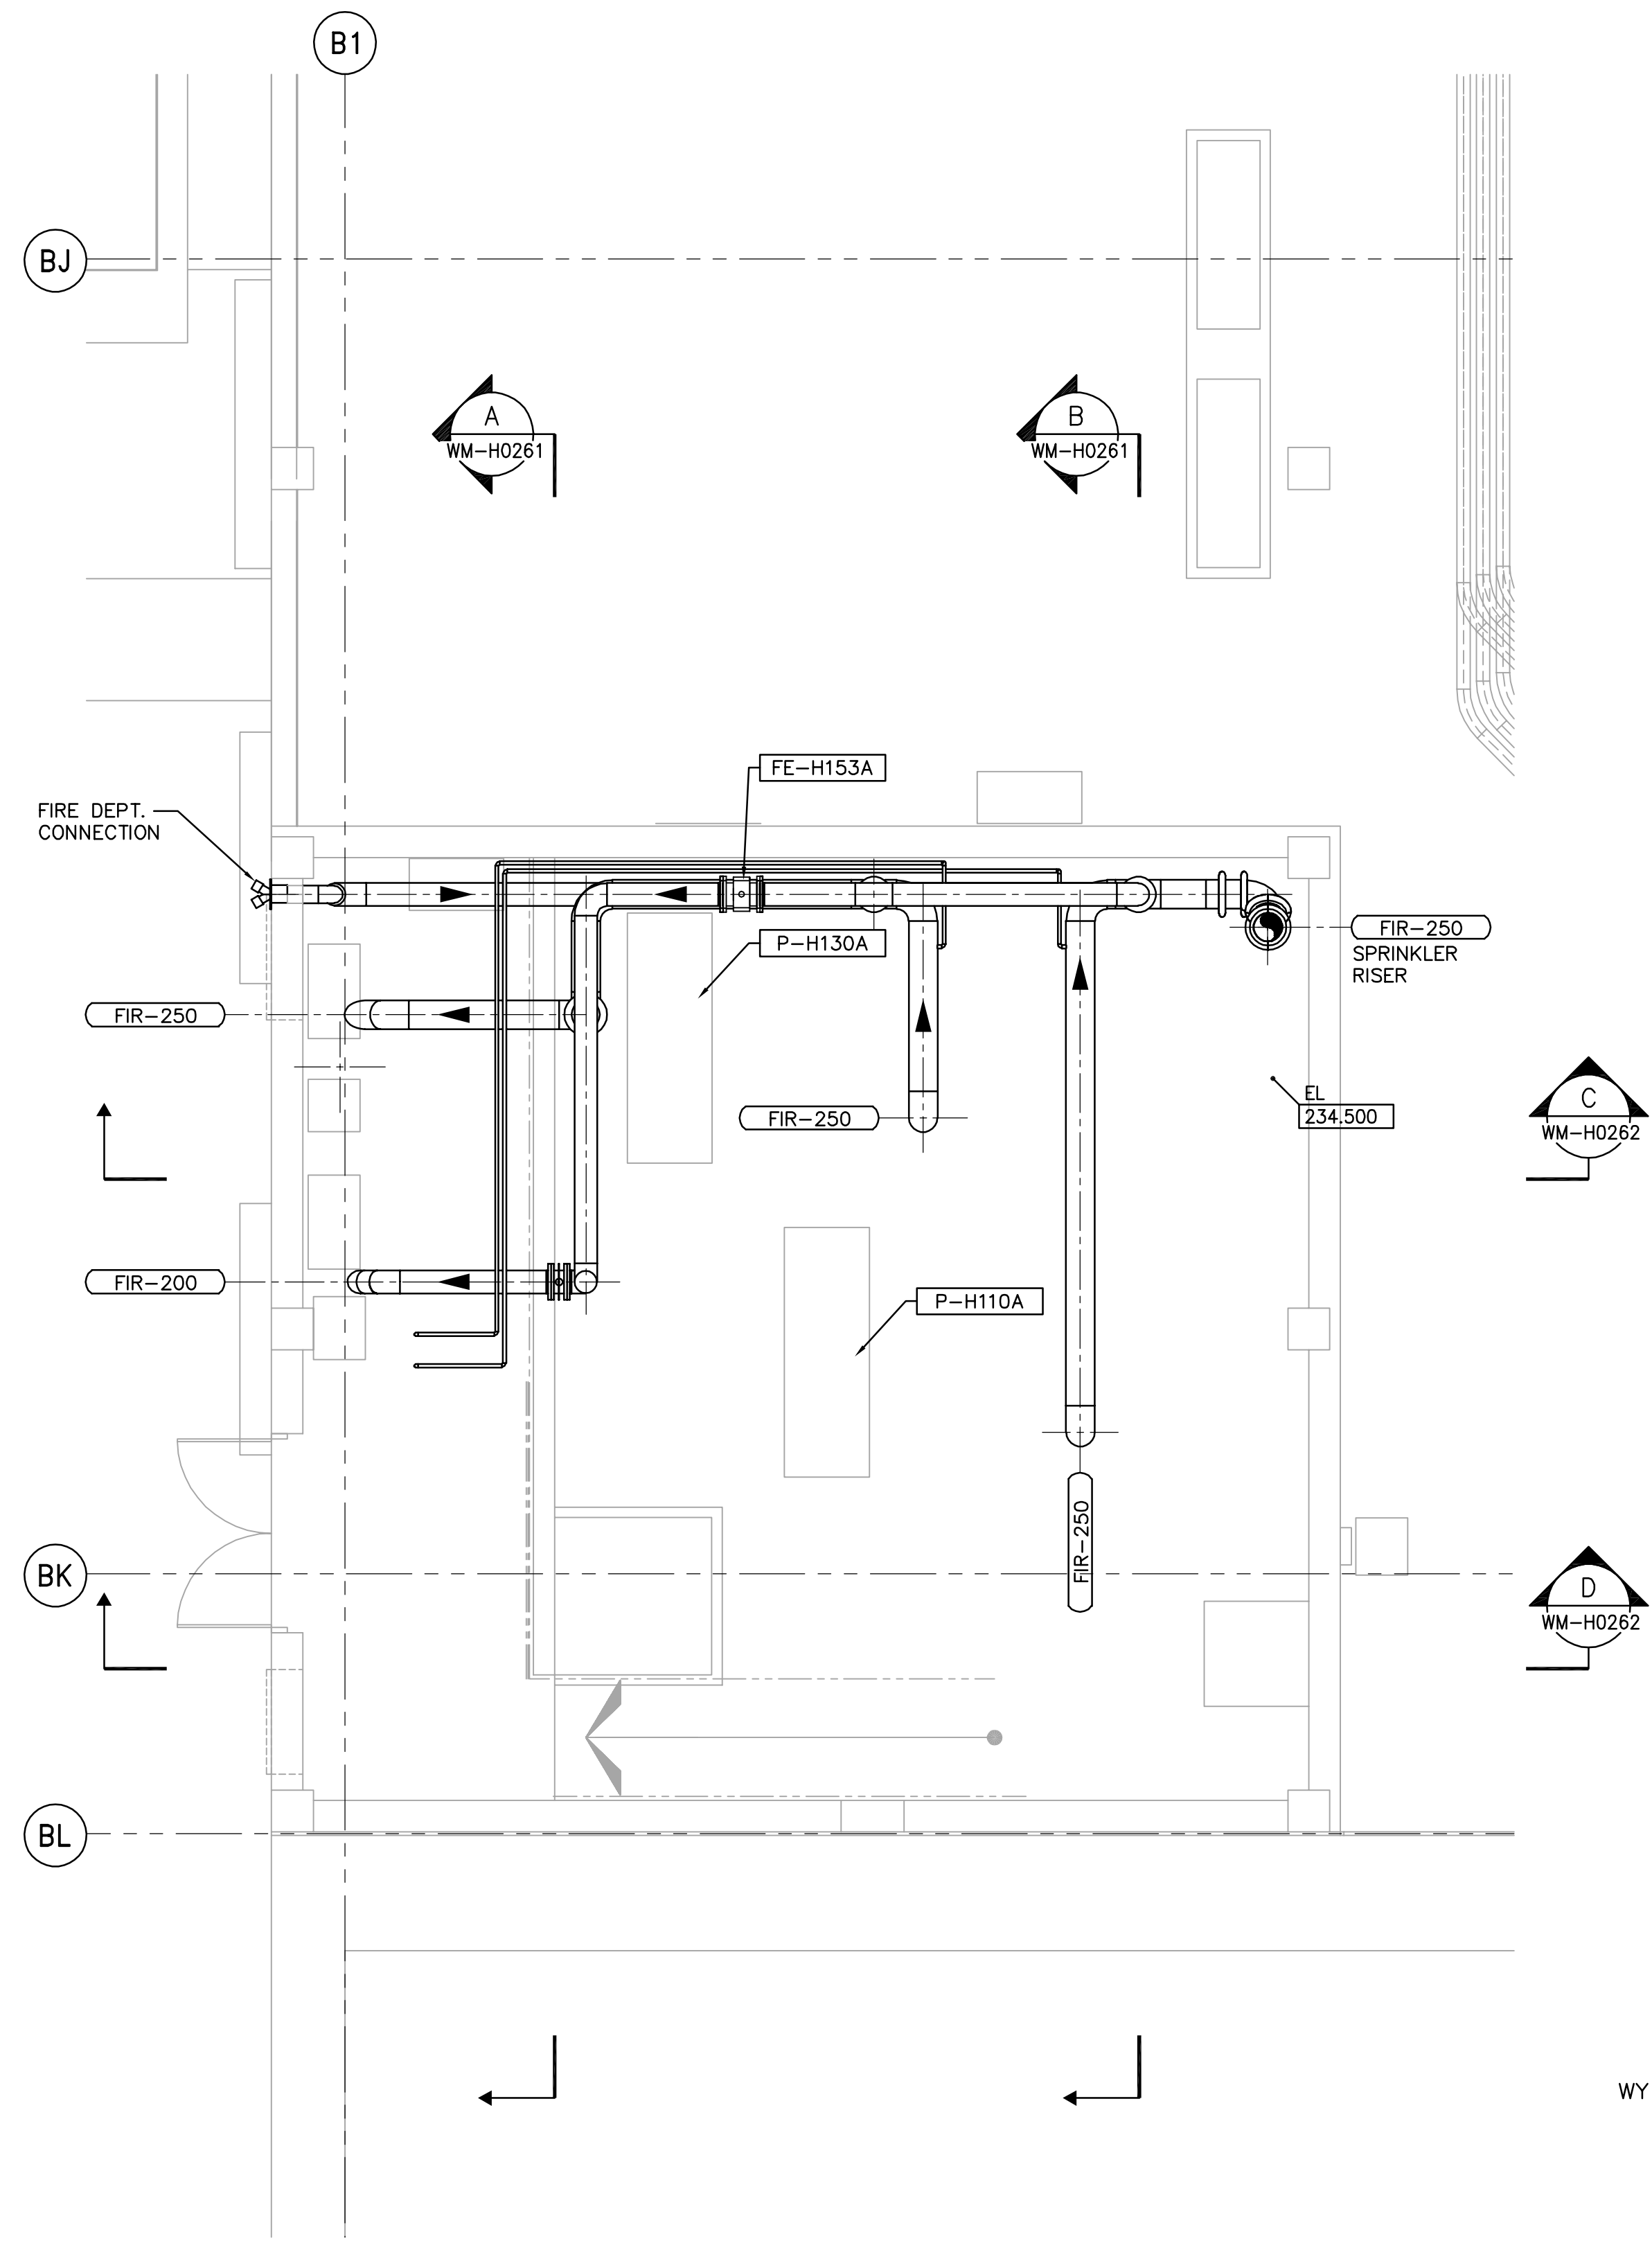

FIRST FLOOR PLAN
1:50

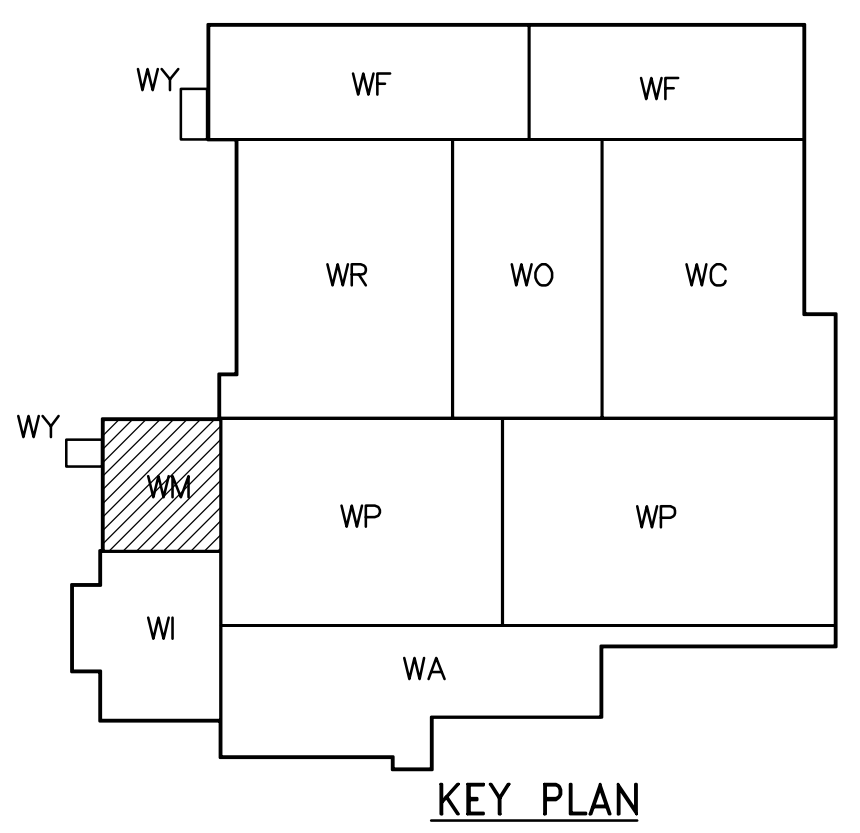

KEY PLAN

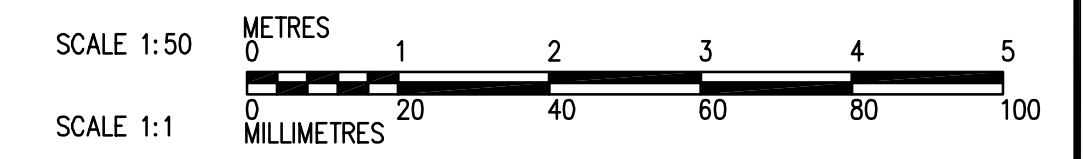

<p>APEGN Certificate of Authorization CH2M HILL Canada Ltd. No. 1441 Expiry: April 30, 2006</p>	<p>Frederickson Cooper ARCHITECTS</p>	<p>EarthTech A Tyco International Ltd. Company</p>	ENGINEER'S SEAL ORIGINAL SIGNED BY D.K. CUDDINGTON 2006/03/29	<p>THE CITY OF WINNIPEG WATER AND WASTE DEPARTMENT ENGINEERING DIVISION</p>
			DESIGNED BY DKC CHECKED BY SW DRAWN BY JMcP APPROVED BY AHL SCALE: 1:50 RELEASED FOR CONSTRUCTION BY: R. SOROKOWSKI 2006/01/06	
B.M. ELEV.			WATER TREATMENT PLANT GENERAL PLANT SERVICES/MISCELLANEOUS MECHANICAL AND ELECTRICAL	
00 ISSUED FOR TENDER 06/03/29 SW NO. REVISIONS DATE BY DATE 2006/01/06 DATE 2006/03/29			CITY FILE NUMBER SHEET OF CITY DRAWING NUMBER 1-0601M-A-H0113-001-000	