
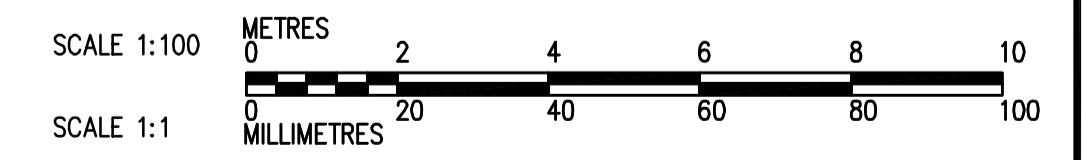


FIRST FLOOR PLAN
1:100

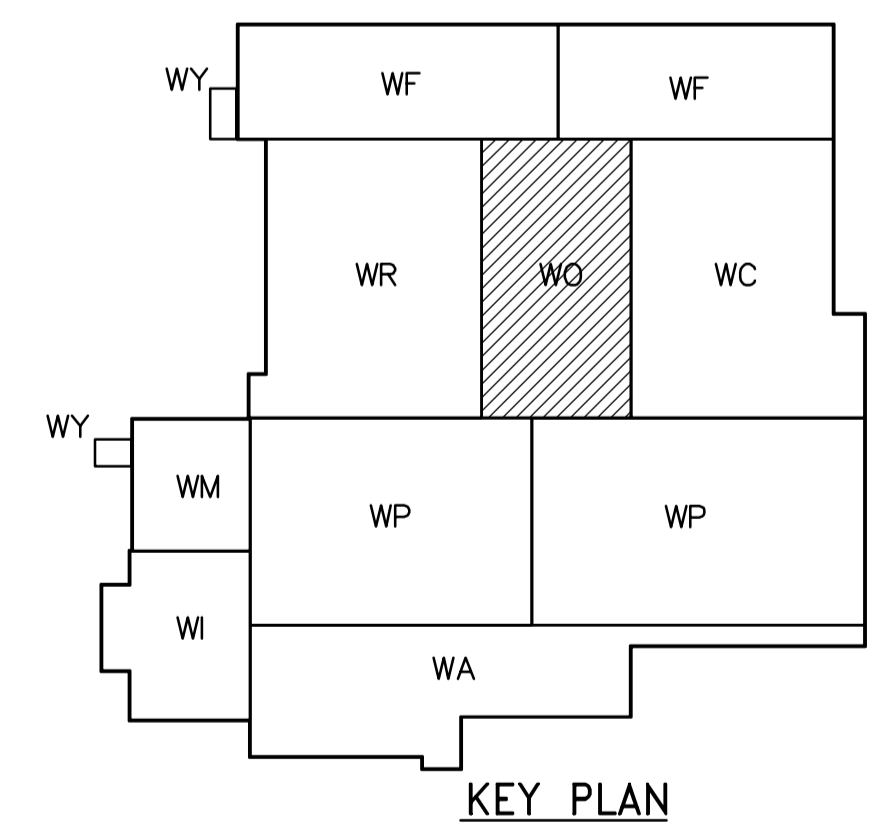

<p>APEGN Certificate of Authorization CH2M HILL Canada Ltd. No. 1441 Expiry: April 30, 2006</p>	<table border="1"> <tr> <td>B.M. ELEV.</td> <td></td> <td></td> <td></td> </tr> <tr> <td>NO.</td> <td>REVISIONS</td> <td>DATE</td> <td>BY</td> </tr> <tr> <td>00</td> <td>ISSUED FOR TENDER</td> <td>06/03/29</td> <td>SW</td> </tr> </table>	B.M. ELEV.				NO.	REVISIONS	DATE	BY	00	ISSUED FOR TENDER	06/03/29	SW	<p>Frederickson Cooper ARCHITECTS</p>	<p>A You International Ltd. Company</p>	<p>ENGINEER'S SEAL</p> <p>ORIGINAL SIGNED BY D.K. CUDDINGTON</p> <p>2006/03/29</p>	<p>THE CITY OF WINNIPEG WATER AND WASTE DEPARTMENT ENGINEERING DIVISION</p>
		B.M. ELEV.															
NO.	REVISIONS	DATE	BY														
00	ISSUED FOR TENDER	06/03/29	SW														
<p>DESIGNED BY: JZ/SW</p> <p>CHECKED BY: DL</p> <p>DRAWN BY: JMcP</p> <p>APPROVED BY: AHL</p> <p>SCALE: 1:100</p> <p>RELEASED FOR CONSTRUCTION BY: R. SOROKOWSKI</p> <p>DATE: 2005/08/02</p> <p>DATE: 2006/03/29</p>	<p>CONSULTANT DRAWING NO. WO-H0112</p>	<p>WATER TREATMENT PLANT OZONE MECHANICAL AND ELECTRICAL</p>	<p>CITY FILE NUMBER</p> <p>SHEET OF</p> <p>CITY DRAWING NUMBER 1-06010-A-H0112-001-000</p>														