
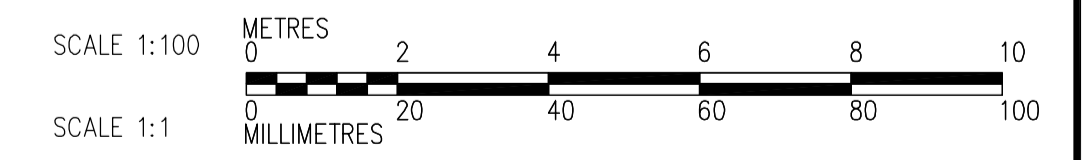


- NOTES:**
- SEE MCC #2A & #2B SINGLE LINE DIAGRAM AND DP-P11 & DP-P12 POWER DISTRIBUTION FOR 600V POWER DISTRIBUTION.
 - SEE LP-P11 FOR 120/208V POWER DISTRIBUTION.
 - PROVIDE STAIRWELL SMOKE DETECTORS AT EVERY THIRD FLOOR AND AT TOP.

ACCESS CORRIDOR No. 1
FL EL 236.170

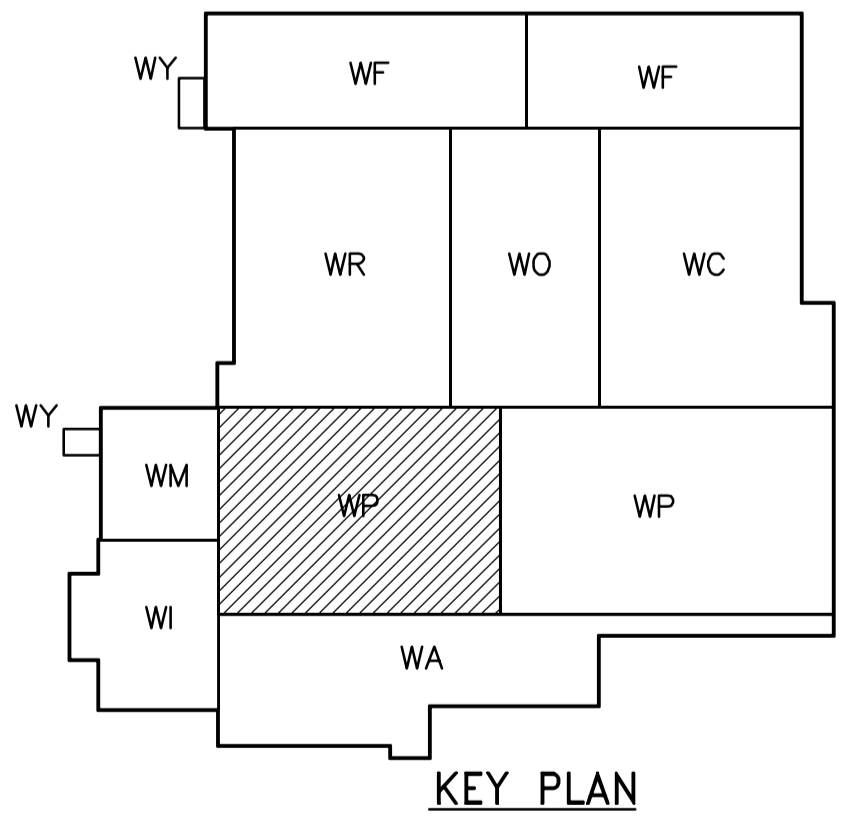

FIRST FLOOR FACILITY PLAN (AREA 1)
1:100

CABLE TRAY TAGGING
SEE DETAIL
3
WB-E0455

<p>APEGN Certificate of Authorization CH2M HILL Canada Ltd. No. 1441 Expiry: April 30, 2006</p>	<p>Frederickson Cooper ARCHITECTS</p>	<p>EarthTech A Tyco International Ltd. Company</p>	ENGINEER'S SEAL ORIGINAL SIGNED BY L.D. LLEWELLYN 2006/03/29	<p>THE CITY OF WINNIPEG WATER AND WASTE DEPARTMENT ENGINEERING DIVISION</p>	
			CONSULTANT DRAWING NO. WP-E0111		WATER TREATMENT PLANT FLOCCULATION AND DAF MECHANICAL AND ELECTRICAL
DESIGNED BY JT CHECKED BY ND DRAWN BY KJ APPROVED BY AHL		SCALE: 1:100 RELEASED FOR CONSTRUCTION BY: R. SOROKOWSKI		ELECTRICAL FLOC/DAF AREA 1 FIRST FLOOR FACILITY PLAN	
00 ISSUED FOR TENDER 06/03/29 LL NO. REVISIONS DATE BY		DATE 2005/07/12 DATE 2006/03/29			