



- NOTES:**
1. ALL 120V AND 208V LOADS ARE FED FROM LP-P11.
 2. EMERGENCY LIGHTING EM-X-1, -2 ETC ARE FED FROM BATTERY PACK EM-X.

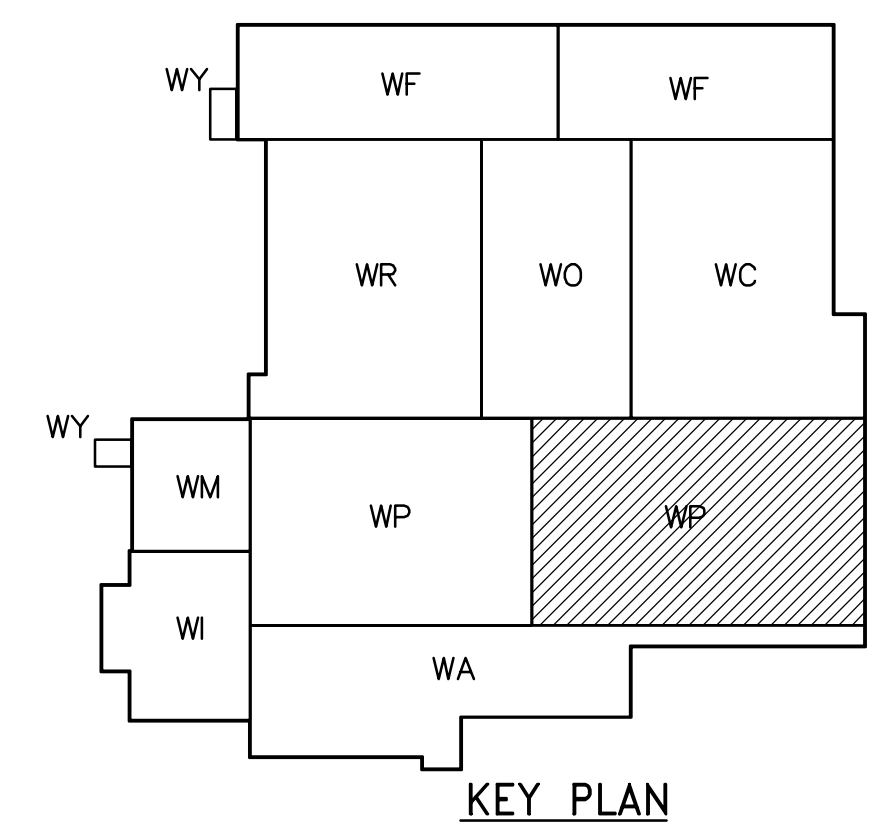

FIRST FLOOR POWER AND LIGHTING PLAN (AREA 2)
1:100

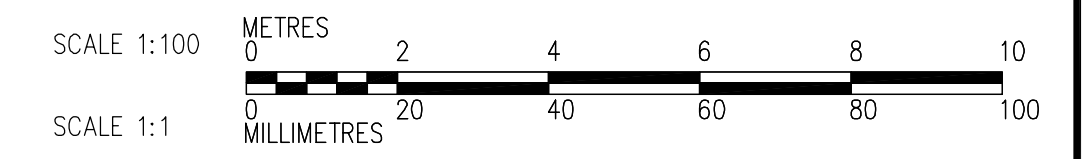

<p>APEGN Certificate of Authorization CH2M HILL Canada Ltd. No. 1441 Expiry: April 30, 2006</p>	<p>Frederickson Cooper ARCHITECTS</p>		<p>EarthTech A Tyco International Ltd. Company</p>		ENGINEER'S SEAL ORIGINAL SIGNED BY L.D. LLEWELLYN 2006/03/29	<p>THE CITY OF WINNIPEG WATER AND WASTE DEPARTMENT ENGINEERING DIVISION</p>	WATER TREATMENT PLANT FLOCCULATION AND DAF MECHANICAL AND ELECTRICAL	CITY FILE NUMBER SHEET OF
	DESIGNED BY JT CHECKED BY ND DRAWN BY KJ APPROVED BY AHL		SCALE: 1:100 RELEASED FOR CONSTRUCTION BY: R. SOROKOWSKI		CONSULTANT DRAWING NO. WP-E0116		ELECTRICAL FLOC/DAF AREA 2 FIRST FLOOR POWER AND LIGHTING PLAN	CITY DRAWING NUMBER 1-0601P-A-E0116-001-000
	00 ISSUED FOR TENDER 06/03/29 LL		SCALE: 1:100 RELEASED FOR CONSTRUCTION BY: R. SOROKOWSKI		CONSULTANT DRAWING NO. WP-E0116		ELECTRICAL FLOC/DAF AREA 2 FIRST FLOOR POWER AND LIGHTING PLAN	CITY DRAWING NUMBER 1-0601P-A-E0116-001-000
	NO. REVISIONS DATE BY		DATE 2005/07/12 DATE 2006/03/29					