



- NOTES:
1. SEE MCC 4A & 4B SINGLE LINE DIAGRAMS AND PANEL SCHEDULES DP-H31 AND DP-H32 FOR 600V POWER DISTRIBUTION
 2. SEE DRAWINGS WB-E0402 AND WB-E0403 FOR FLOCCULATION TANK EQUIPMENT WIRING DETAILS
 3. SEE DRAWINGS WB-E0402 AND WB-E0403 FOR CABLE TRAY MOUNTING DETAILS
 4. ALL 120V AND 208V LOADS ARE FED FROM LP-P31

FOR CABLE TRAY TAGGING SEE DETAIL 3
WB-E0455

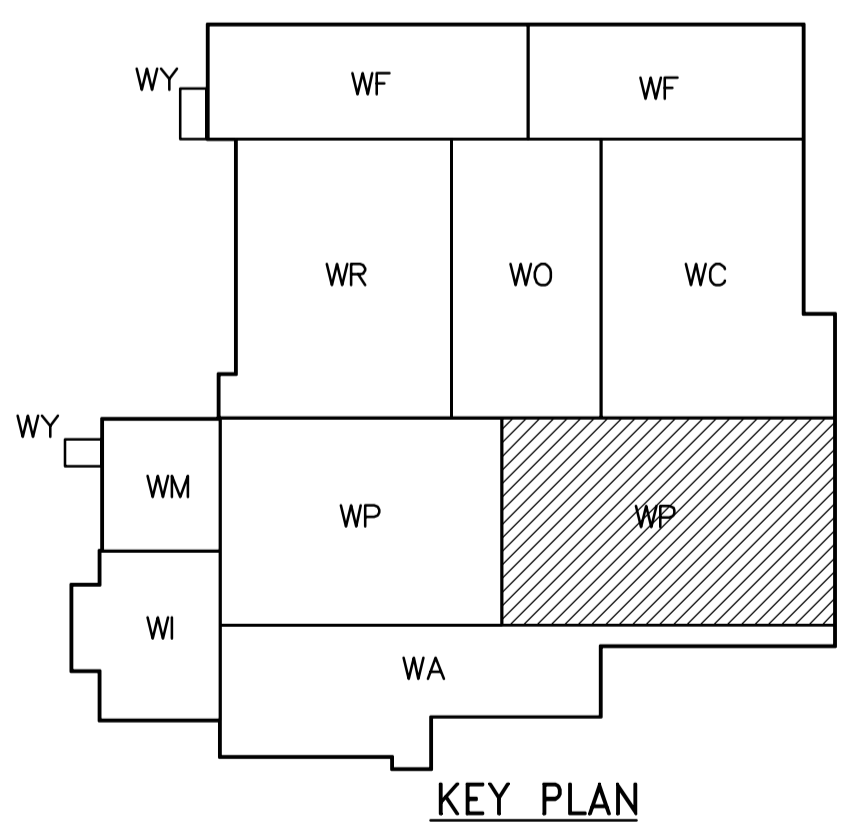

THIRD FLOOR FACILITY PLAN 2
1:100

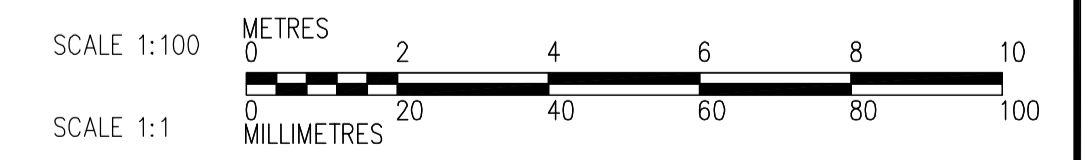

<p>APEGN Certificate of Authorization CH2M HILL Canada Ltd. No. 1441 Expiry: April 30, 2006</p>	<p>Frederickson Cooper ARCHITECTS</p>	<p>A You International Ltd. Company</p>	ENGINEER'S SEAL	<p>THE CITY OF WINNIPEG WATER AND WASTE DEPARTMENT ENGINEERING DIVISION</p>
			DESIGNED BY: LL CHECKED BY: ND DRAWN BY: TL APPROVED BY: AHL SCALE: 1:100 RELEASED FOR CONSTRUCTION BY: R. SOROKOWSKI DATE: 2005/07/12 DATE: 2006/03/29	
B.M. ELEV. _____ NO. REVISIONS _____ DATE BY _____ 00 ISSUED FOR TENDER 06/03/29 LL NO. REVISIONS _____ DATE BY _____				