
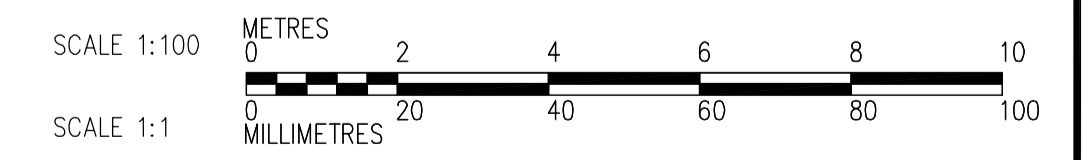


- NOTES:**
- SEE MCC 4A & 4B SINGLE LINE DIAGRAMS AND PANEL SCHEDULES DP-H31 AND DP-H32 FOR 600V POWER DISTRIBUTION.
 - SEE DRAWINGS WB-E0402 AND WB-E0403 FOR FLOCCULATION TANK EQUIPMENT WIRING DETAILS.
 - SEE CABLE CLOCK DIAGRAMS CBD-P-31 THROUGH CBD-P-39 FOR DAF EQUIPMENT AND INSTRUMENT INTERCONNECTION WIRING REQUIREMENTS.

THIRD FLOOR PROCESS PLAN (AREA 1)
1:100

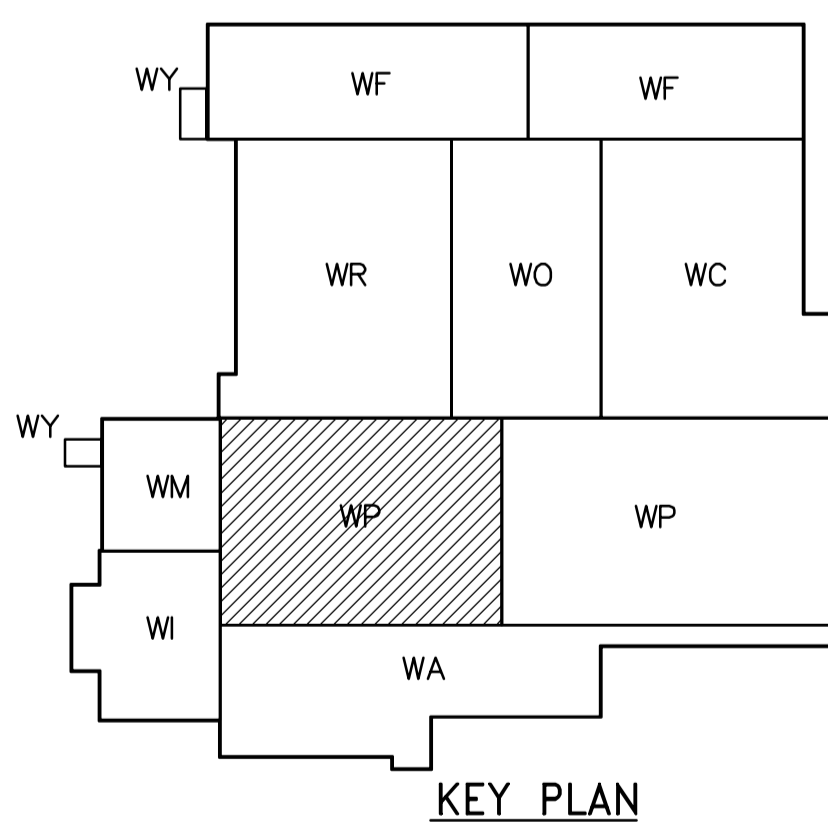

 Certificate of Authorization CH2M HILL Canada Ltd. No. 1441 Expiry: April 30, 2006	 Frederickson Cooper ARCHITECTS	 A Yoo International Ltd. Company	ENGINEER'S SEAL	 THE CITY OF WINNIPEG WATER AND WASTE DEPARTMENT ENGINEERING DIVISION		
			DESIGNED BY LL		CHECKED BY ND	ORIGINAL SIGNED BY L.D. LLEWELLYN
			DRAWN BY TL		APPROVED BY AHL	2006/03/29
			SCALE: 1:100		RELEASED FOR CONSTRUCTION BY: R. SOROKOWSKI	CONSULTANT DRAWING NO. WP-E0133
B.M. ELEV.	NO. REVISIONS	DATE	DATE	CITY FILE NUMBER SHEET OF CITY DRAWING NUMBER 1-0601P-A-E0133-001-000		