


- NOTES:**
- SEE MCC 4A & 4B SINGLE LINE DIAGRAMS AND PANEL SCHEDULES DP-H31 AND DP-H32 FOR 600V POWER DISTRIBUTION.
 - SEE DRAWINGS WB-E0402 AND WB-E0403 FOR FLOCCULATION TANK EQUIPMENT WIRING DETAILS.
 - SEE CABLE CLOCK DIAGRAMS CBD-P-31 THROUGH CBD-P-39 FOR DAF EQUIPMENT AND INSTRUMENT INTERCONNECTION WIRING REQUIREMENTS.



THIRD FLOOR PROCESS PLAN (AREA 2)
1:100

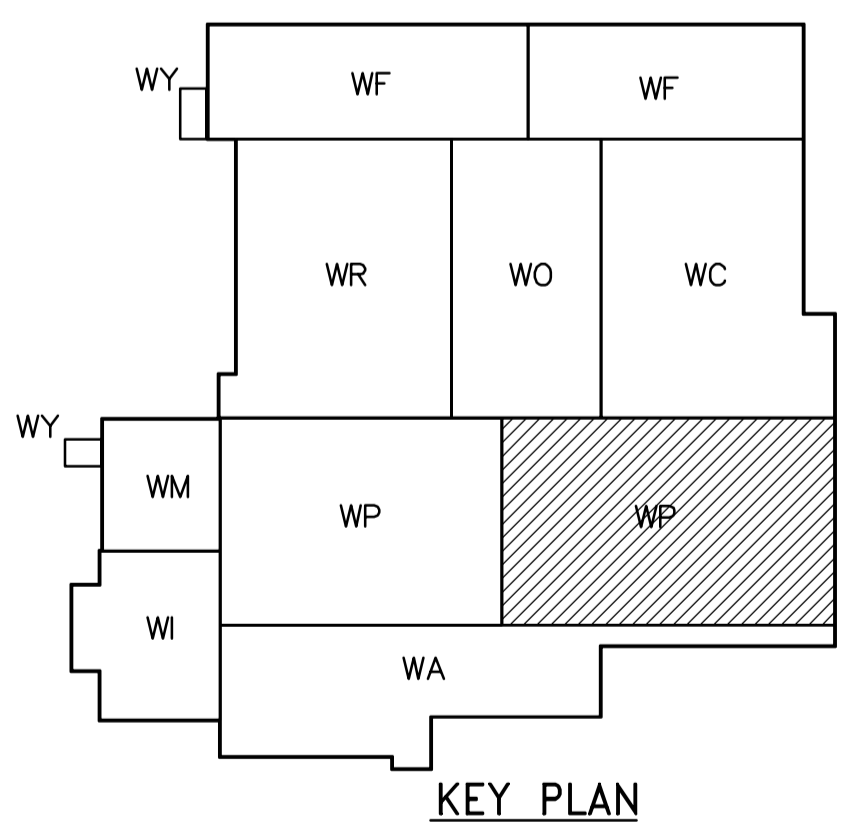

<p>APEGN Certificate of Authorization CH2M HILL Canada Ltd. No. 1441 Expiry: April 30, 2006</p>	<p>Frederickson Cooper ARCHITECTS</p>	<p>EarthTech A Tyco International Ltd. Company</p>	ENGINEER'S SEAL	<p>THE CITY OF WINNIPEG WATER AND WASTE DEPARTMENT ENGINEERING DIVISION</p>
			DESIGNED BY: LL CHECKED BY: ND DRAWN BY: TL APPROVED BY: AHL SCALE: 1:100 RELEASED FOR CONSTRUCTION BY: R. SOROKOWSKI DATE: 2005/07/12 DATE: 2006/03/29	