


FIRST FLOOR PLAN  
1:100

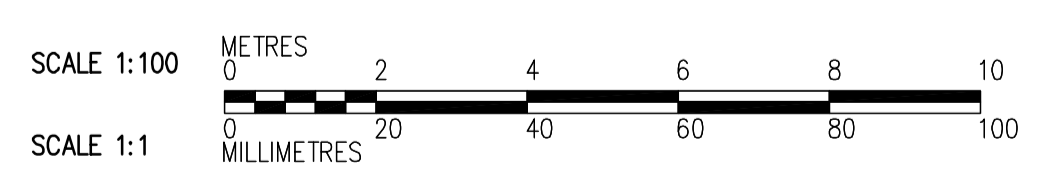

<p><b>APEGN</b> Certificate of Authorization CH2M HILL Canada Ltd. No. 1441 Expiry: April 30, 2006</p>	<p>Frederickson Cooper ARCHITECTS</p>	<p>EarthTech A Tyco International Ltd. Company</p>	ENGINEER'S SEAL  ORIGINAL SIGNED BY D.K. CUDDINGTON 2006/03/29	<p><b>THE CITY OF WINNIPEG</b> WATER AND WASTE DEPARTMENT ENGINEERING DIVISION</p>
			DESIGNED BY TT CHECKED BY DL DRAWN BY AM APPROVED BY AHL SCALE: 1:100 RELEASED FOR CONSTRUCTION BY: R. SOROKOWSKI	
B.M. ELEV.			WATER TREATMENT PLANT FLOCCULATION AND DAF MECHANICAL AND ELECTRICAL	
00 ISSUED FOR TENDER 06/03/29 TT NO. REVISIONS DATE BY DATE 2005/07/04 DATE 2006/03/29			CITY FILE NUMBER SHEET OF CITY DRAWING NUMBER 1-0601P-A-H0112-001-000	
HVAC FLOC/DAF AREA 2 FIRST FLOOR PLAN			1-0601P-A-H0112-001-000	