


THIRD FLOOR PLAN
1:100

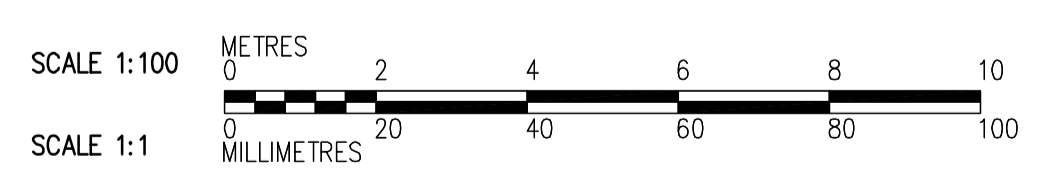

<p>APEGN Certificate of Authorization CH2M HILL Canada Ltd. No. 1441 Expiry: April 30, 2006</p>	<p>Frederickson Cooper ARCHITECTS</p>	<p>EarthTech A Yeo International Ltd. Company</p>	B.M. ELEV.	ENGINEER'S SEAL ORIGINAL SIGNED BY D.K. CUDDINGTON 2006/03/29	<p>THE CITY OF WINNIPEG WATER AND WASTE DEPARTMENT ENGINEERING DIVISION</p>	
			DESIGNED BY TT CHECKED BY DL DRAWN BY AM APPROVED BY AHL	WATER TREATMENT PLANT FLOCCULATION AND DAF MECHANICAL AND ELECTRICAL		CITY FILE NUMBER SHEET OF
			SCALE: 1:100 RELEASED FOR CONSTRUCTION BY: R. SOROKOWSKI DATE 2005/07/04	HVAC FLOC/DAF AREA 2 THIRD FLOOR PLAN		CITY DRAWING NUMBER 1-0601P-A-H0132-001-000