


THIRD FLOOR PLAN  
1:100

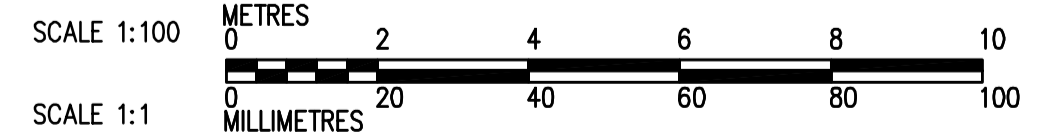

<p><b>APEGN</b> Certificate of Authorization CH2M HILL Canada Ltd. No. 1441 Expiry: April 30, 2006</p>	<p>Frederickson Cooper ARCHITECTS</p>	<p>EarthTech A Tyco International Ltd. Company</p>	ENGINEER'S SEAL	<p><b>THE CITY OF WINNIPEG</b> WATER AND WASTE DEPARTMENT ENGINEERING DIVISION</p>
			<p>DESIGNED BY: JZ/SW DRAWN BY: JmCP SCALE: 1:100</p>	
<p>00 ISSUED FOR TENDER 06/03/29 SW</p>			<p>CONSULTANT DRAWING NO. WP-H0133</p>	<p>CITY FILE NUMBER</p>
<p>NO. REVISIONS DATE BY DATE 2005/07/15 DATE 2006/03/29</p>			<p>PLUMBING FLOC/DAF AREA 1 THIRD FLOOR PLAN</p>	<p>SHEET OF</p> <p>CITY DRAWING NUMBER 1-0601P-A-H0133-001-000</p>