


ROOF PLAN
1:100

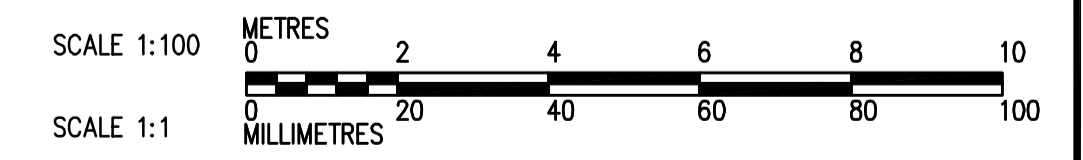

| | | | | | | |
|--|----------------------|---|--|---|--|------------------|
| Certificate of Authorization CH2M HILL Canada Ltd. No. 1441 Expiry: April 30, 2006 | B.M. ELEV. | Frederickson Cooper ARCHITECTS | A Terra International Ltd. Company | ENGINEER'S SEAL ORIGINAL SIGNED BY D.K. CUDDINGTON 2006/03/29 | THE CITY OF WINNIPEG WATER AND WASTE DEPARTMENT ENGINEERING DIVISION WATER TREATMENT PLANT FLOCCULATION AND DAF MECHANICAL AND ELECTRICAL PLUMBING FLOC/DAF AREA 1 ROOF PLAN | CITY FILE NUMBER |
| | DESIGNED BY JZ/SW | CHECKED BY DL | D.K. CUDDINGTON | SHEET OF | | |
| | DRAWN BY JMcP | APPROVED BY AHL | 2006/03/29 | CITY DRAWING NUMBER | | |
| | SCALE: 1:100 | RELEASED FOR CONSTRUCTION BY: R. SOROKOWSKI | CONSULTANT DRAWING NO. WP-H0143 | 1-0601P-A-H0143-001-000 | | |
| 00 ISSUED FOR TENDER NO. REVISIONS | 06/03/29 DATE BY | DATE 2005/07/15 | DATE 2006/03/29 | DATE | DATE | DATE |