



NOT IN CONTRACT - FOR INFORMATION ONLY

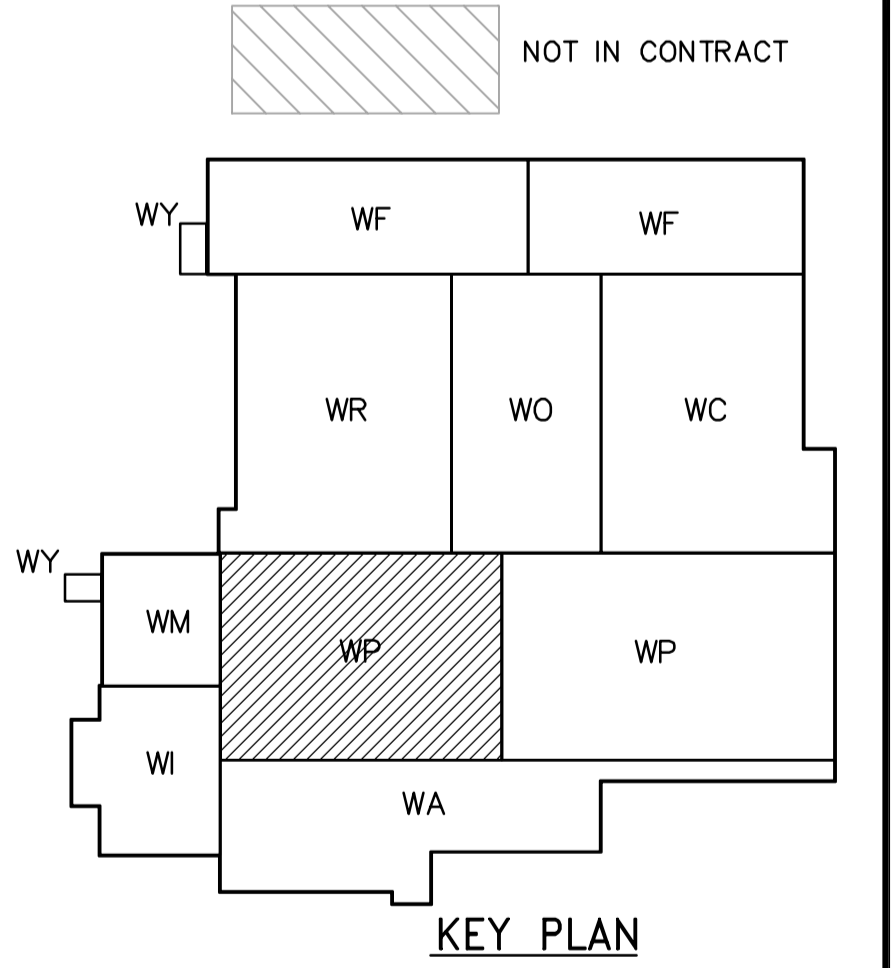

FIRST FLOOR PLAN
1:100

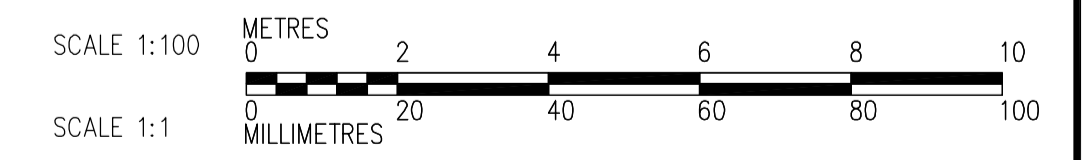

 APEGN Certificate of Authorization CH2M HILL Canada Ltd. No. 1441 Expiry: April 30, 2006	B.M. ELEV.	 Frederickson Cooper ARCHITECTS	 A Terra International Ltd. Company	ENGINEER'S SEAL	 THE CITY OF WINNIPEG WATER AND WASTE DEPARTMENT ENGINEERING DIVISION	
	DESIGNED BY: JZ/SW			CHECKED BY: DL		ORIGINAL SIGNED BY: D.K. CUDDINGTON
	DRAWN BY: JMcP			APPROVED BY: DJT		DATE: 2006/02/06
	SCALE: 1:100			RELEASED FOR CONSTRUCTION BY: R. SOROKOWSKI		CONSULTANT DRAWING NO. WP-H9113
00 ISSUED FOR TENDER	2006/02/03 SW	DATE: 2005/07/15	DATE: 2006/02/08	PLUMBING PIPE EMBEDS FLOC/DAF AREA 1 FIRST FLOOR PLAN	CITY FILE NUMBER SHEET OF CITY DRAWING NUMBER 1-060P-A-H913-001-00D	