



NOT IN CONTRACT - FOR INFORMATION ONLY

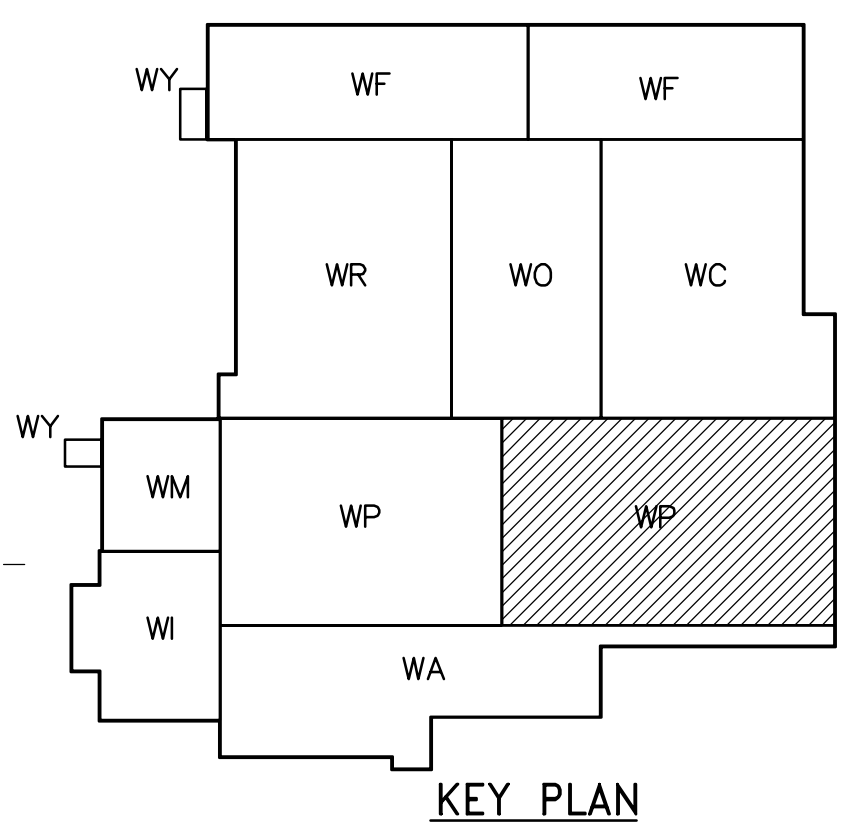

THIRD FLOOR PLAN
1:100

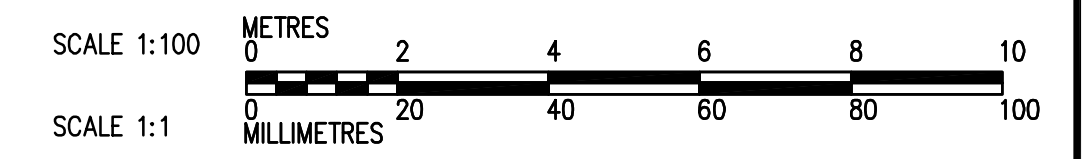

 APEGN Certificate of Authorization CH2M HILL Canada Ltd. No. 1441 Expiry: April 30, 2006	B.M. ELEV.	 Frederickson Cooper ARCHITECTS	 A Terra International Ltd. Company	ENGINEER'S SEAL ORIGINAL SIGNED BY D.K. CUDDINGTON 2006/02/06	 THE CITY OF WINNIPEG WATER AND WASTE DEPARTMENT ENGINEERING DIVISION WATER TREATMENT PLANT FLOCCULATION AND DAF FOUNDATIONS AND CONCRETE STRUCTURES PLUMBING PIPE EMBEDS FLOC/DAF AREA 2 THIRD FLOOR PLAN	CITY FILE NUMBER SHEET OF CITY DRAWING NUMBER 1-060P-A-H9134-001-00D
	DESIGNED BY JZ/SW DRAWN BY JMcP SCALE: 1:100 00 ISSUED FOR TENDER 2006/02/03 SW NO. REVISIONS DATE BY DATE 2005/07/15			CHECKED BY DL APPROVED BY DJT RELEASED FOR CONSTRUCTION BY: R. SOROKOWSKI DATE 2006/02/08		CONSULTANT DRAWING NO. WP-H9134