







M SECTION - OZONE COOLING WATER RETURN
WP-M9105 1:50

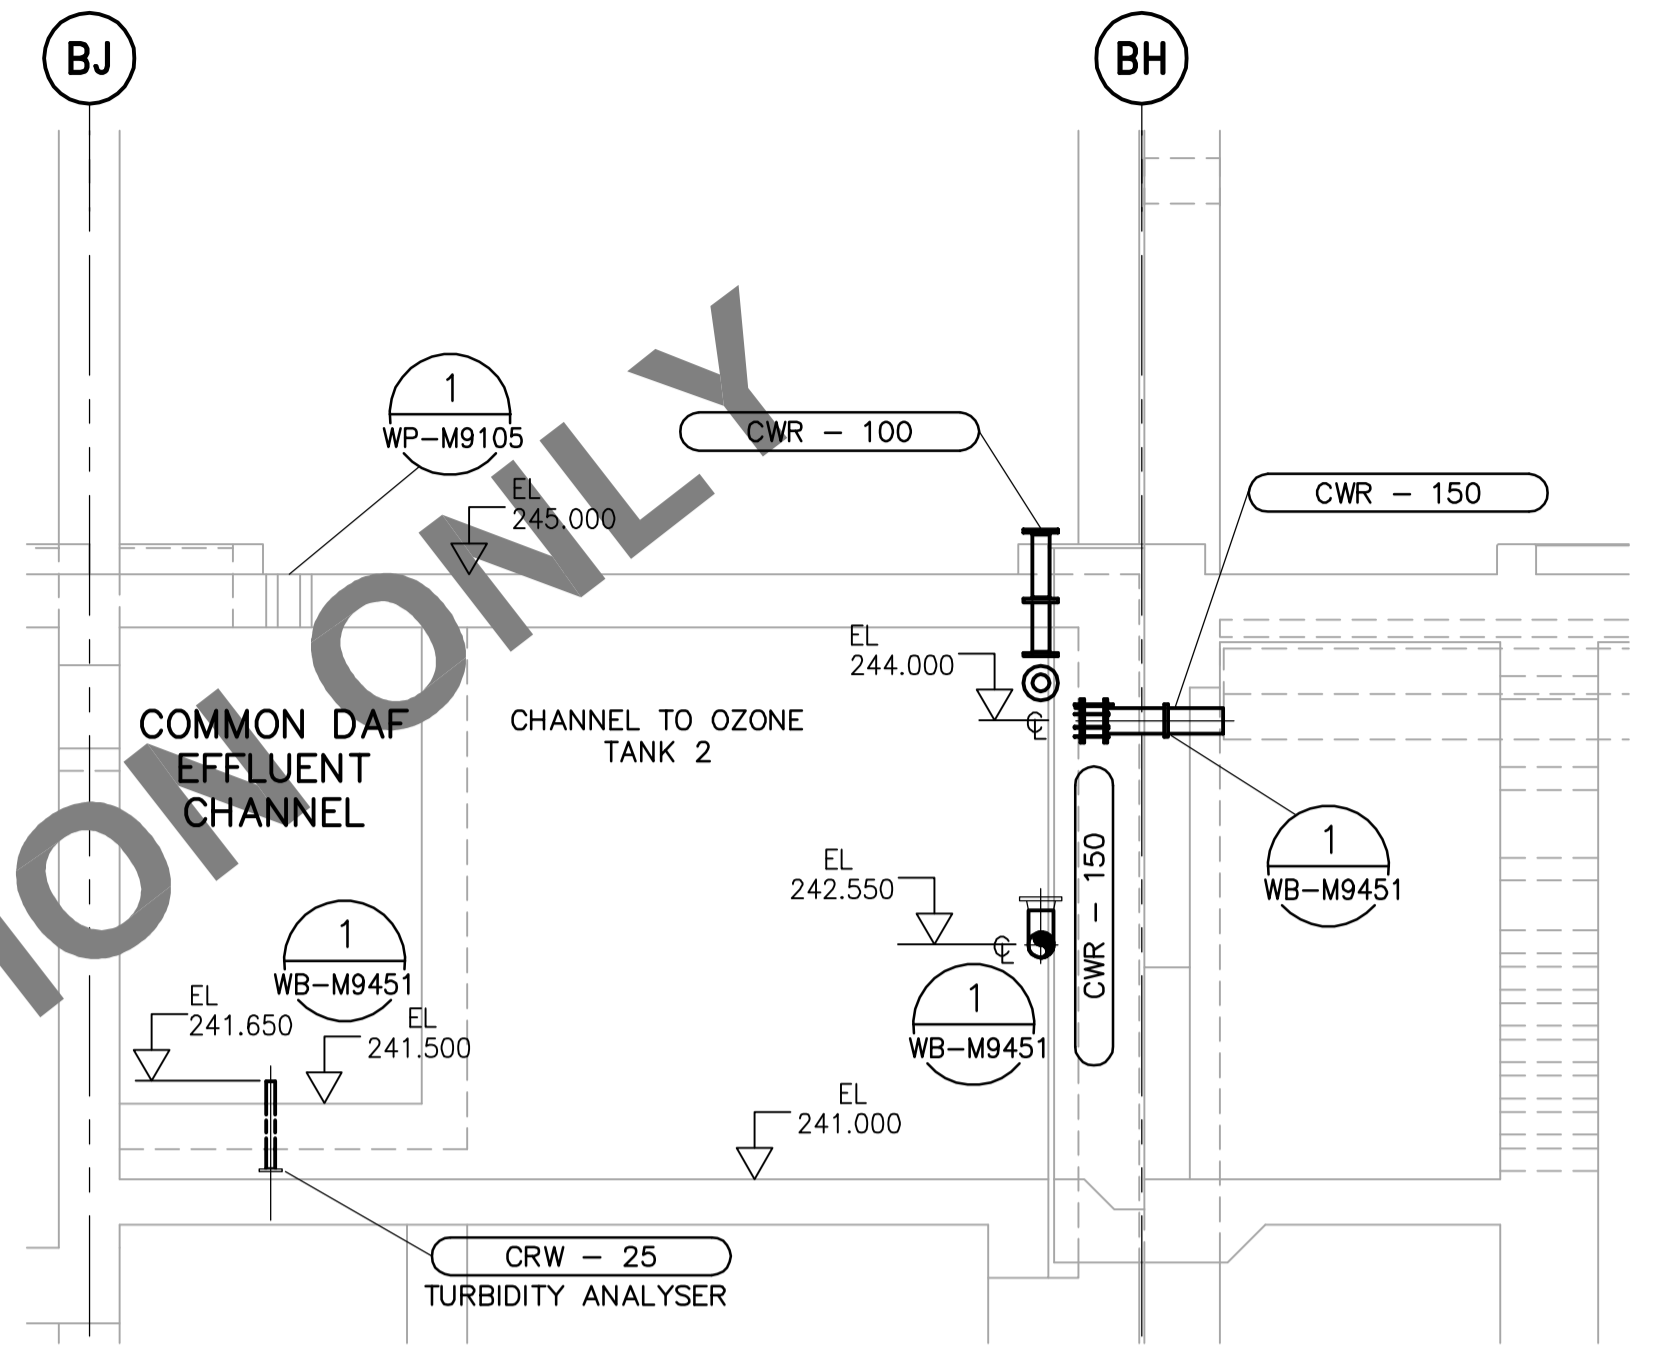

N SECTION - OZONE COOLING WATER RETURN
WP-M9105 1:50

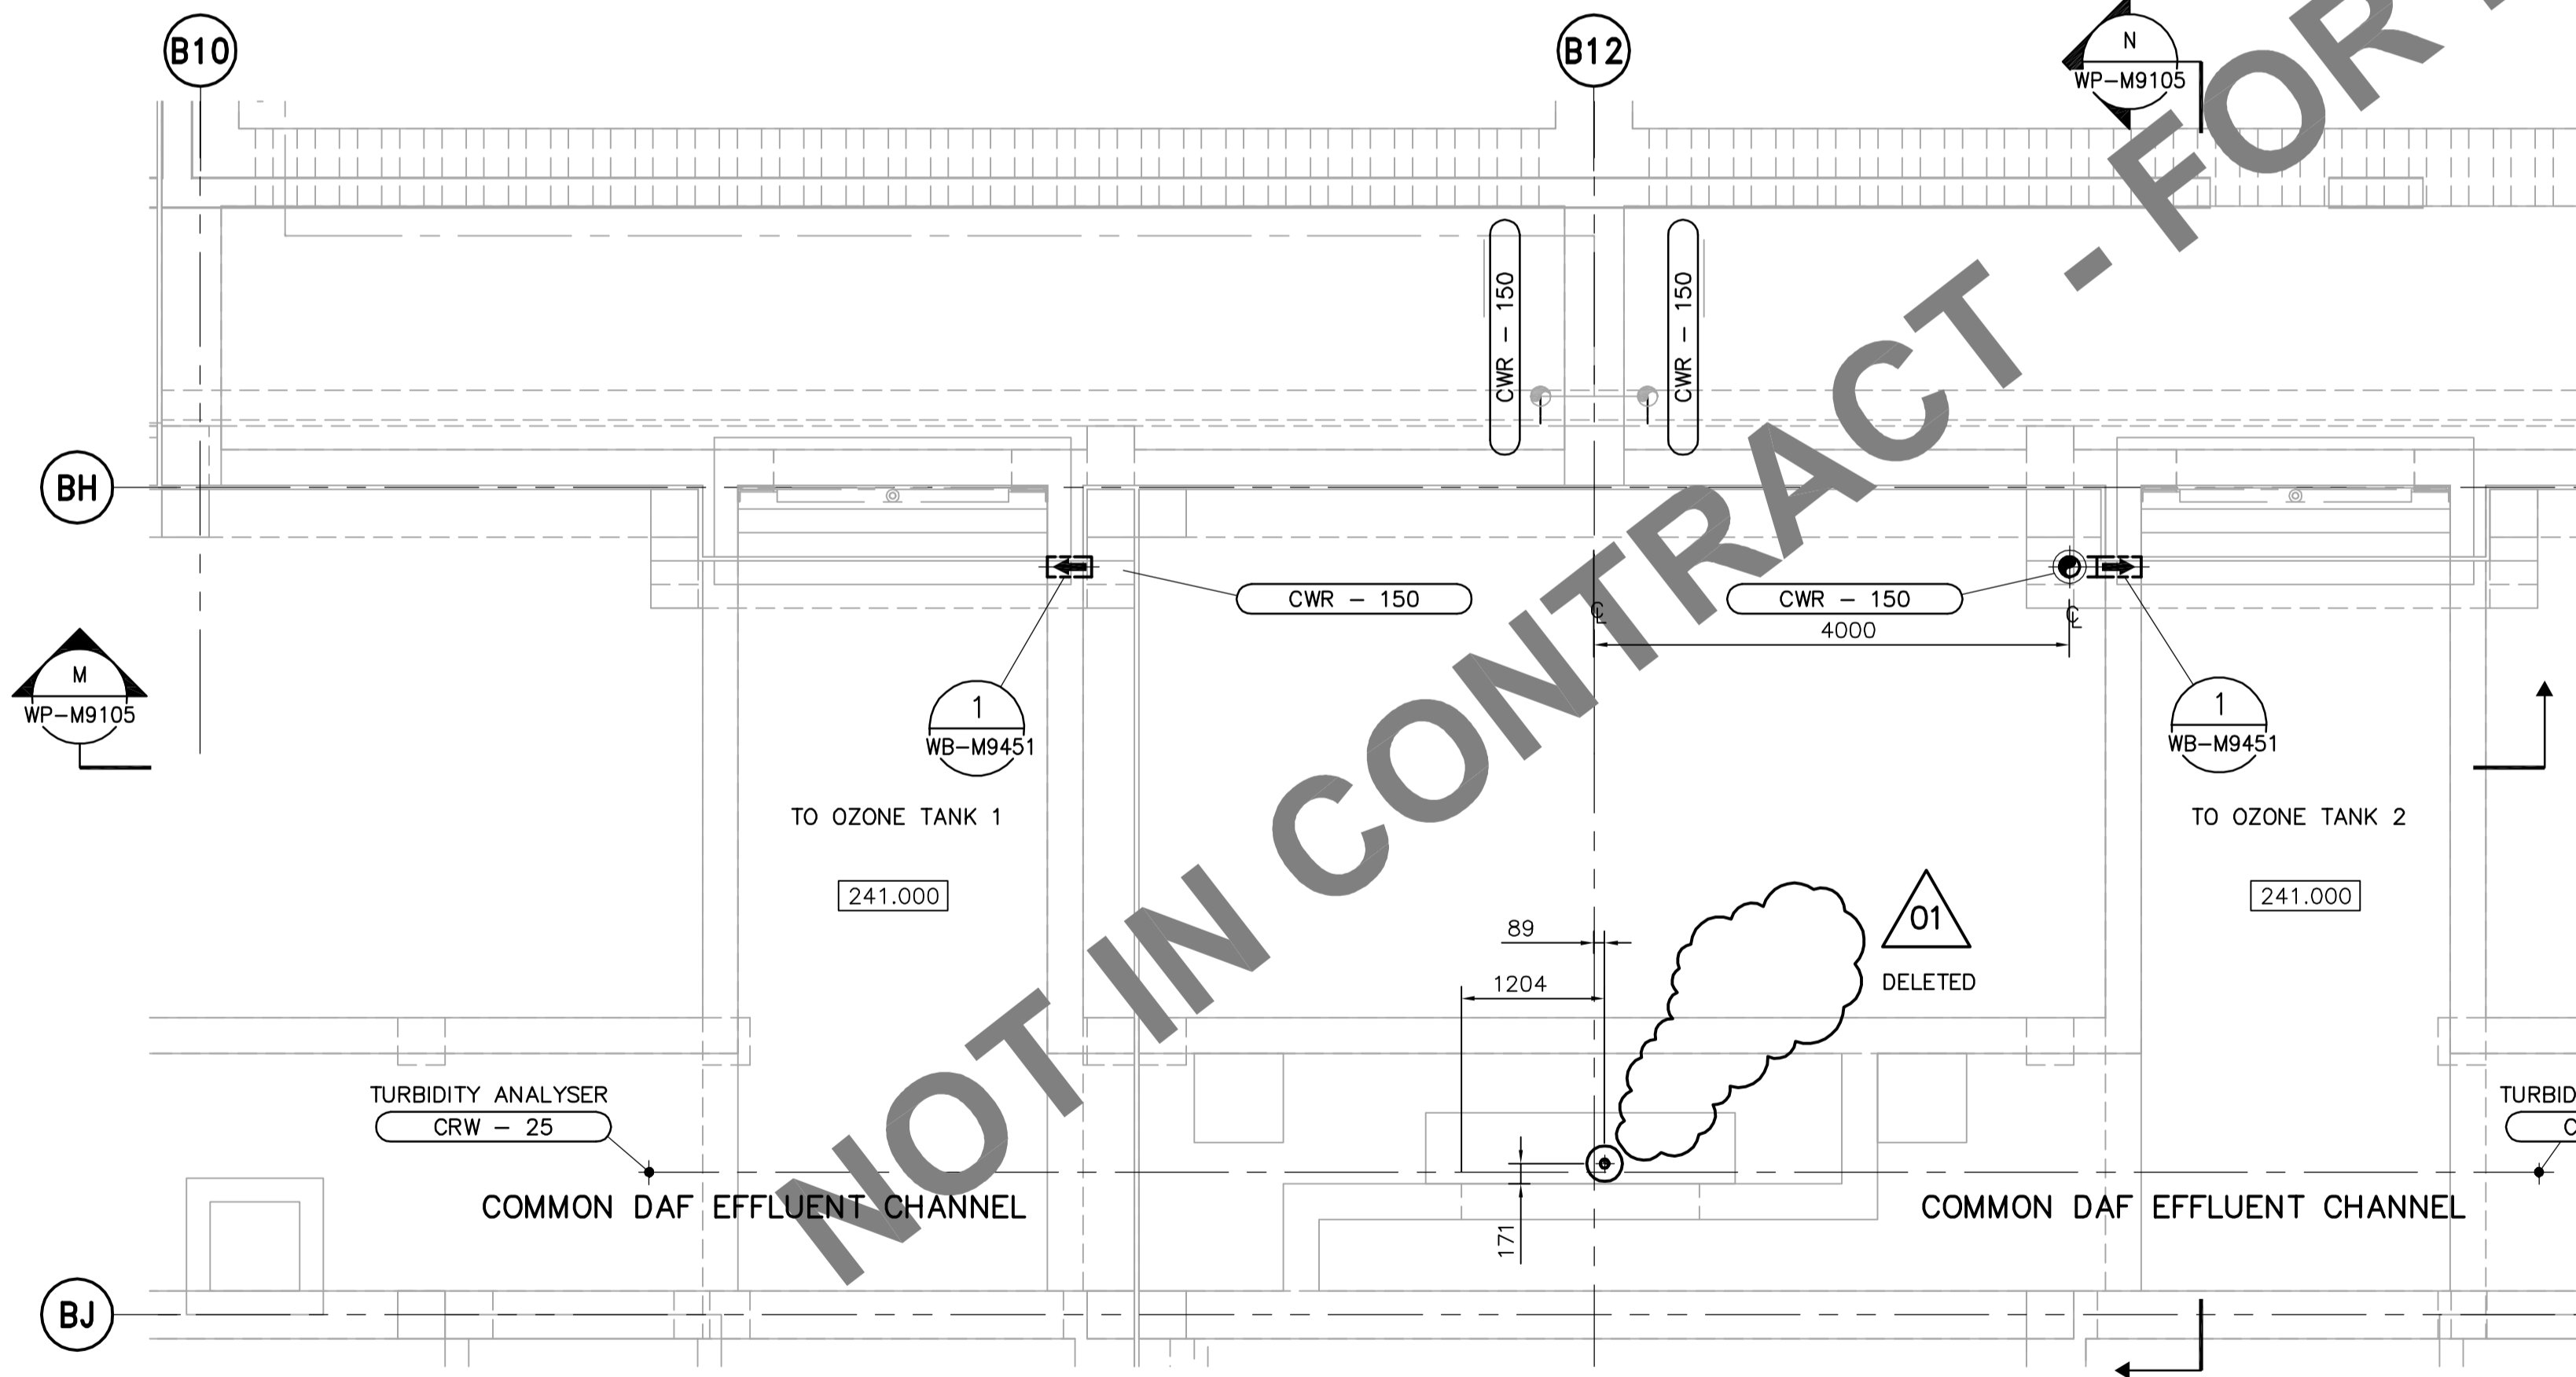

21 THIRD FLOOR PLAN - OZONE COOLING WATER RETURN
WP-M9105 1:50

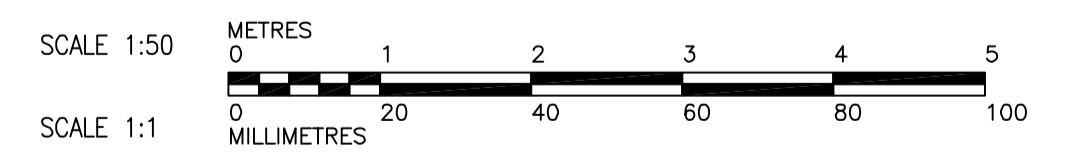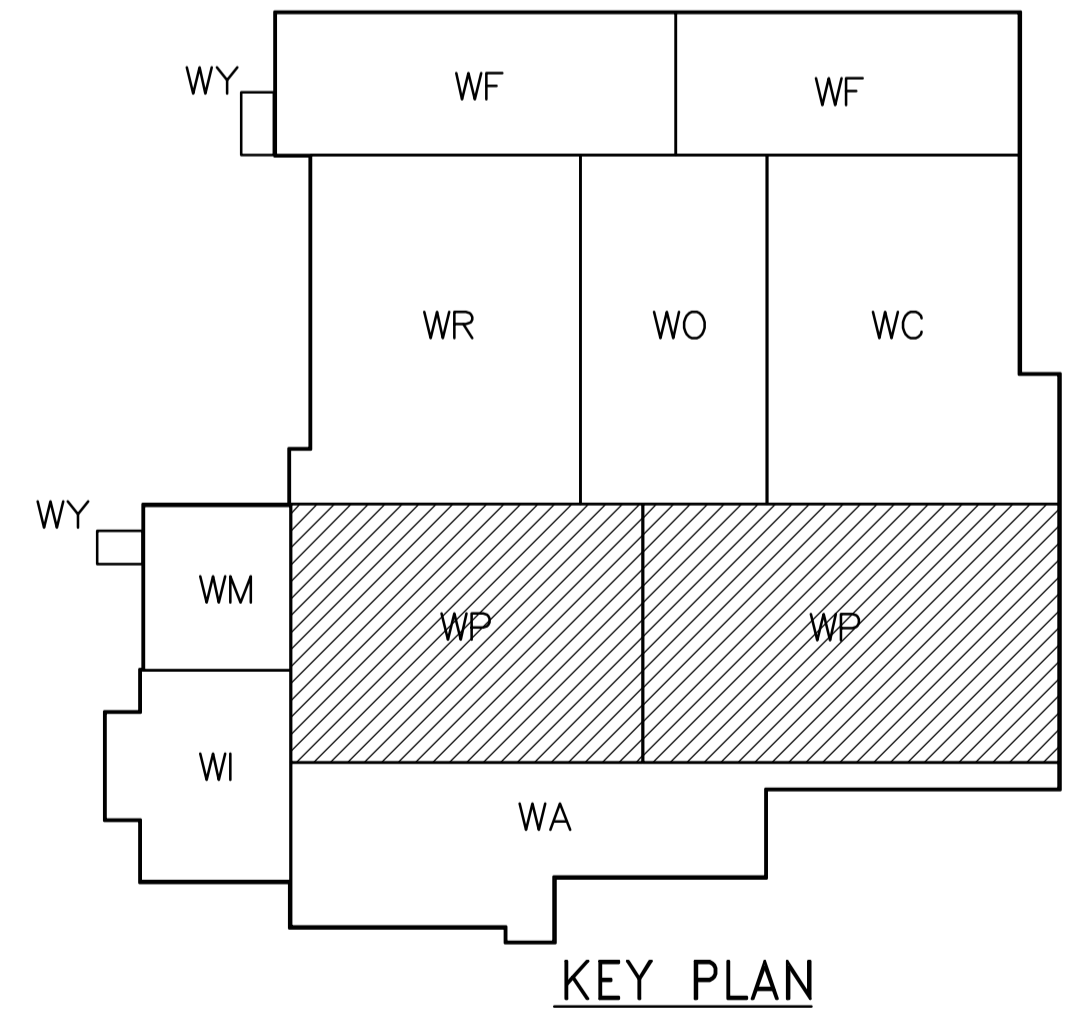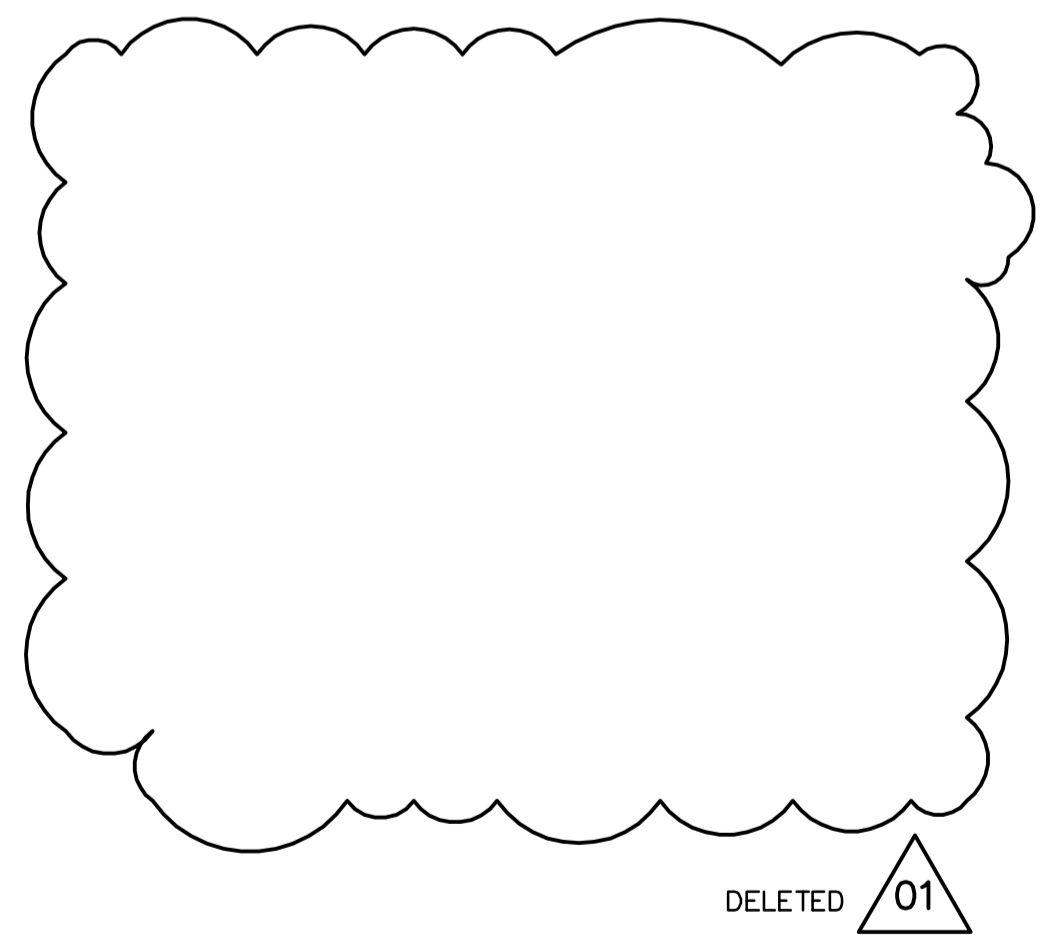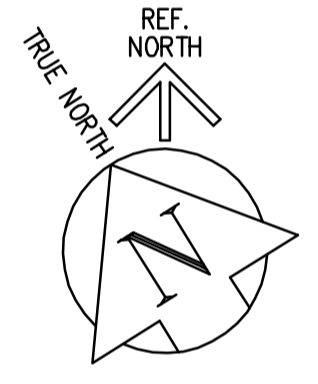

<p>Certificate of Authorization Earth Tech Canada Inc. No. 730 Expiry: April 30, 2006</p>	<p>B.M. ELEV.</p> <table border="1"> <tr><td> </td><td> </td><td> </td><td> </td></tr> <tr><td> </td><td> </td><td> </td><td> </td></tr> <tr><td> </td><td> </td><td> </td><td> </td></tr> <tr><td> </td><td> </td><td> </td><td> </td></tr> </table>																	<p>Frederickson Cooper ARCHITECTS</p>	<p>A Tech International Ltd. Company</p>	ENGINEER'S SEAL	<p>THE CITY OF WINNIPEG WATER AND WASTE DEPARTMENT ENGINEERING DIVISION</p>
<p>DESIGNED BY: KAS</p> <p>DRAWN BY: PL</p> <p>SCALE: AS SHOWN</p> <p>DATE: 2005/10/24</p>	<p>CHECKED BY: SRB</p> <p>APPROVED BY: DJT</p> <p>RELEASED FOR CONSTRUCTION BY: R. SOROKOWSKI</p> <p>DATE: 2006/02/07</p>	<p>ORIGINAL SIGNED BY: S.R. BILEVICIUS</p> <p>DATE: 2006/02/07</p> <p>CONSULTANT DRAWING NO.: WP-M9105</p>	<p>WATER TREATMENT PLANT FLOCCULATION AND DAF FOUNDATIONS AND CONCRETE STRUCTURES</p> <p>PIPE EMBEDS THIRD FLOOR PLAN AND SECTIONS OZONE COOLING WATER RETURN</p>	<p>CITY FILE NUMBER</p> <p>SHEET OF</p> <p>CITY DRAWING NUMBER 1-0601P-A-M9105-001-01D</p>																	