



T SECTION - DAF INFLUENT GALLERY SUMP PUMPS
WP-M9107 1:50


U SECTION - DAF INFLUENT GALLERY SUMP PUMPS
WP-M9107 1:50

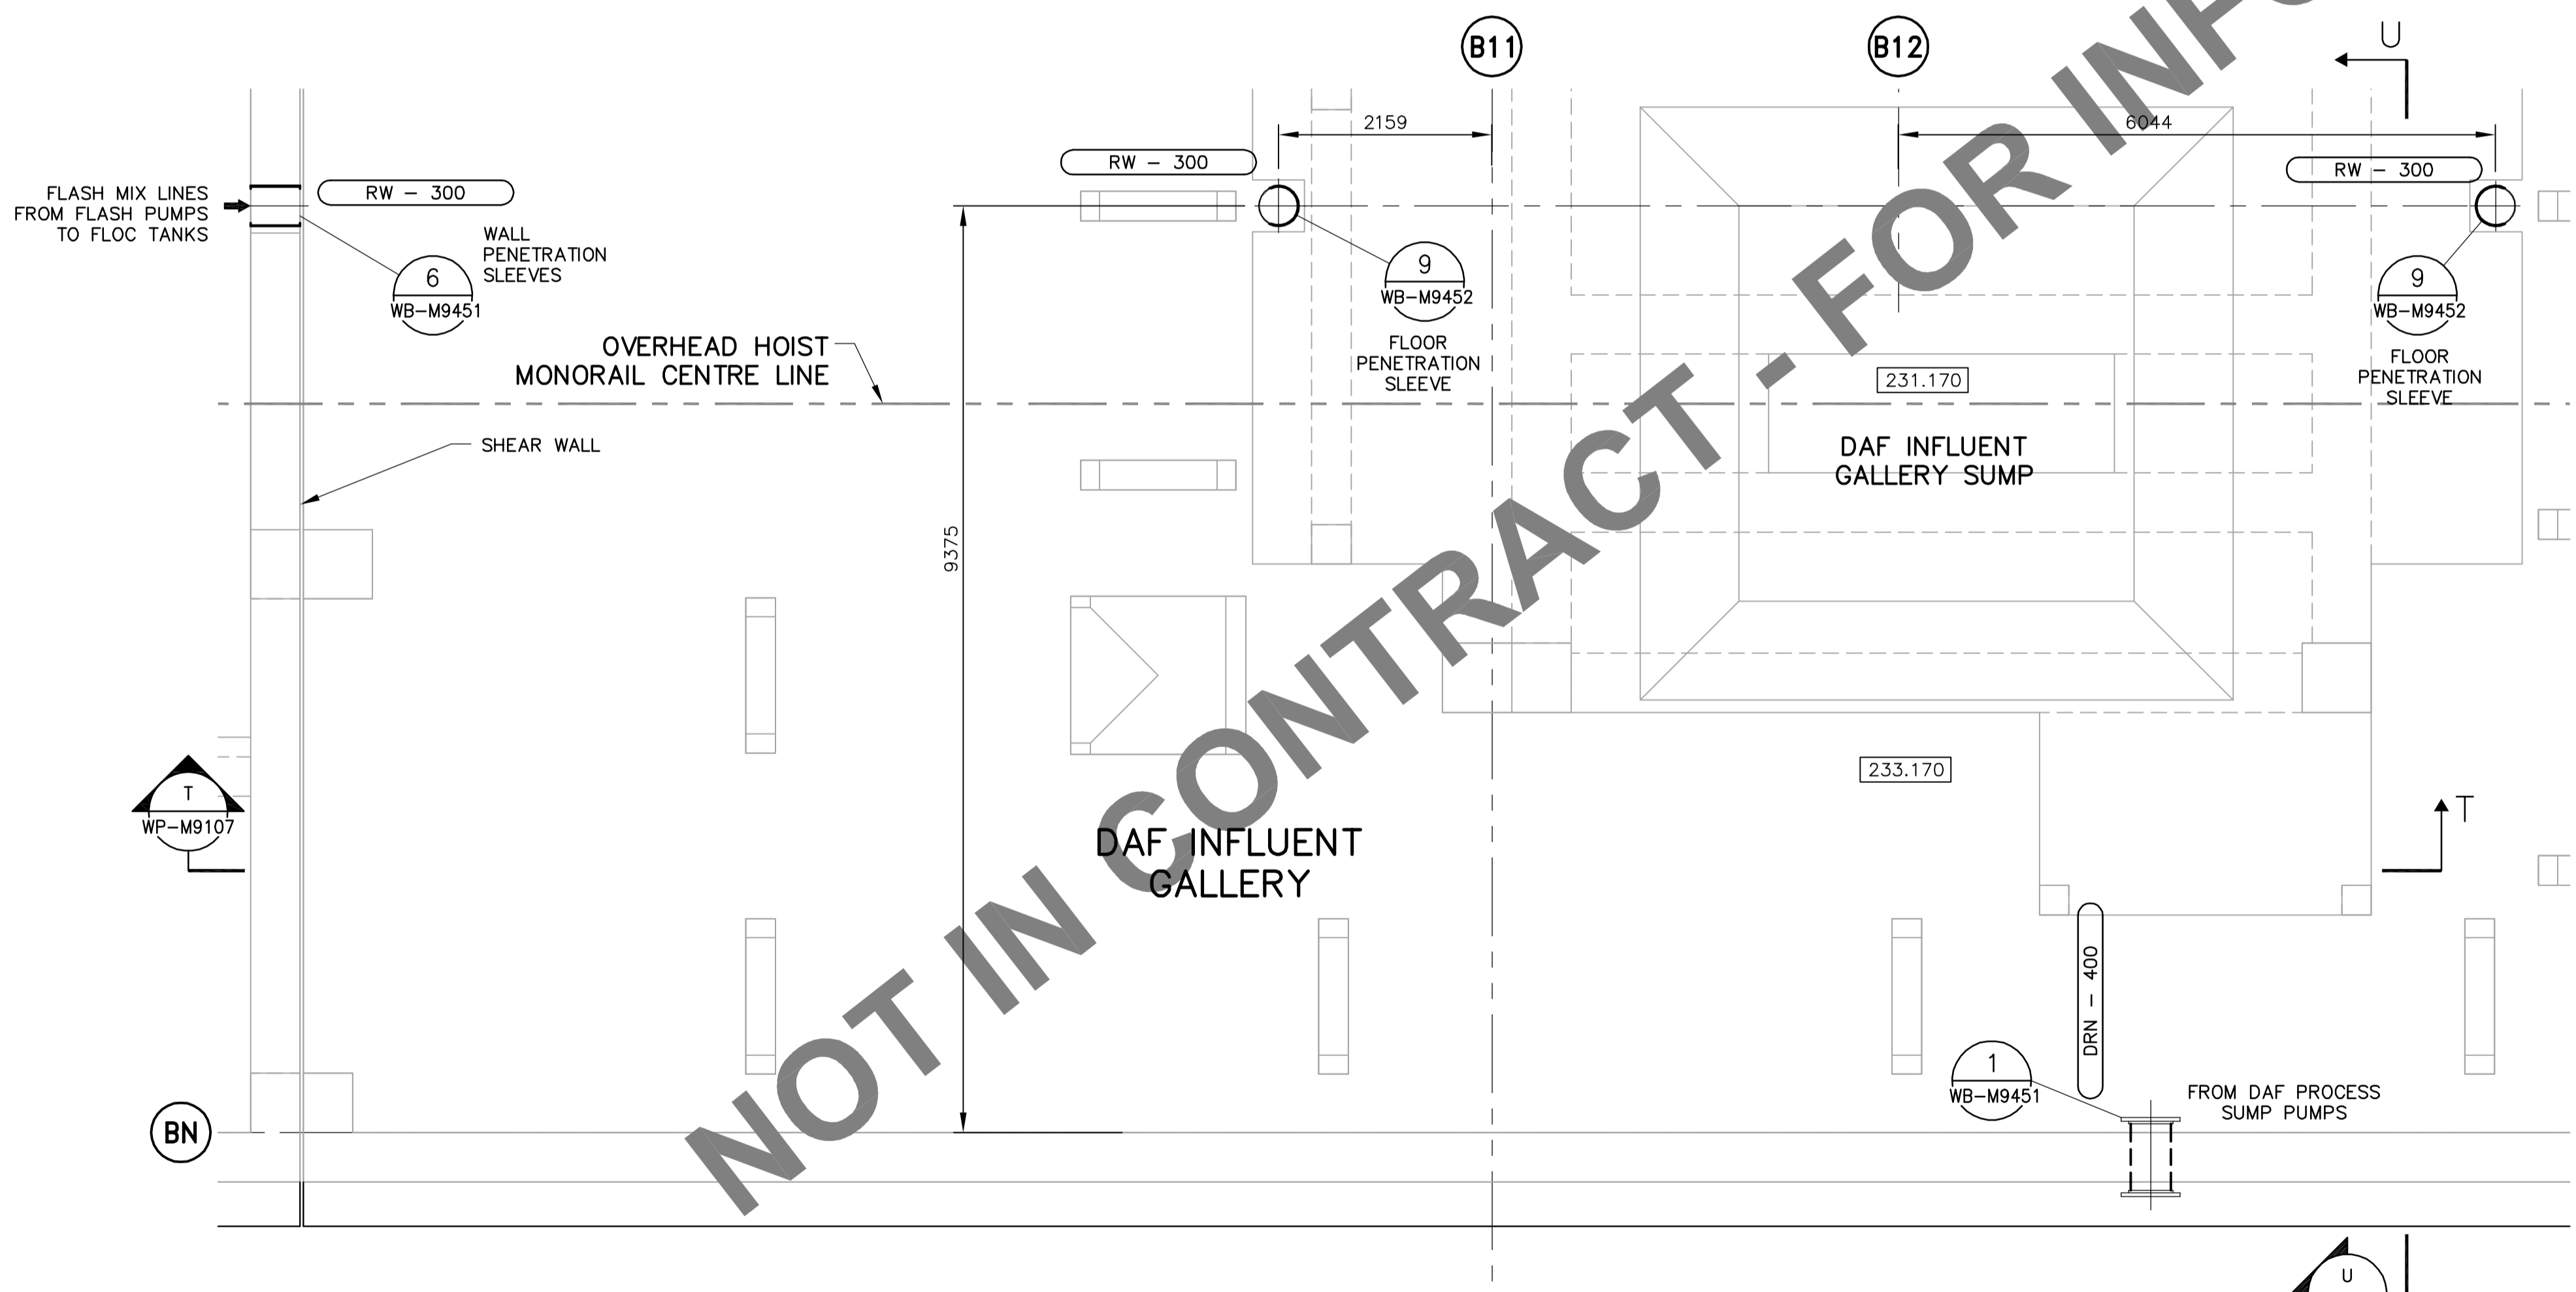

23 FIRST FLOOR PLAN - DAF INFLUENT GALLERY SUMP PUMPS
WP-M9107 1:50

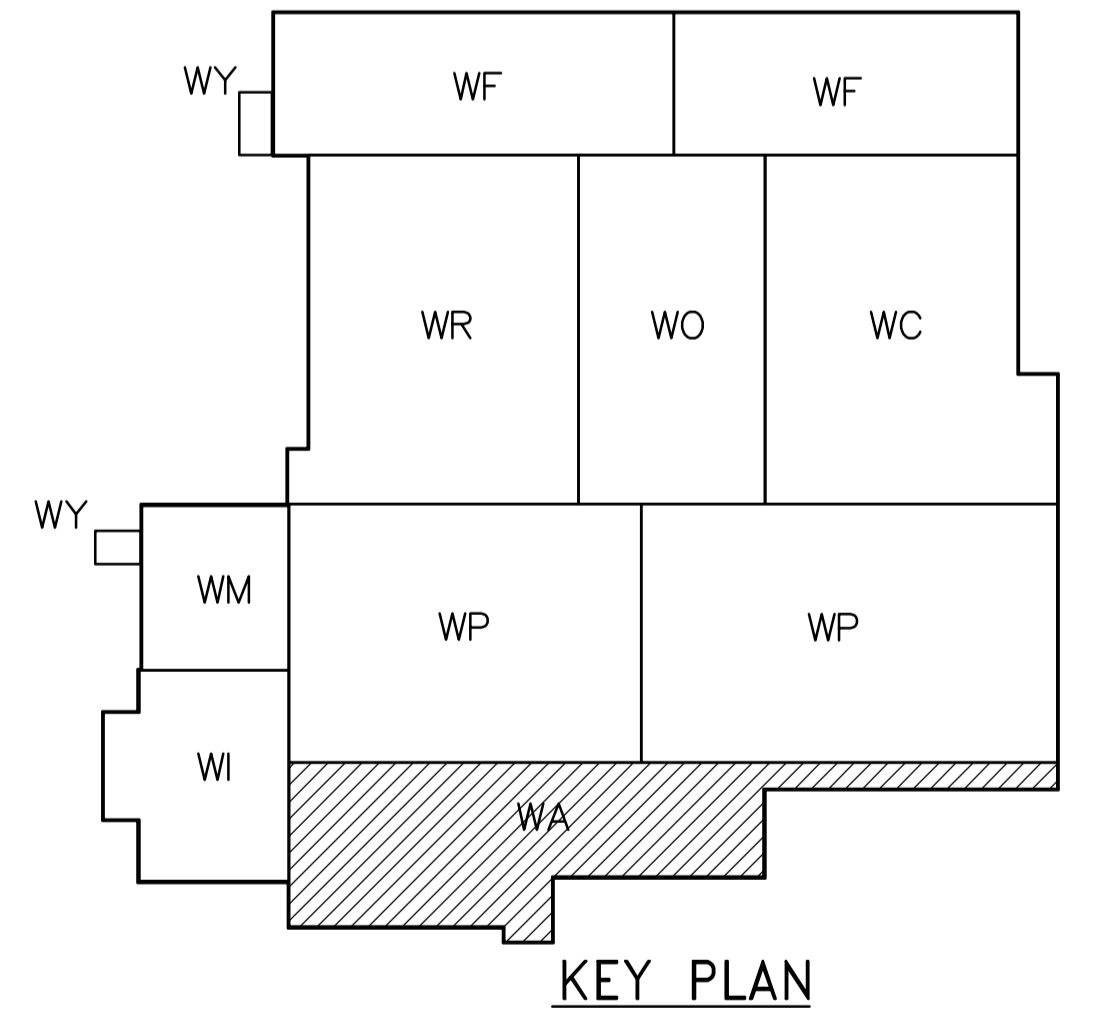

KEY PLAN

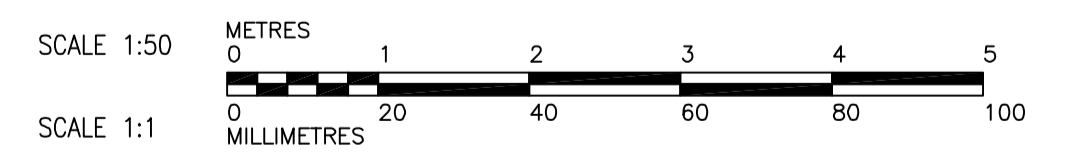

<p>APECA Certificate of Authorization Earth Tech Canada Inc. No. 730 Expiry: April 30, 2006</p>		<p>CH2M HILL Frederickson Cooper ARCHITECTS</p>		<p>EarthTech A Tyco International Ltd. Company</p>		<p>ENGINEER'S SEAL</p> <p>ORIGINAL SIGNED BY S.R. BILEVICIUS 2006/02/07</p> <p>CONSULTANT DRAWING NO. WP-M9107</p>	
<p>DESIGNED BY KAS</p> <p>DRAWN BY PL/LC</p> <p>SCALE: AS SHOWN</p>		<p>CHECKED BY SRB</p> <p>APPROVED BY DJT</p> <p>RELEASED FOR CONSTRUCTION BY: R. SOROKOWSKI</p>		<p>DATE 2005/11/28</p> <p>DATE 2006/02/07</p>		<p>WATER TREATMENT PLANT FLOCCULATION AND DAF FOUNDATIONS AND CONCRETE STRUCTURES</p> <p>PIPE EMBEDS FIRST FLOOR PLAN AND SECTIONS RAW WATER SUMP DISCHARGE PIPING</p>	
<p>00 ISSUED FOR TENDER 06/02/03 PL</p>		<p>NO. REVISIONS</p>		<p>DATE BY</p>		<p>CITY FILE NUMBER</p> <p>SHEET OF</p> <p>CITY DRAWING NUMBER 1-0601P-A-M9107-001-000</p>	