




V SECTION - OZONE CONTACTOR DRAIN LINE
WP-M9108 1:50

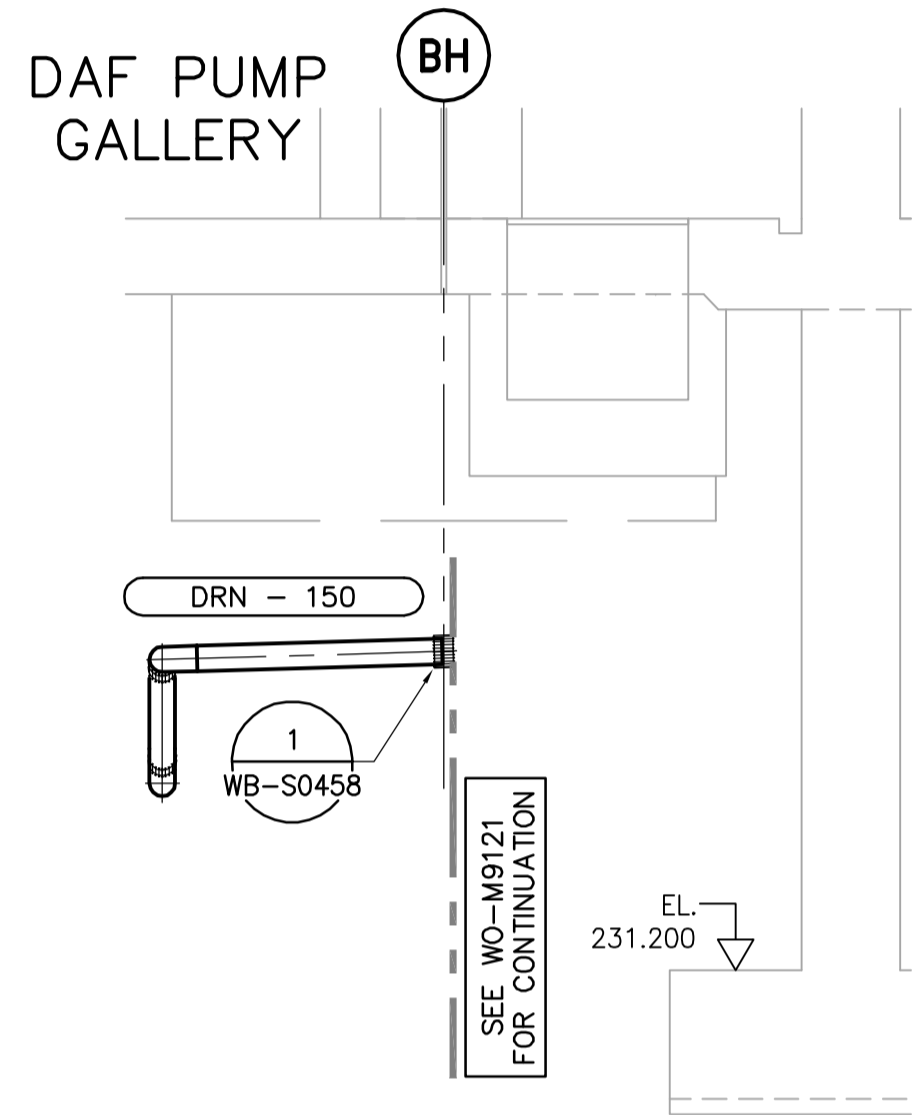


W SECTION - OZONE CONTACTOR DRAIN LINE
WP-M9108 1:50

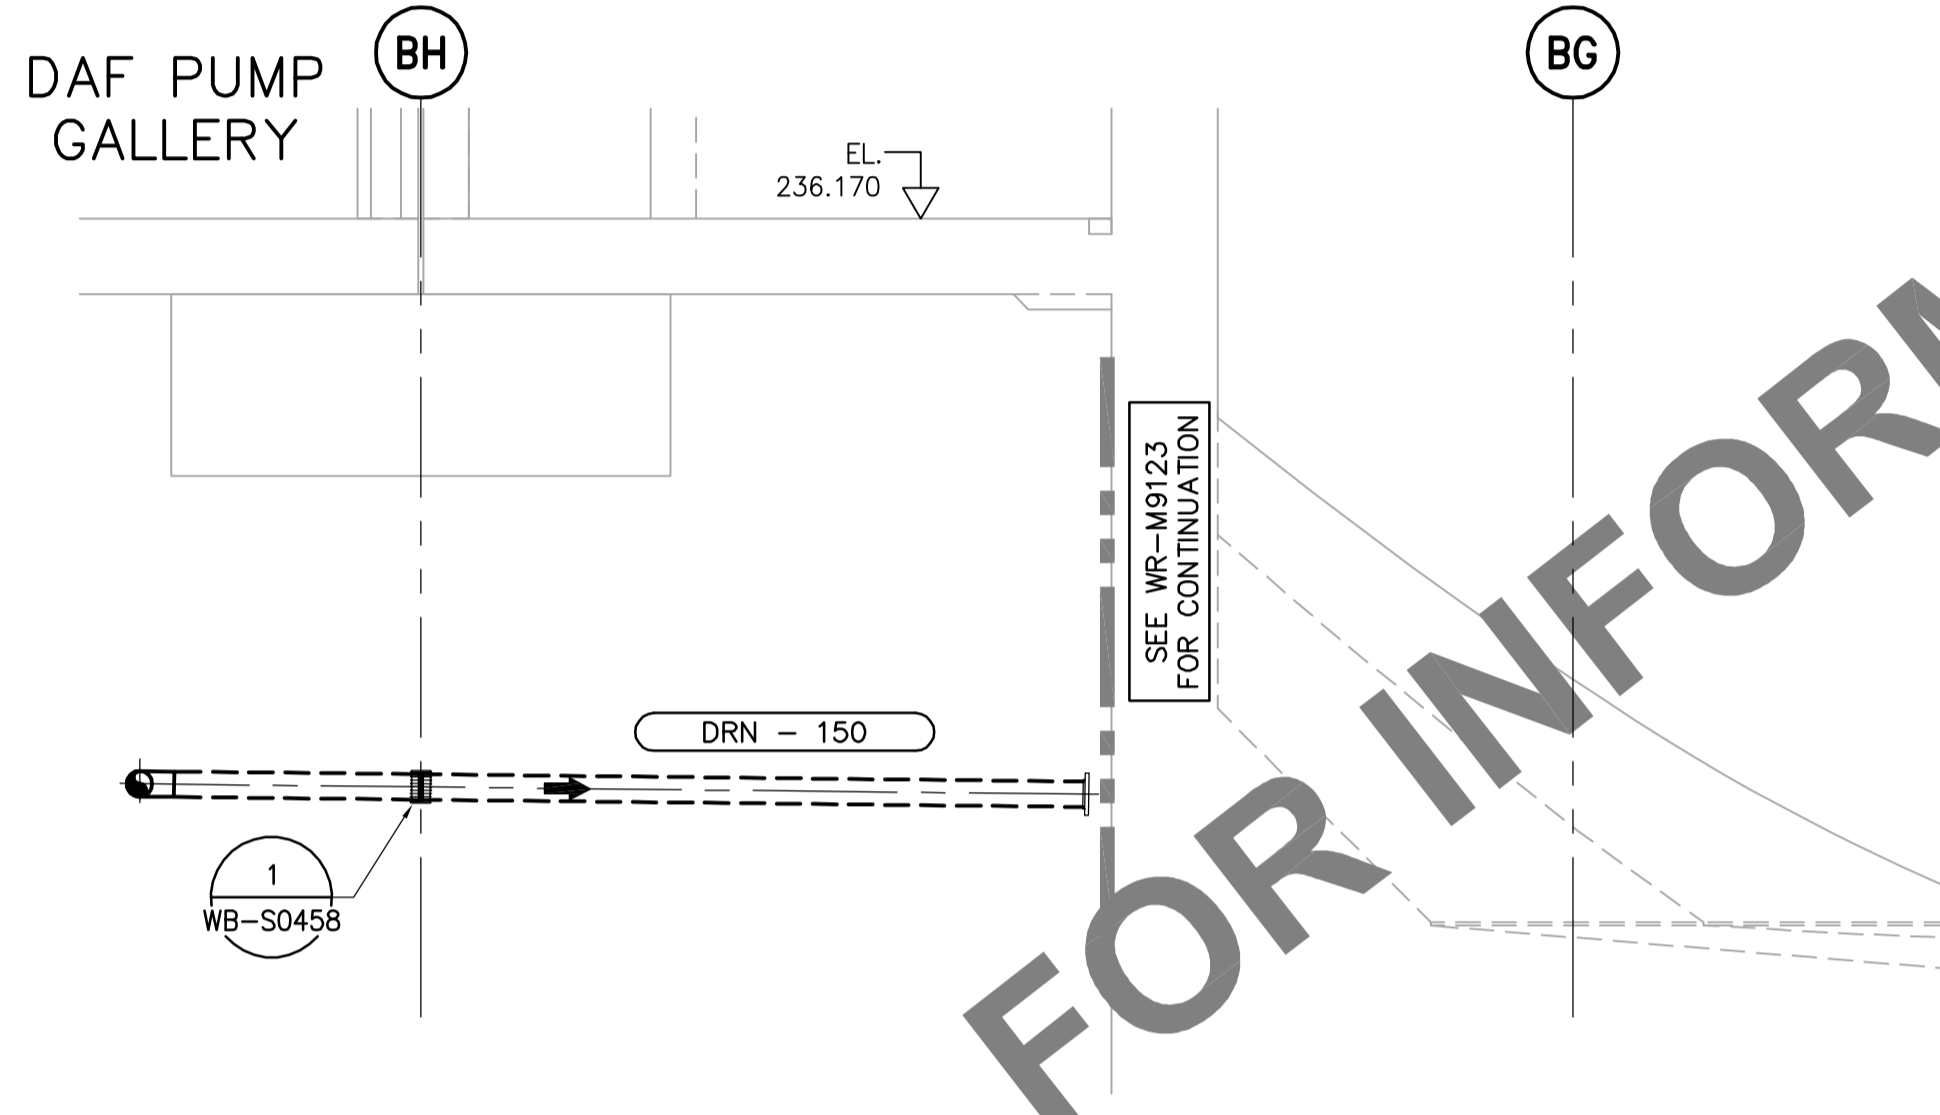

X SECTION - OZONE CONTACTOR DRAIN LINE
WP-M9108 1:50

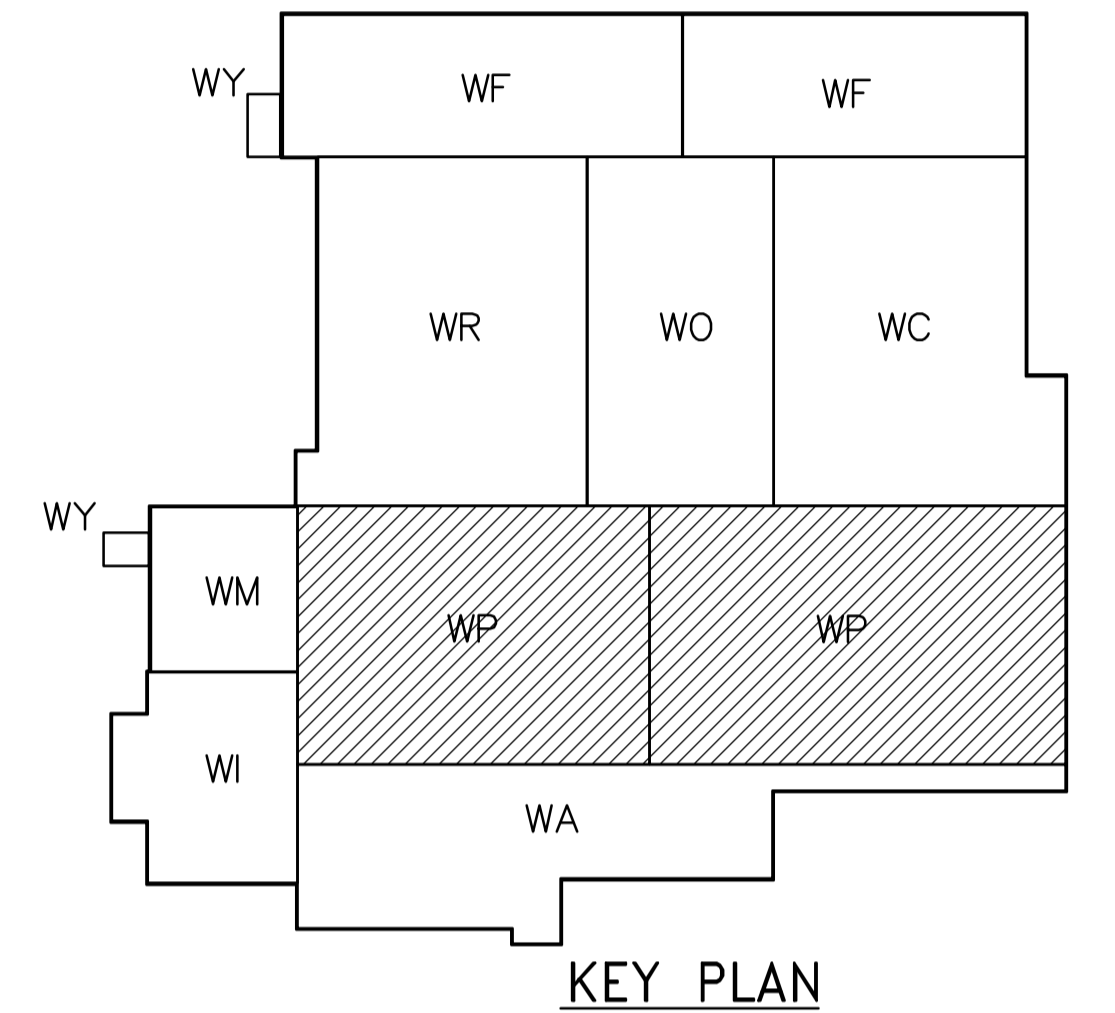

SCALE 1:50 METRES
SCALE 1:1 MILLIMETRES

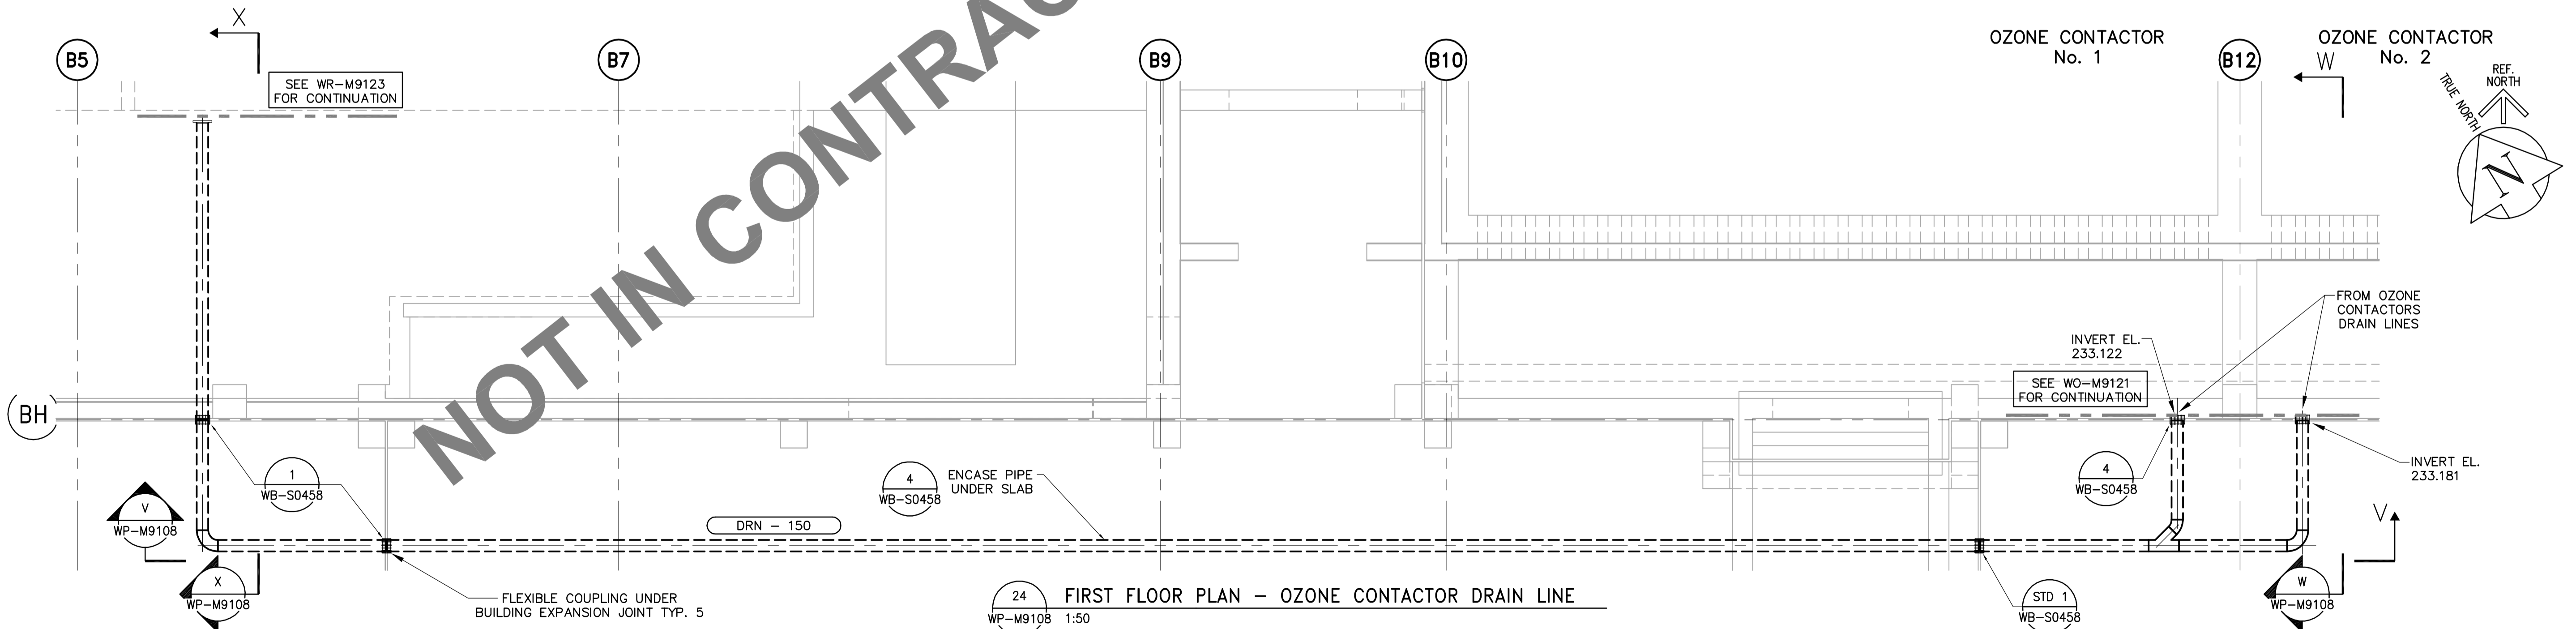

24 FIRST FLOOR PLAN - OZONE CONTACTOR DRAIN LINE
WP-M9108 1:50

 Certificate of Authorization Earth Tech Canada Inc. No. 730 Expiry: April 30, 2006	B.M. ELEV.	 Frederickson Cooper ARCHITECTS	 A Terra International Ltd. Company	ENGINEER'S SEAL ORIGINAL SIGNED BY S.R. BILEVICIUS 2006/02/07	 THE CITY OF WINNIPEG WATER AND WASTE DEPARTMENT ENGINEERING DIVISION WATER TREATMENT PLANT FLOCCULATION AND DAF FOUNDATIONS AND CONCRETE STRUCTURES PIPE EMBEDS FIRST FLOOR PLAN AND SECTIONS OZONE CONTACTOR DRAIN	CITY FILE NUMBER SHEET OF
	00 ISSUED FOR TENDER 06/02/03 PL NO. REVISIONS DATE BY	DESIGNED BY KAS DRAWN BY PL/LC SCALE: AS SHOWN	CHECKED BY SRB APPROVED BY DJT RELEASED FOR CONSTRUCTION BY: R. SOROKOWSKI	CONSULTANT DRAWING NO. WP-M9108		CITY DRAWING NUMBER 1-0601P-A-M9108-001-000