
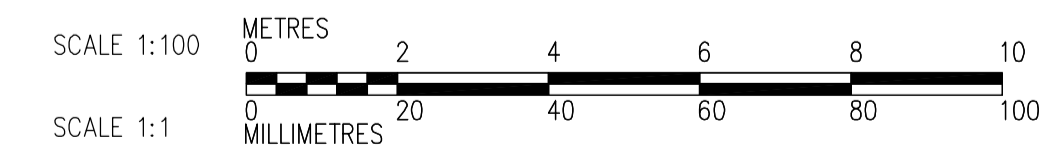


- NOTES:**
1. PROVIDE STAIRWELL SMOKE DETECTORS AT EVERY THIRD FLOOR AND AT TOP.
 2. SEE PANEL SCHEDULES DP-R21 & DP-R22 FOR 600V POWER DISTRIBUTION
 3. CABLE TRAY TAGGING SEE DET. 3 WB-E0455

SECOND FLOOR FACILITY PLAN
1:100

CABLE TRAY TAGGING
SEE DETAIL 4
WB-E04xx

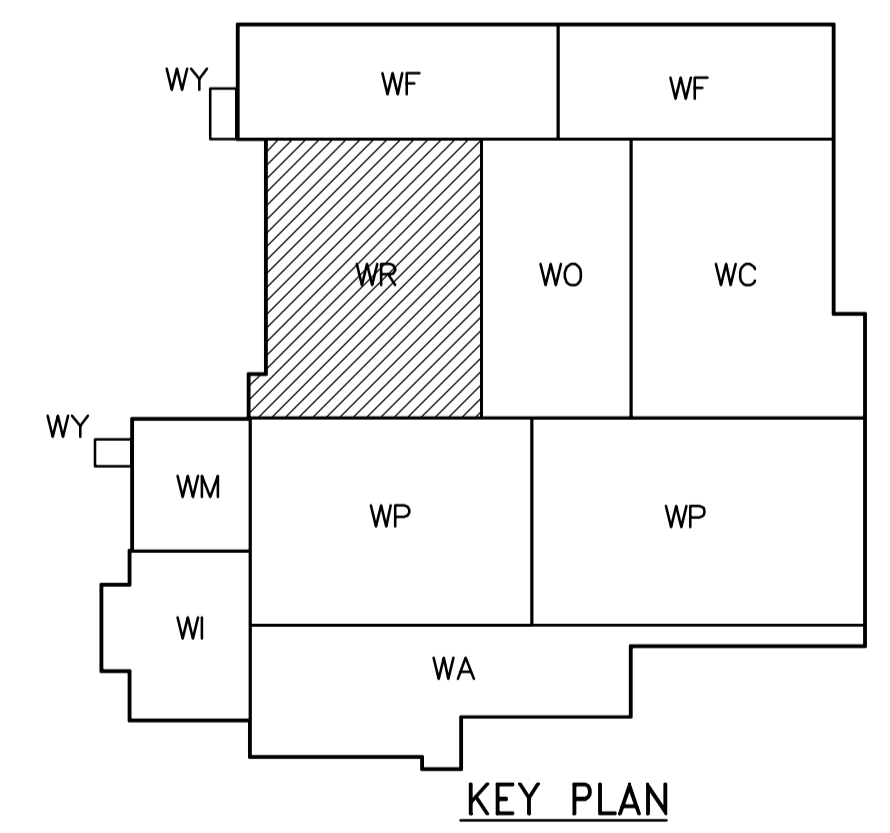

 APEGN Certificate of Authorization CH2M HILL Canada Ltd. No. 1441 Expiry: April 30, 2006	B.M. ELEV.	 Frederickson Cooper ARCHITECTS	 A You International Ltd. Company	ENGINEER'S SEAL ORIGINAL SIGNED BY L.D. LLEWELLYN 2006/03/29	 THE CITY OF WINNIPEG WATER AND WASTE DEPARTMENT ENGINEERING DIVISION
	DESIGNED BY: LL DRAWN BY: TL SCALE: 1:100 NO. REVISIONS: 00 ISSUED FOR TENDER: 06/03/29 DATE: 2005/07/12	CHECKED BY: ND APPROVED BY: AHL RELEASED FOR CONSTRUCTION BY: R. SOROKOWSKI DATE: 2006/03/29	CONSULTANT DRAWING NO. WR-E0121	CITY FILE NUMBER SHEET OF CITY DRAWING NUMBER 1-0601R-A-E0121-001-000	