



B3 B4 B5 B7 B9

FOR CONTINUATION
SEE DWG WR-M9112

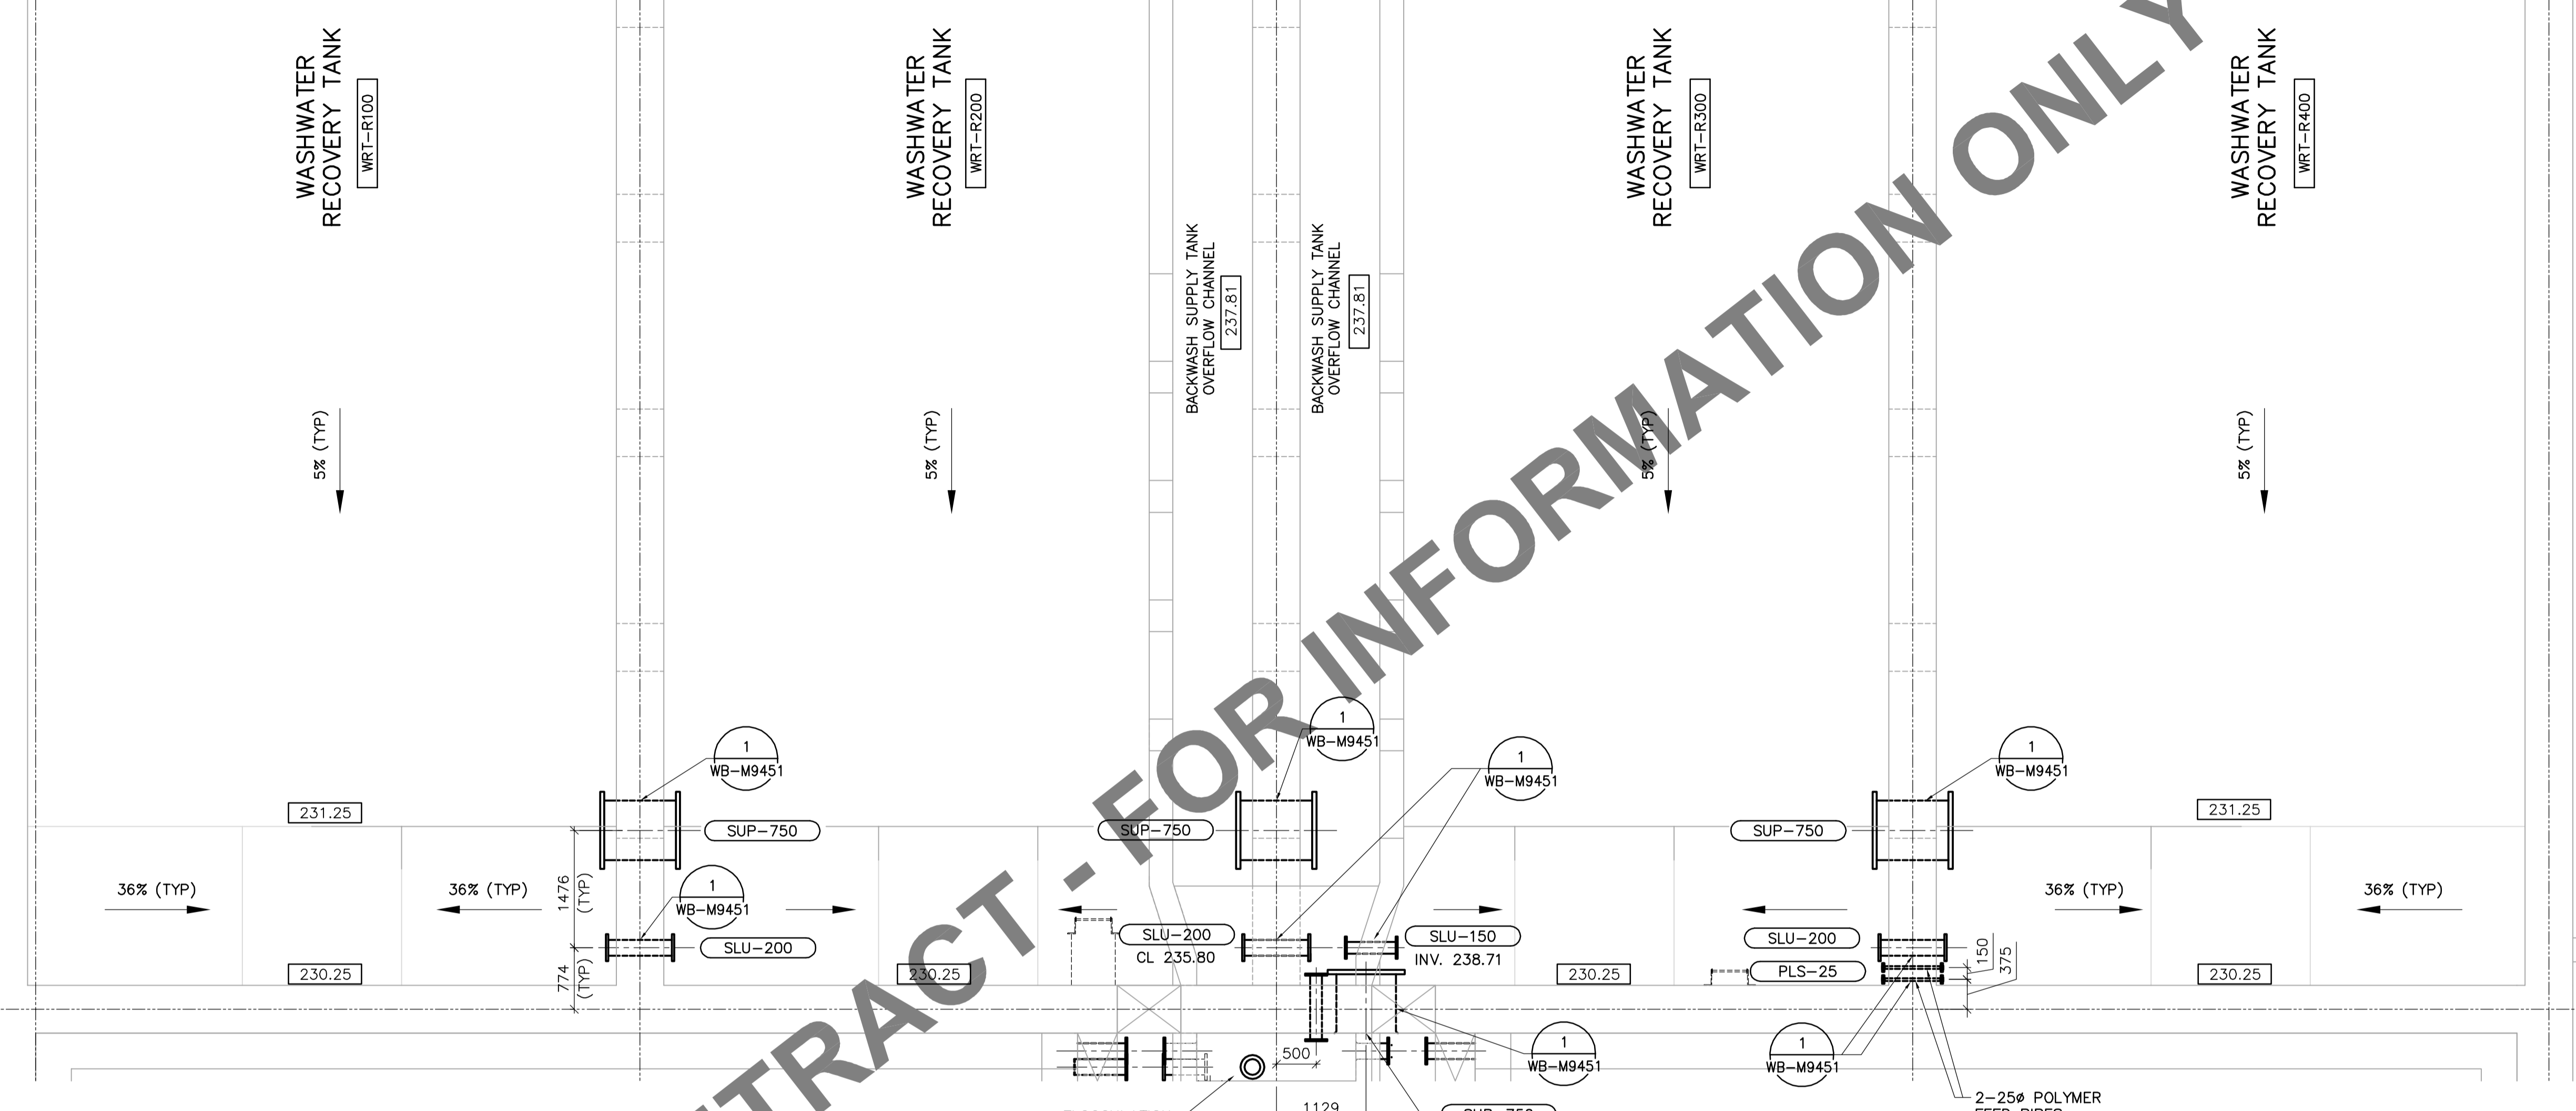


PLAN VIEW AT ELEVATION 239.000
1:50

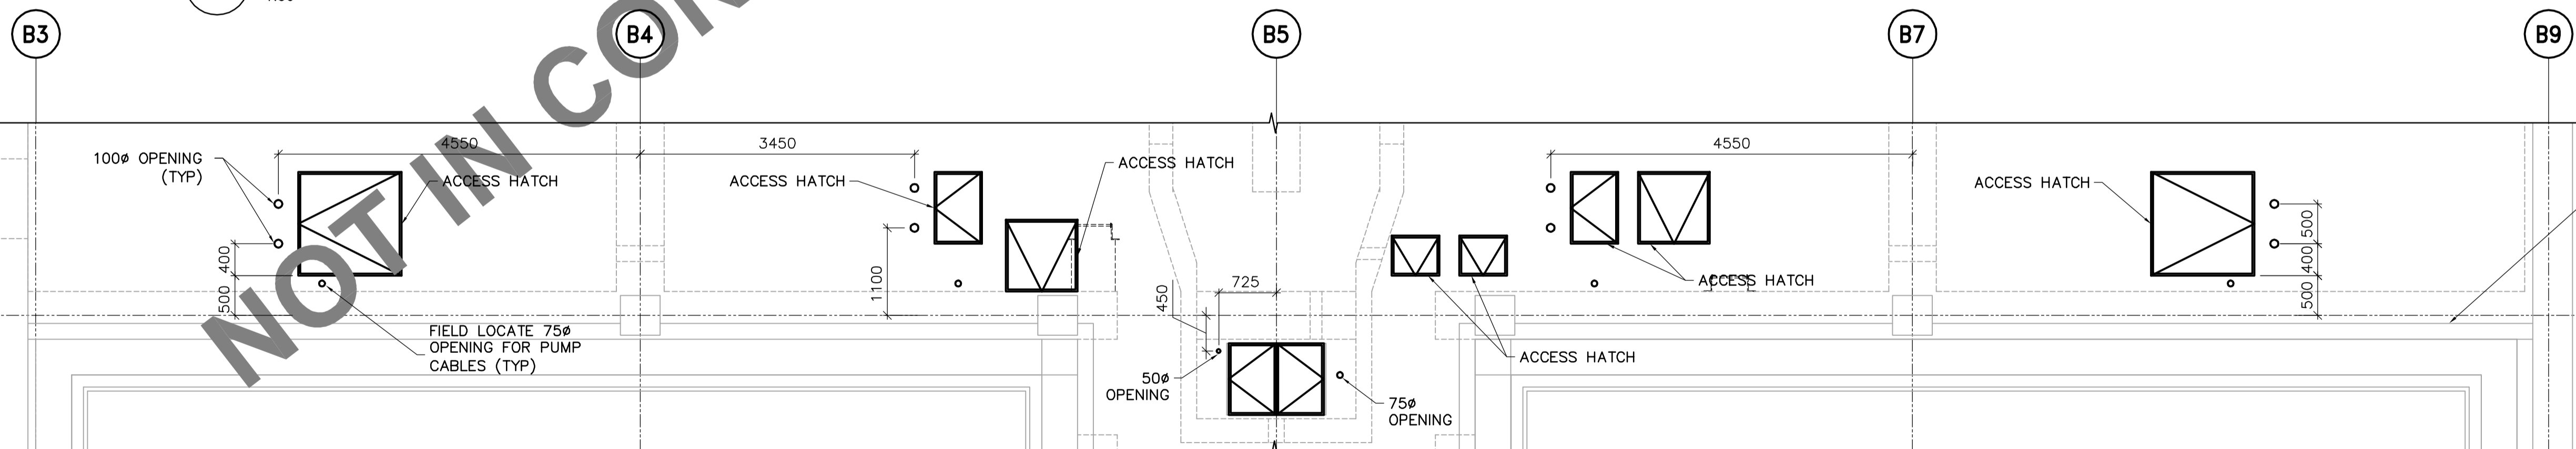

PLAN VIEW AT ELEVATION 239.410
1:50

FOR CONTINUATION
SEE DWG WR-M9123

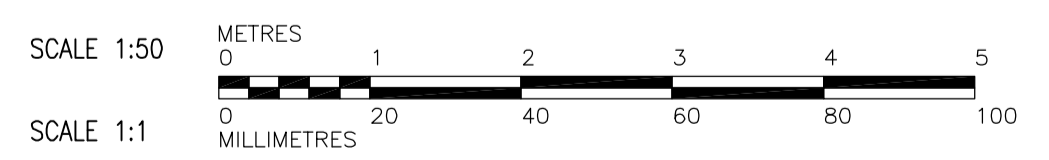

APECA
Certificate of Authorization
Earth Tech Canada Inc.
No. 730 Expiry: April 30, 2006

B.M. ELEV.	
DESIGNED BY	SM
DRAWN BY	JBC
SCALE:	1:50
00 ISSUED FOR TENDER	06/02/03 JBC
NO. REVISIONS	DATE BY
	DATE 2005/09/29

CH2MHILL
Frederickson Cooper
ARCHITECTS

EarthTech
A Tetra International Ltd. Company

DESIGNED BY: SM
CHECKED BY: SRB
DRAWN BY: JBC
APPROVED BY: DJT
SCALE: 1:50
RELEASED FOR CONSTRUCTION BY: R. SOROKOWSKI

ENGINEER'S SEAL
ORIGINAL SIGNED BY
S.R. BILEVICIUS
2006/02/07
CONSULTANT DRAWING NO.
WR-M9113

THE CITY OF WINNIPEG
WATER AND WASTE DEPARTMENT
ENGINEERING DIVISION

WATER TREATMENT PLANT
RESIDUALS HANDLING
FOUNDATIONS AND CONCRETE STRUCTURES

PIPE EMBEDS
WASHWATER RECOVERY TANKS
PROCESS PIPING PLAN

CITY FILE NUMBER
SHEET OF
CITY DRAWING NUMBER
1-0601R-A-M9113-001-000