




**THE CITY OF WINNIPEG
PUBLIC WORKS DEPARTMENT
ENGINEERING DIVISION**

**SAND and SALT STORAGE FACILITY
at 1539 WAVERLEY STREET
DESIGN SUPPLY AND CONSTRUCTION
BID OPPORTUNITY No. 9-2005**

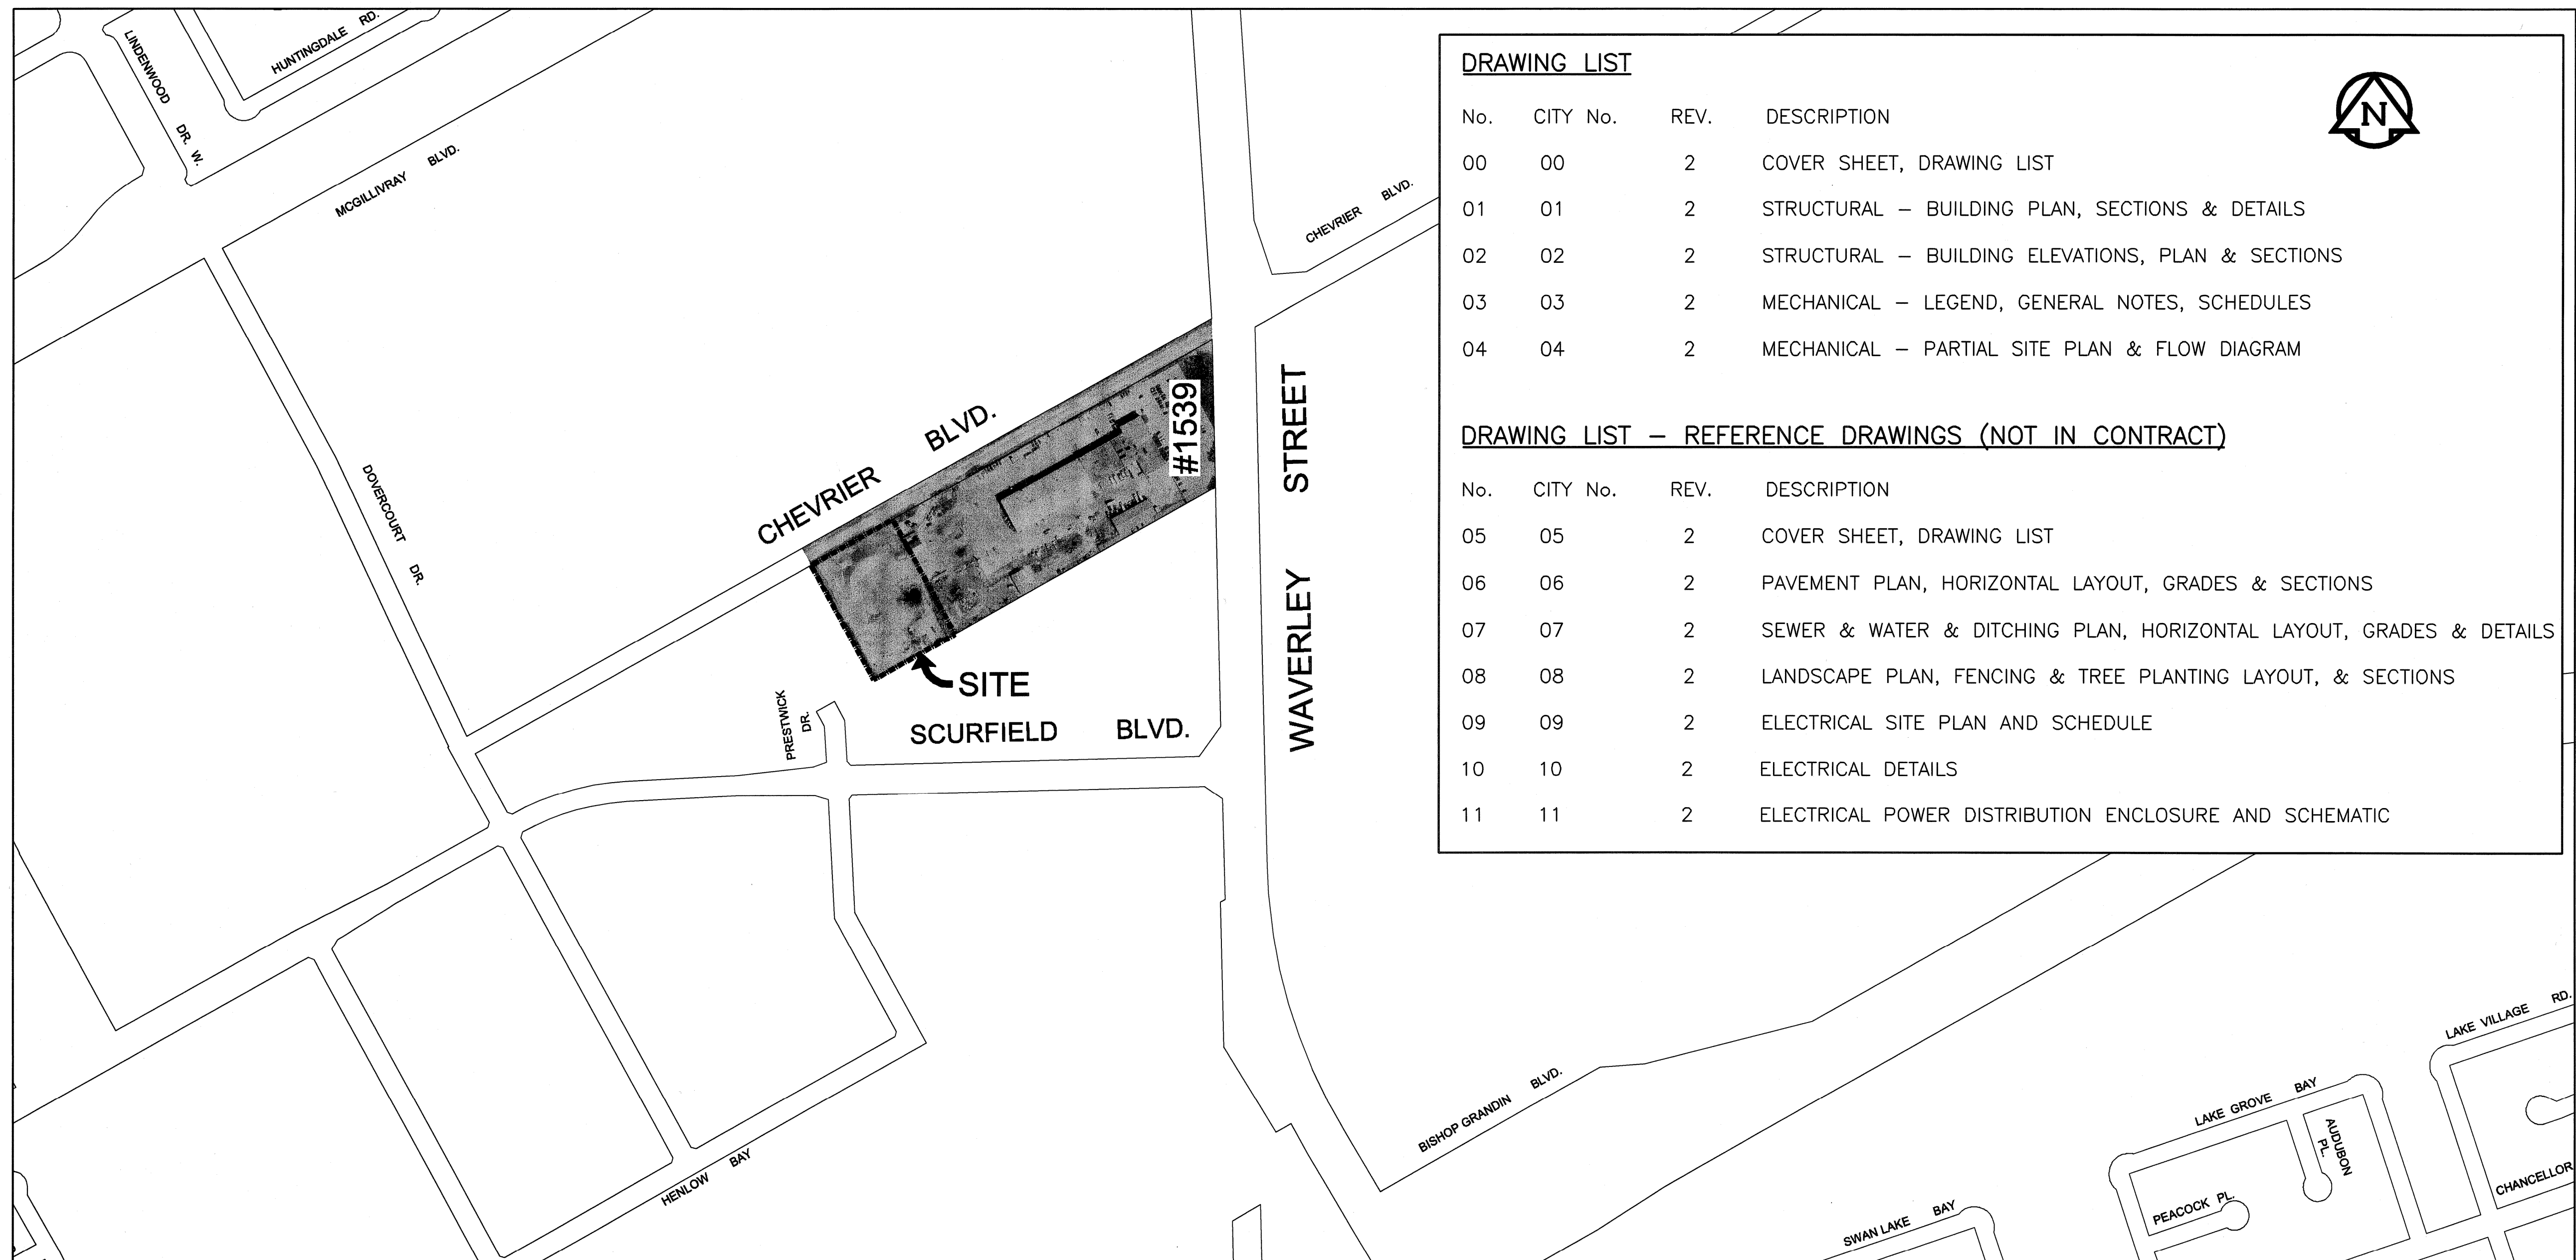

DRAWING LIST			
No.	CITY No.	REV.	DESCRIPTION
00	00	2	COVER SHEET, DRAWING LIST
01	01	2	STRUCTURAL – BUILDING PLAN, SECTIONS & DETAILS
02	02	2	STRUCTURAL – BUILDING ELEVATIONS, PLAN & SECTIONS
03	03	2	MECHANICAL – LEGEND, GENERAL NOTES, SCHEDULES
04	04	2	MECHANICAL – PARTIAL SITE PLAN & FLOW DIAGRAM

DRAWING LIST – REFERENCE DRAWINGS (NOT IN CONTRACT)			
No.	CITY No.	REV.	DESCRIPTION
05	05	2	COVER SHEET, DRAWING LIST
06	06	2	PAVEMENT PLAN, HORIZONTAL LAYOUT, GRADES & SECTIONS
07	07	2	SEWER & WATER & DITCHING PLAN, HORIZONTAL LAYOUT, GRADES & DETAILS
08	08	2	LANDSCAPE PLAN, FENCING & TREE PLANTING LAYOUT, & SECTIONS
09	09	2	ELECTRICAL SITE PLAN AND SCHEDULE
10	10	2	ELECTRICAL DETAILS
11	11	2	ELECTRICAL POWER DISTRIBUTION ENCLOSURE AND SCHEMATIC



AutoCAD 16.1s (LMS Tech) P:\0265\366-00\ALD\Sand Salt Facility 1539 Waverley.dwg Sand Salt Facility Cover - Blg.dwg 2005-01-20 11:55am CGC




UMA Engineering Ltd.

• Consulting • Engineering • Construction • Management Services

RELEASED FOR CONSTRUCTION BY:

STREETS PROJECT ENGINEER

DATE

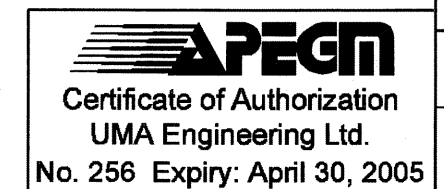

COVER SHEET AND LOCATION PLAN	
CITY DRAWING NUMBER	00
CONSULTANT NO.	41-0103-0265-366-00