


1 PARTIAL SITE PLAN
1:500

- NOTES**
- CONDUIT FOR FUTURE SAND/SALT STORAGE BUILDING CCTV CABLING TO HAVE 6mm NYLON PULL CORD INSTALLED. CAP CONDUIT TO PREVENT DEBRIS FROM ENTERING AT EACH END.
 - UNDERGROUND SERVICES INCLUDING TELEPHONE, SEWER, WATER, NATURAL GAS, AND ELECTRICAL MAY EXIST IN PROXIMITY OF CONSTRUCTION AREA. COORDINATE FLOOD LIGHT, POWER CABLING AND CONDUIT AND FLOOD LIGHT BASE INSTALLATION TO AVOID THESE SERVICES.

- LEGEND**
- EXISTING POLE MOUNTED FLOODLIGHT
 - NEW POLE MOUNTED FLOODLIGHT
A DENOTES TYPE OF LUMINAIRE
B08 DENOTES CIRCUIT NUMBER
 - 20mm DIA. x 3m LONG COPPER CLAD GROUND ROD LOCATION
 - LOCATION OF BURIED CONDUIT OR CABLING
 - 50 POLYETHYLENE DUCT U/S ROADWAYS FOR CABLE TRANSIT. DUCT TO EXTEND 1000 PAST EDGE OF ROADWAY SHOULDER

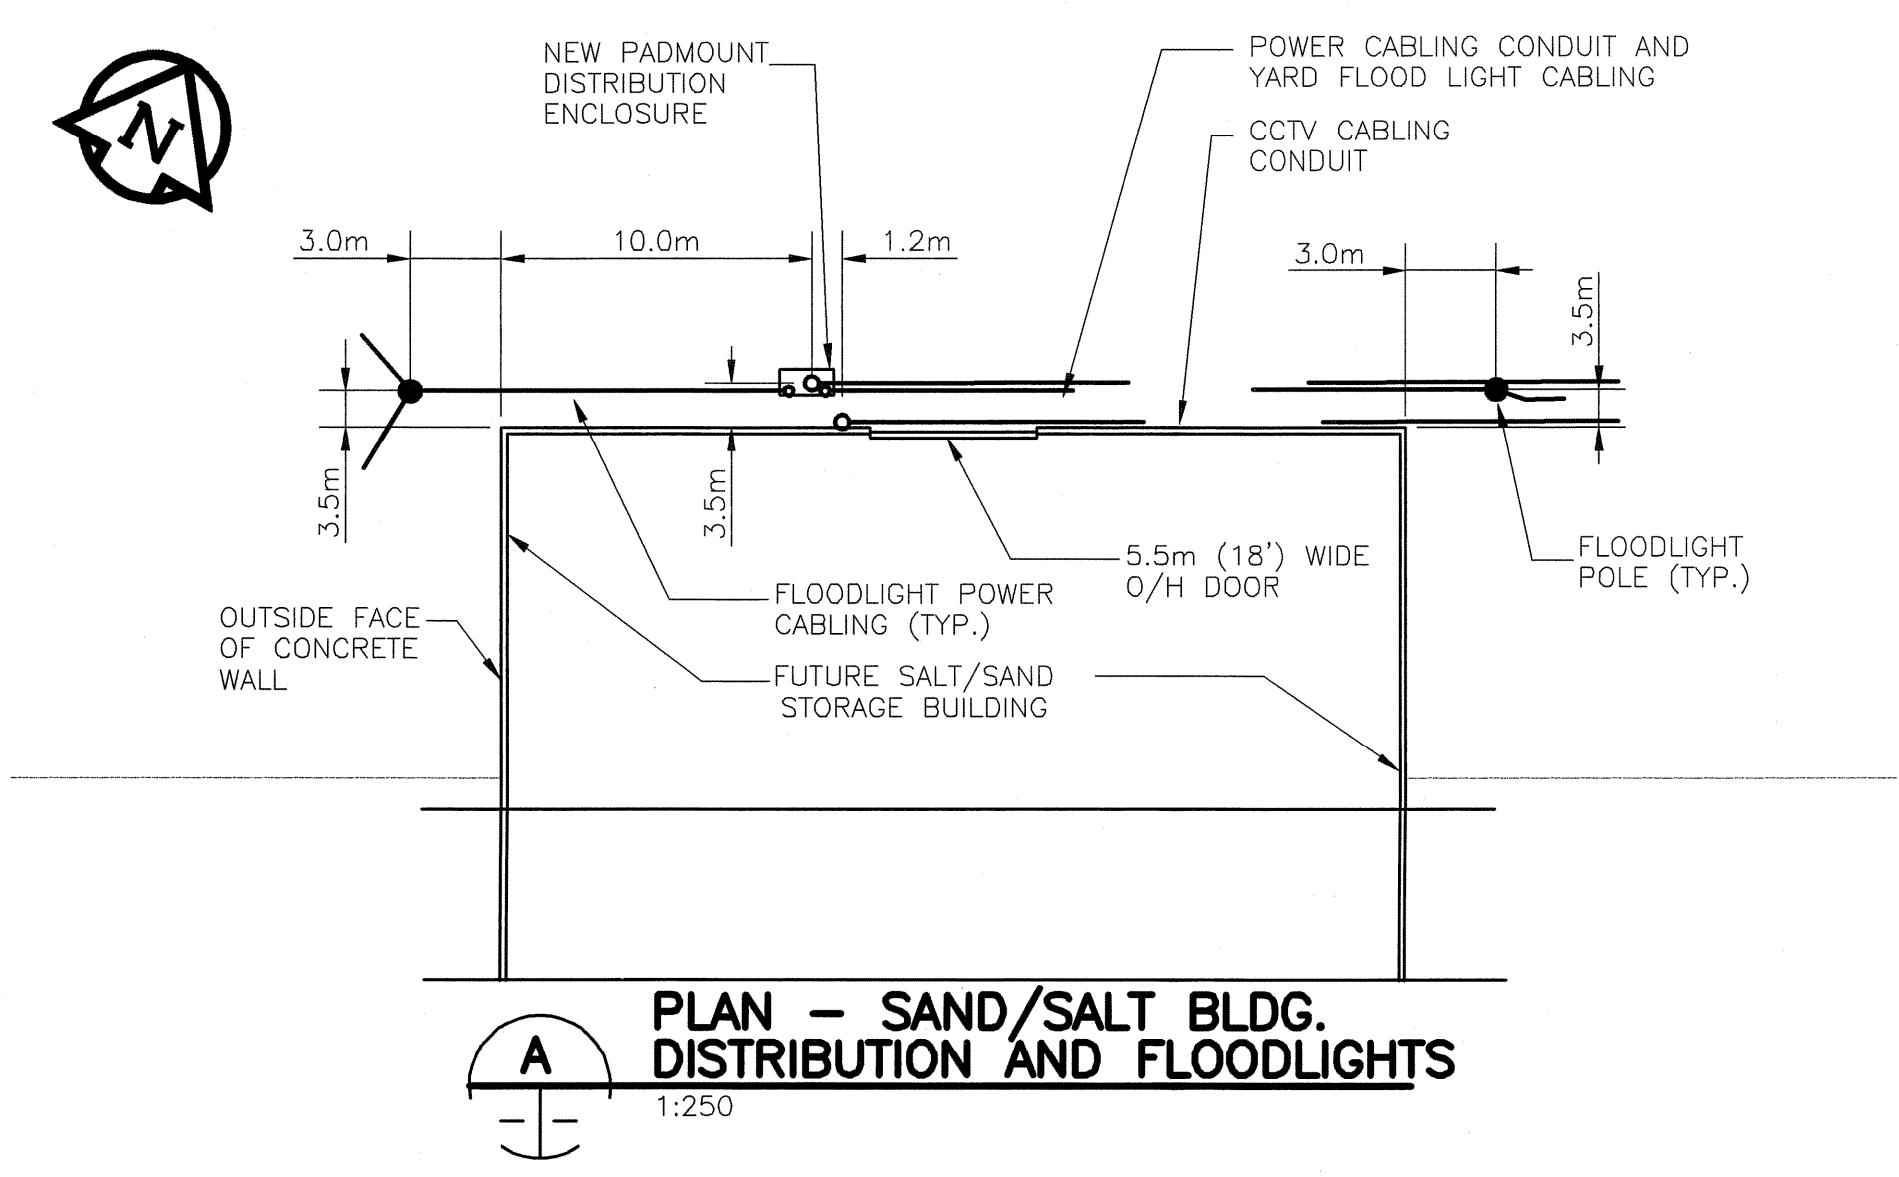

A PLAN - SAND/SALT BLDG. DISTRIBUTION AND FLOODLIGHTS
1:250

LUMINAIRE SCHEDULE					
TYPE	MANUFACTURER	CAT. NO.	LAMP	VOLTAGE	REMARKS
A	LITHONIA	TFA 1000S RN CSA 6 x 3 LIGHT PATTERN	1000W CLEAR HPS	120V	TENON MOUNT FLOODLIGHT ON 12.2m (40') HEXAGON TAPERED POLE, MARTEC MFG. MFP-40 BRONZE FINISH OR EQUAL C/W PHOTOCELL LUMINAIRE FINISH TO BE DARK BROWN. PROVIDE INTERNAL BAFFLES AS REQUIRED TO AVOID SPILL OF LIGHTIN TO ADJACENT RESIDENTIAL AREAS.
B	LITHONIA	TFA 1000S TA CSA 7 x 7 LIGHT PATTERN	1000W CLEAR HPS	120V	TENON MOUNT FLOODLIGHT ON 12.2m (40') HEXAGON TAPERED POLE, MARTEC MFG. MFP-40 BRONZE FINISH OR EQUAL C/W PHOTOCELL LUMINAIRE FINISH TO BE DARK BROWN. PROVIDE INTERNAL BAFFLES AS REQUIRED TO AVOID SPILL OF LIGHTIN TO ADJACENT RESIDENTIAL AREAS.

**NOT IN CONTRACT
FOR REFERENCE
PURPOSES ONLY**

BID OPPORTUNITY No.
9-2005

METRIC
WHOLE NUMBERS INDICATE MILLIMETRES
DECIMALIZED NUMBERS INDICATE METRES

APEGM
Certificate of Authorization
UMA Engineering Ltd.
No. 256 Expiry: April 30, 2005

B.M. 75-004	S.W. crn. Waverley St. & Chevrier Blvd.		
1.0m W. & 0.9m below brick of N. E. corner of Building			
2	RE-ISSUED FOR BID	05Feb01	DML
1	ISSUED FOR CONSTRUCTION	04Apr23	SCK
0	ISSUED FOR REVIEW	04Apr02	SCK
NO.	REVISIONS	DATE	BY

UMA Engineering Ltd.
Consulting • Engineering • Construction • Management Services

DESIGNED BY SCK CHECKED BY BLM
DRAWN BY SCK APPROVED BY [Signature]

HOR. SCALE: 1:500
VERTICAL: N/A

RELEASED FOR CONSTRUCTION

DATE: 04/02/12

ENGINEER'S SEAL
PROVINCE OF MANITOBA
B.N. FEUER
REGISTERED PROFESSIONAL ENGINEER
Feb 105

THE CITY OF WINNIPEG
PUBLIC WORKS DEPARTMENT
ENGINEERING DIVISION

SAND/SALT STORAGE FACILITY
PUBLIC WORKS YARD
1539 WAVERLEY STREET

ELECTRICAL
SITE PLANS AND SCHEDULES

CITY DRAWING NUMBER 09
SHEET 09 OF 11
REV 2

CONSULTANT DRAWING NO. 41-09-0265-366-00

PLOT SCALE = 1:0.50
AutoCAD 15.05 P:\0265\366-00\ALD\Sand Salt Facility 1539 Waverley.dwg Sand Salt Facility Site Plan.dwg 2004-02-13 09:50am DID