
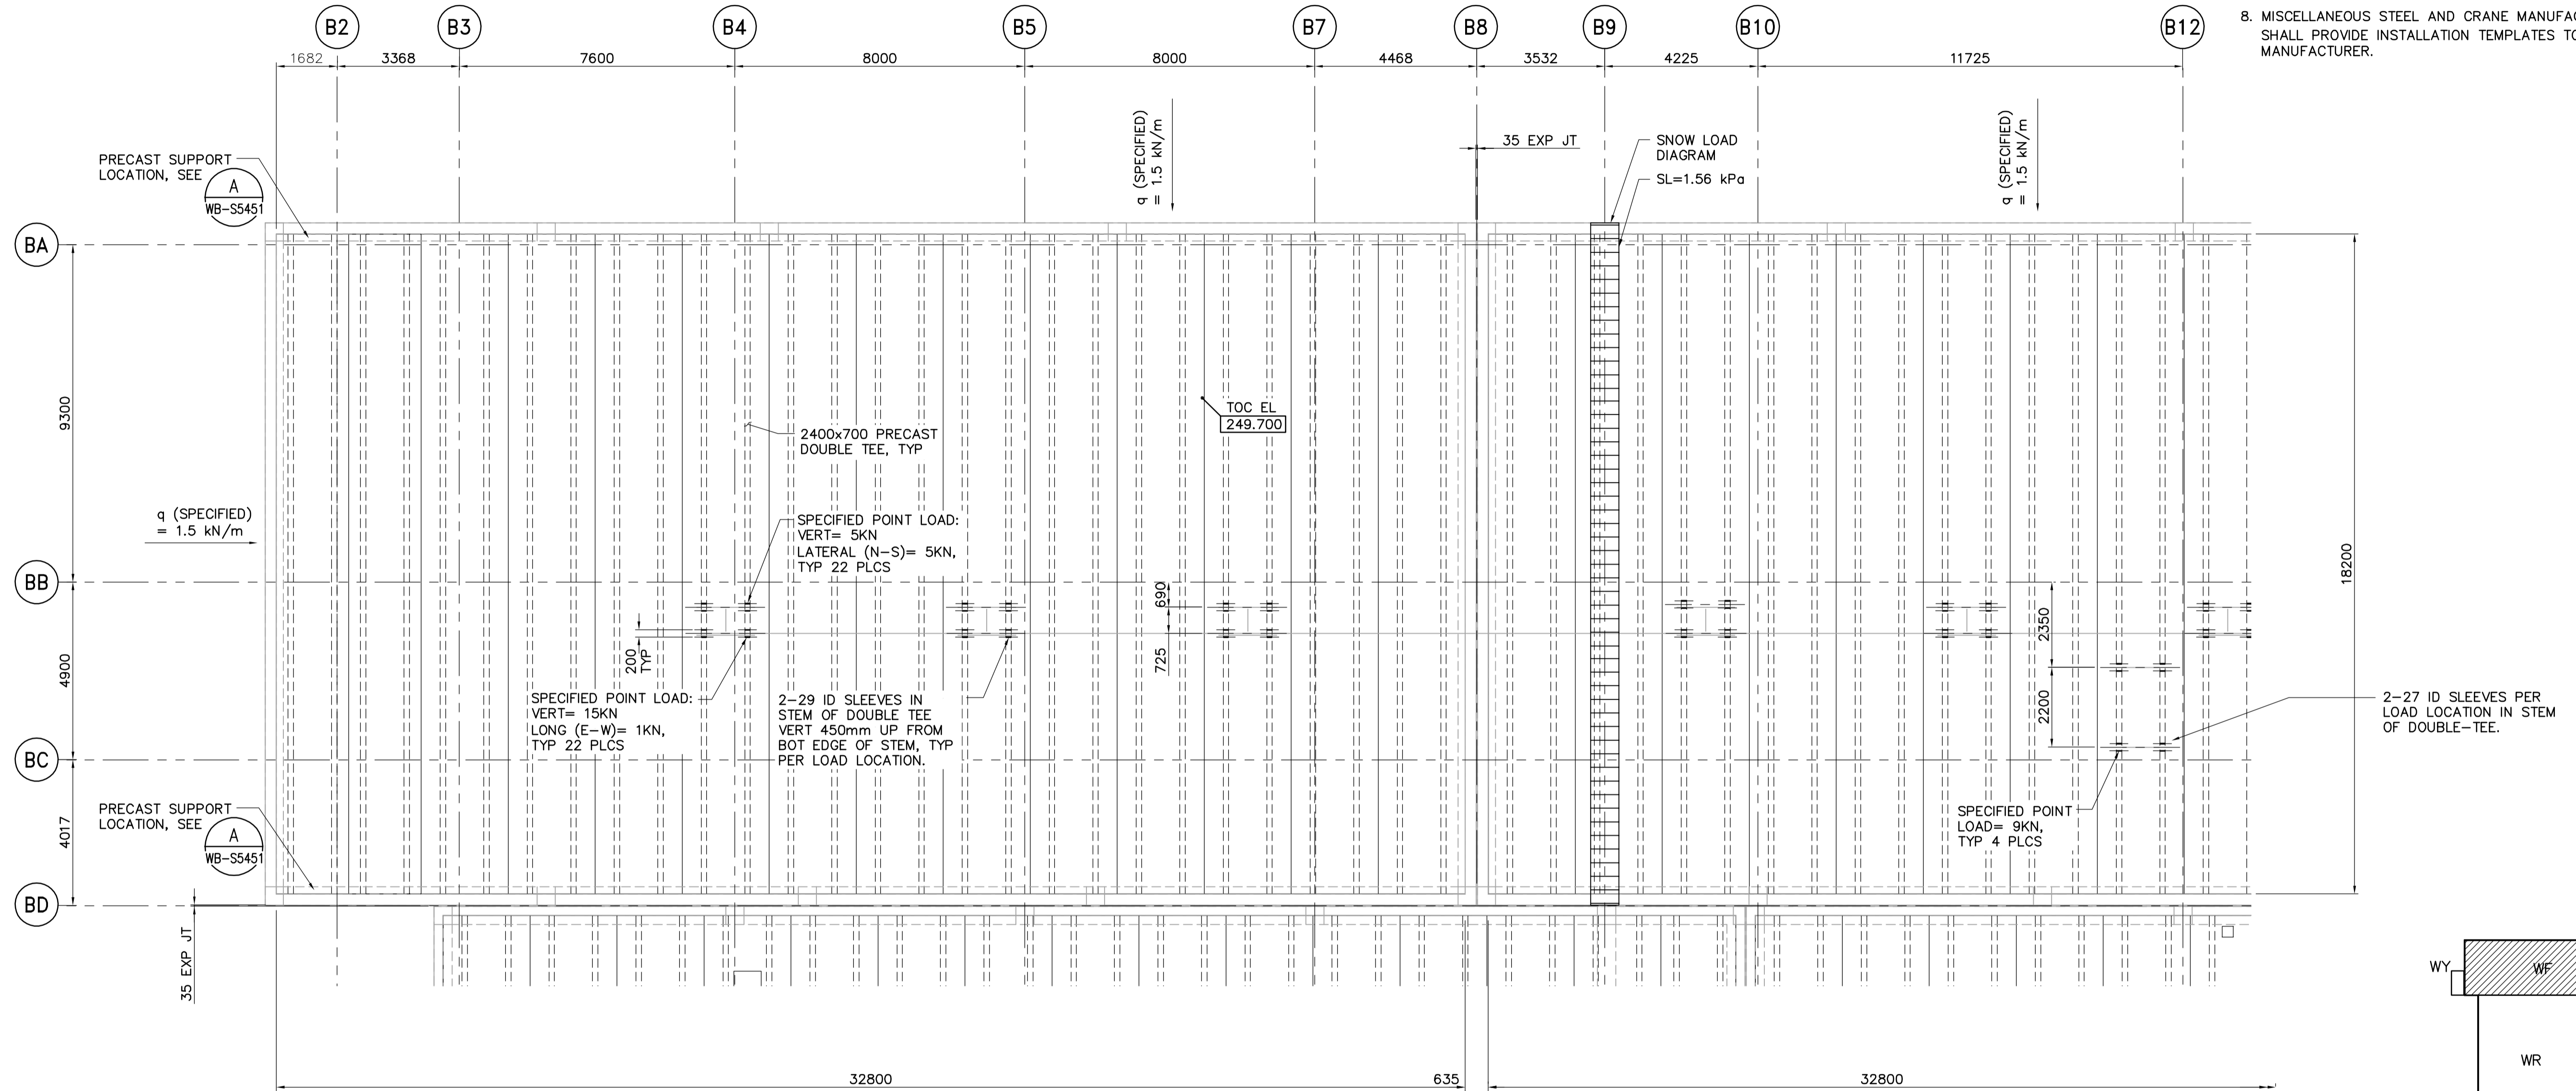




NOTES:





- SPECIFIED SNOW LOAD AS NOTED ON PLAN.
- SPECIFIED SERVICE LOAD = 1 kPa
- SEE DRAWING WB-S5451 FOR PRECAST DETAILS.
- SEE DETAIL  TO SUPPORT LIGHT FIXTURES, INSTALLED UNDER SEPARATE CONTRACT.
- PROVIDE 20mm DIA SLEEVES IN ALL DOUBLE TEE STEMS 1200mm C/C.
- PROVIDE GALVANIZED STEEL SLEEVES FOR THROUGH BOLTS.
- COORDINATE WITH CONTRACT ADMINISTRATOR LOCATION OF ALL THROUGH BOLTS (BO 742-2005)
- MISCELLANEOUS STEEL AND CRANE MANUFACTURER SHALL PROVIDE INSTALLATION TEMPLATES TO THE PRECAST MANUFACTURER.

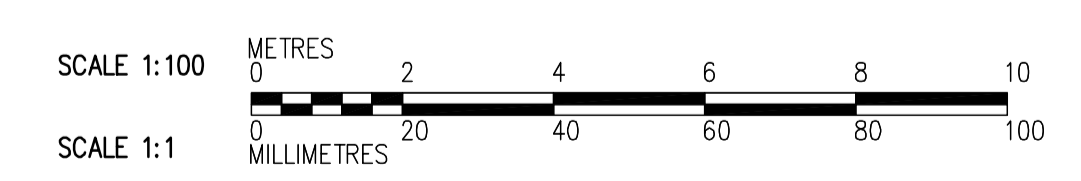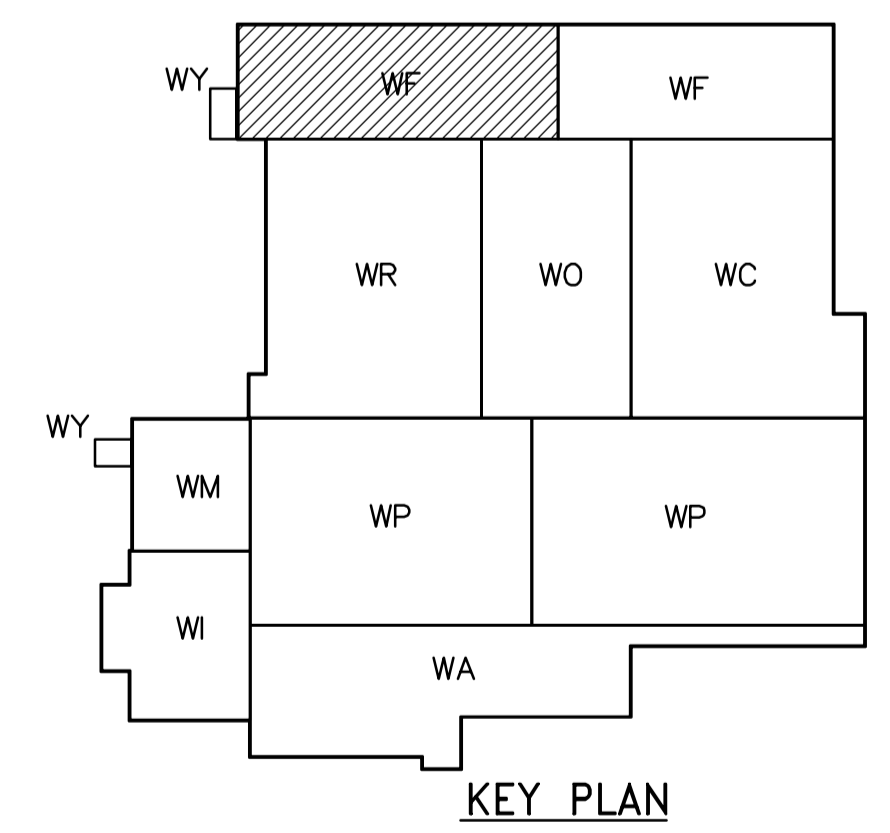

2-27 ID SLEEVES PER LOAD LOCATION IN STEM OF DOUBLE-TEE.

ROOF PLAN
1:100



| | | | | | | |
|---|--|--|--|--|---|------------------|
|  APEGH Certificate of Authorization CH2M HILL Canada Ltd. No. 1441 Expiry: April 30, 2007 | B.M. ELEV. |  Frederickson Cooper ARCHITECTS |  EarthTech A 100 International Ltd. Company | ENGINEER'S SEAL ORIGINAL SIGNED BY D. KRUGER 2006/10/11 |  THE CITY OF WINNIPEG WATER AND WASTE DEPARTMENT ENGINEERING DIVISION WATER TREATMENT PLANT FILTRATION SUPPLY AND INSTALLATION OF PRECAST ROOF PANELS STRUCTURAL FILTRATION AREA 1 ROOF PLAN | CITY FILE NUMBER |
| | DESIGNED BY MH CHECKED BY AP | DRAWN BY CR APPROVED BY AHL | CONSULTANT DRAWING NO. WF-S5146 | SHEET OF | | |
| | SCALE: 1:100 RELEASED FOR CONSTRUCTION BY: R. SOROKOWSKI | DATE 2006/08/30 DATE 2006/10/11 | CITY DRAWING NUMBER 1-0601F-A-S5146-001-000 | | | |
| | NO. REVISIONS DATE BY | 00 ISSUED FOR TENDER 06/10/11 DK | | | | |