




- NOTES:**
- SPECIFIED SNOW LOAD AS NOTED ON PLAN.
 - SPECIFIED SERVICE LOAD IS 1.0 kPa.
 - SEE DRAWING WB-S5451 FOR PRECAST DETAILS.
 - SEE DETAIL 3 TO SUPPORT LIGHT FIXTURES, INSTALLED UNDER SEPARATE CONTRACT.
 - PROVIDE 20mm DIA SLEEVES IN ALL DOUBLE TEE STEMS 1200mm C/C.

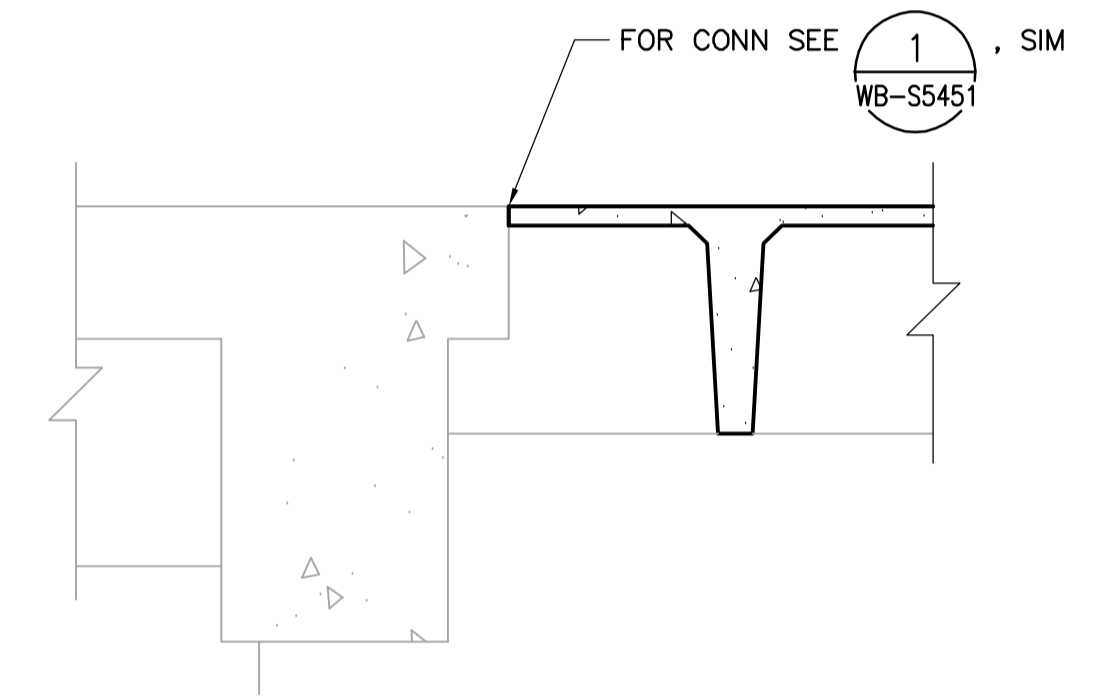

A SECTION
WM-S5141 1:20

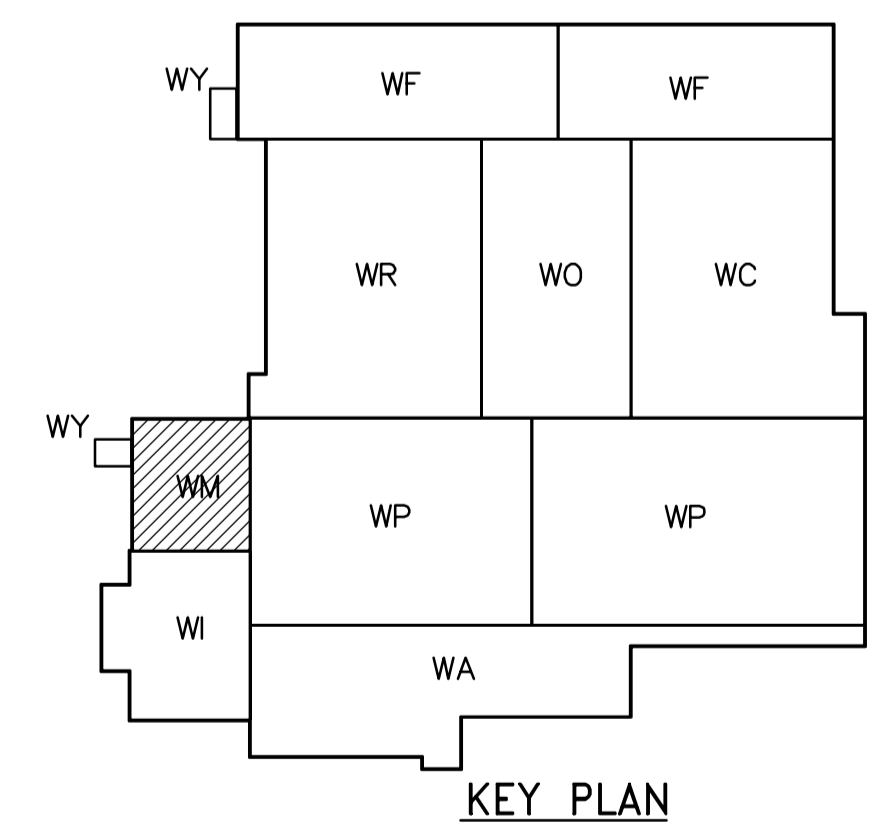

ROOF PLAN
1:100

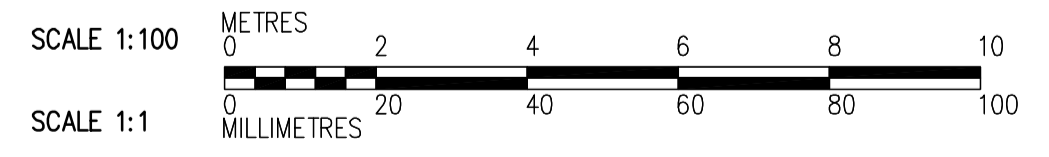

 APEGN Certificate of Authorization CH2M HILL Canada Ltd. No. 1441 Expiry: April 30, 2007	 Frederickson Cooper ARCHITECTS	 EarthTech A 100 International Ltd. Company	ENGINEER'S SEAL	 THE CITY OF WINNIPEG WATER AND WASTE DEPARTMENT ENGINEERING DIVISION	CITY FILE NUMBER
			DESIGNED BY: MH CHECKED BY: AP DRAWN BY: CR APPROVED BY: AHL SCALE: AS NOTED RELEASED FOR CONSTRUCTION BY: R. SOROKOWSKI		ORIGINAL SIGNED BY: D. KRUGER DATE: 2006/10/11 CONSULTANT DRAWING NO.: WM-S5146
B.M. ELEV.	00 ISSUED FOR TENDER 06/10/11 DK NO. REVISIONS DATE BY DATE 2006/08/30 DATE 2006/10/11			STRUCTURAL ELECTRICAL ROOM ROOF PLAN	