


- NOTES:**
- SPECIFIED SNOW LOAD AS NOTED ON PLAN.
  - SPECIFIED SERVICE LOAD = 1 kPa
  - SEE DRAWING WB-S5451 FOR PRECAST DETAILS.
  - SEE DETAIL 3 TO SUPPORT LIGHT FIXTURES, INSTALLED UNDER SEPARATE CONTRACT.
  - PROVIDE 20mm DIA SLEEVES IN ALL DOUBLE TEE STEMS 1200mm C/C.
  - PROVIDE GALVANIZED STEEL SLEEVES FOR THROUGH BOLTS.
  - COORDINATE WITH CONTRACT ADMINISTRATOR LOCATION OF ALL THROUGH BOLTS (BO 742-2005)
  - MISCELLANEOUS STEEL AND CRANE MANUFACTURER SHALL PROVIDE INSTALLATION TEMPLATES TO THE PRECAST MANUFACTURER.

**ROOF PLAN**  
1:100

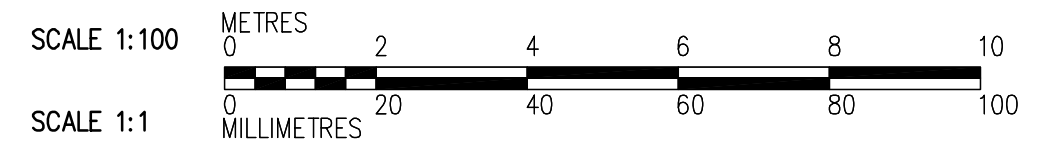

 Certificate of Authorization CH2M HILL Canada Ltd. No. 1441 Expiry: April 30, 2007	 DESIGNED BY MH DRAWN BY CR SCALE: 1:100	 CHECKED BY AP APPROVED BY AHL RELEASED FOR CONSTRUCTION BY: R. SOROKOWSKI	ENGINEER'S SEAL ORIGINAL SIGNED BY D. KRUGER 2006/10/11	 WATER TREATMENT PLANT FLOCCULATION AND DAF SUPPLY AND INSTALLATION OF PRECAST ROOF PANELS STRUCTURAL FLOC/DAF AREA 2 ROOF PLAN	CITY FILE NUMBER SHEET OF
			CONSULTANT DRAWING NO. WP-S5147		CITY DRAWING NUMBER 1-0601P-A-S5147-001-000
			B.M. ELEV.		
			NO. REVISIONS      DATE      BY		

00 ISSUED FOR TENDER      06/10/11      DK  
 DATE 2006/08/30      DATE 2006/10/11