




PUMP ROOM UNDER MEZZANINE – LIGHTING PLAN
SCALE: 1:100

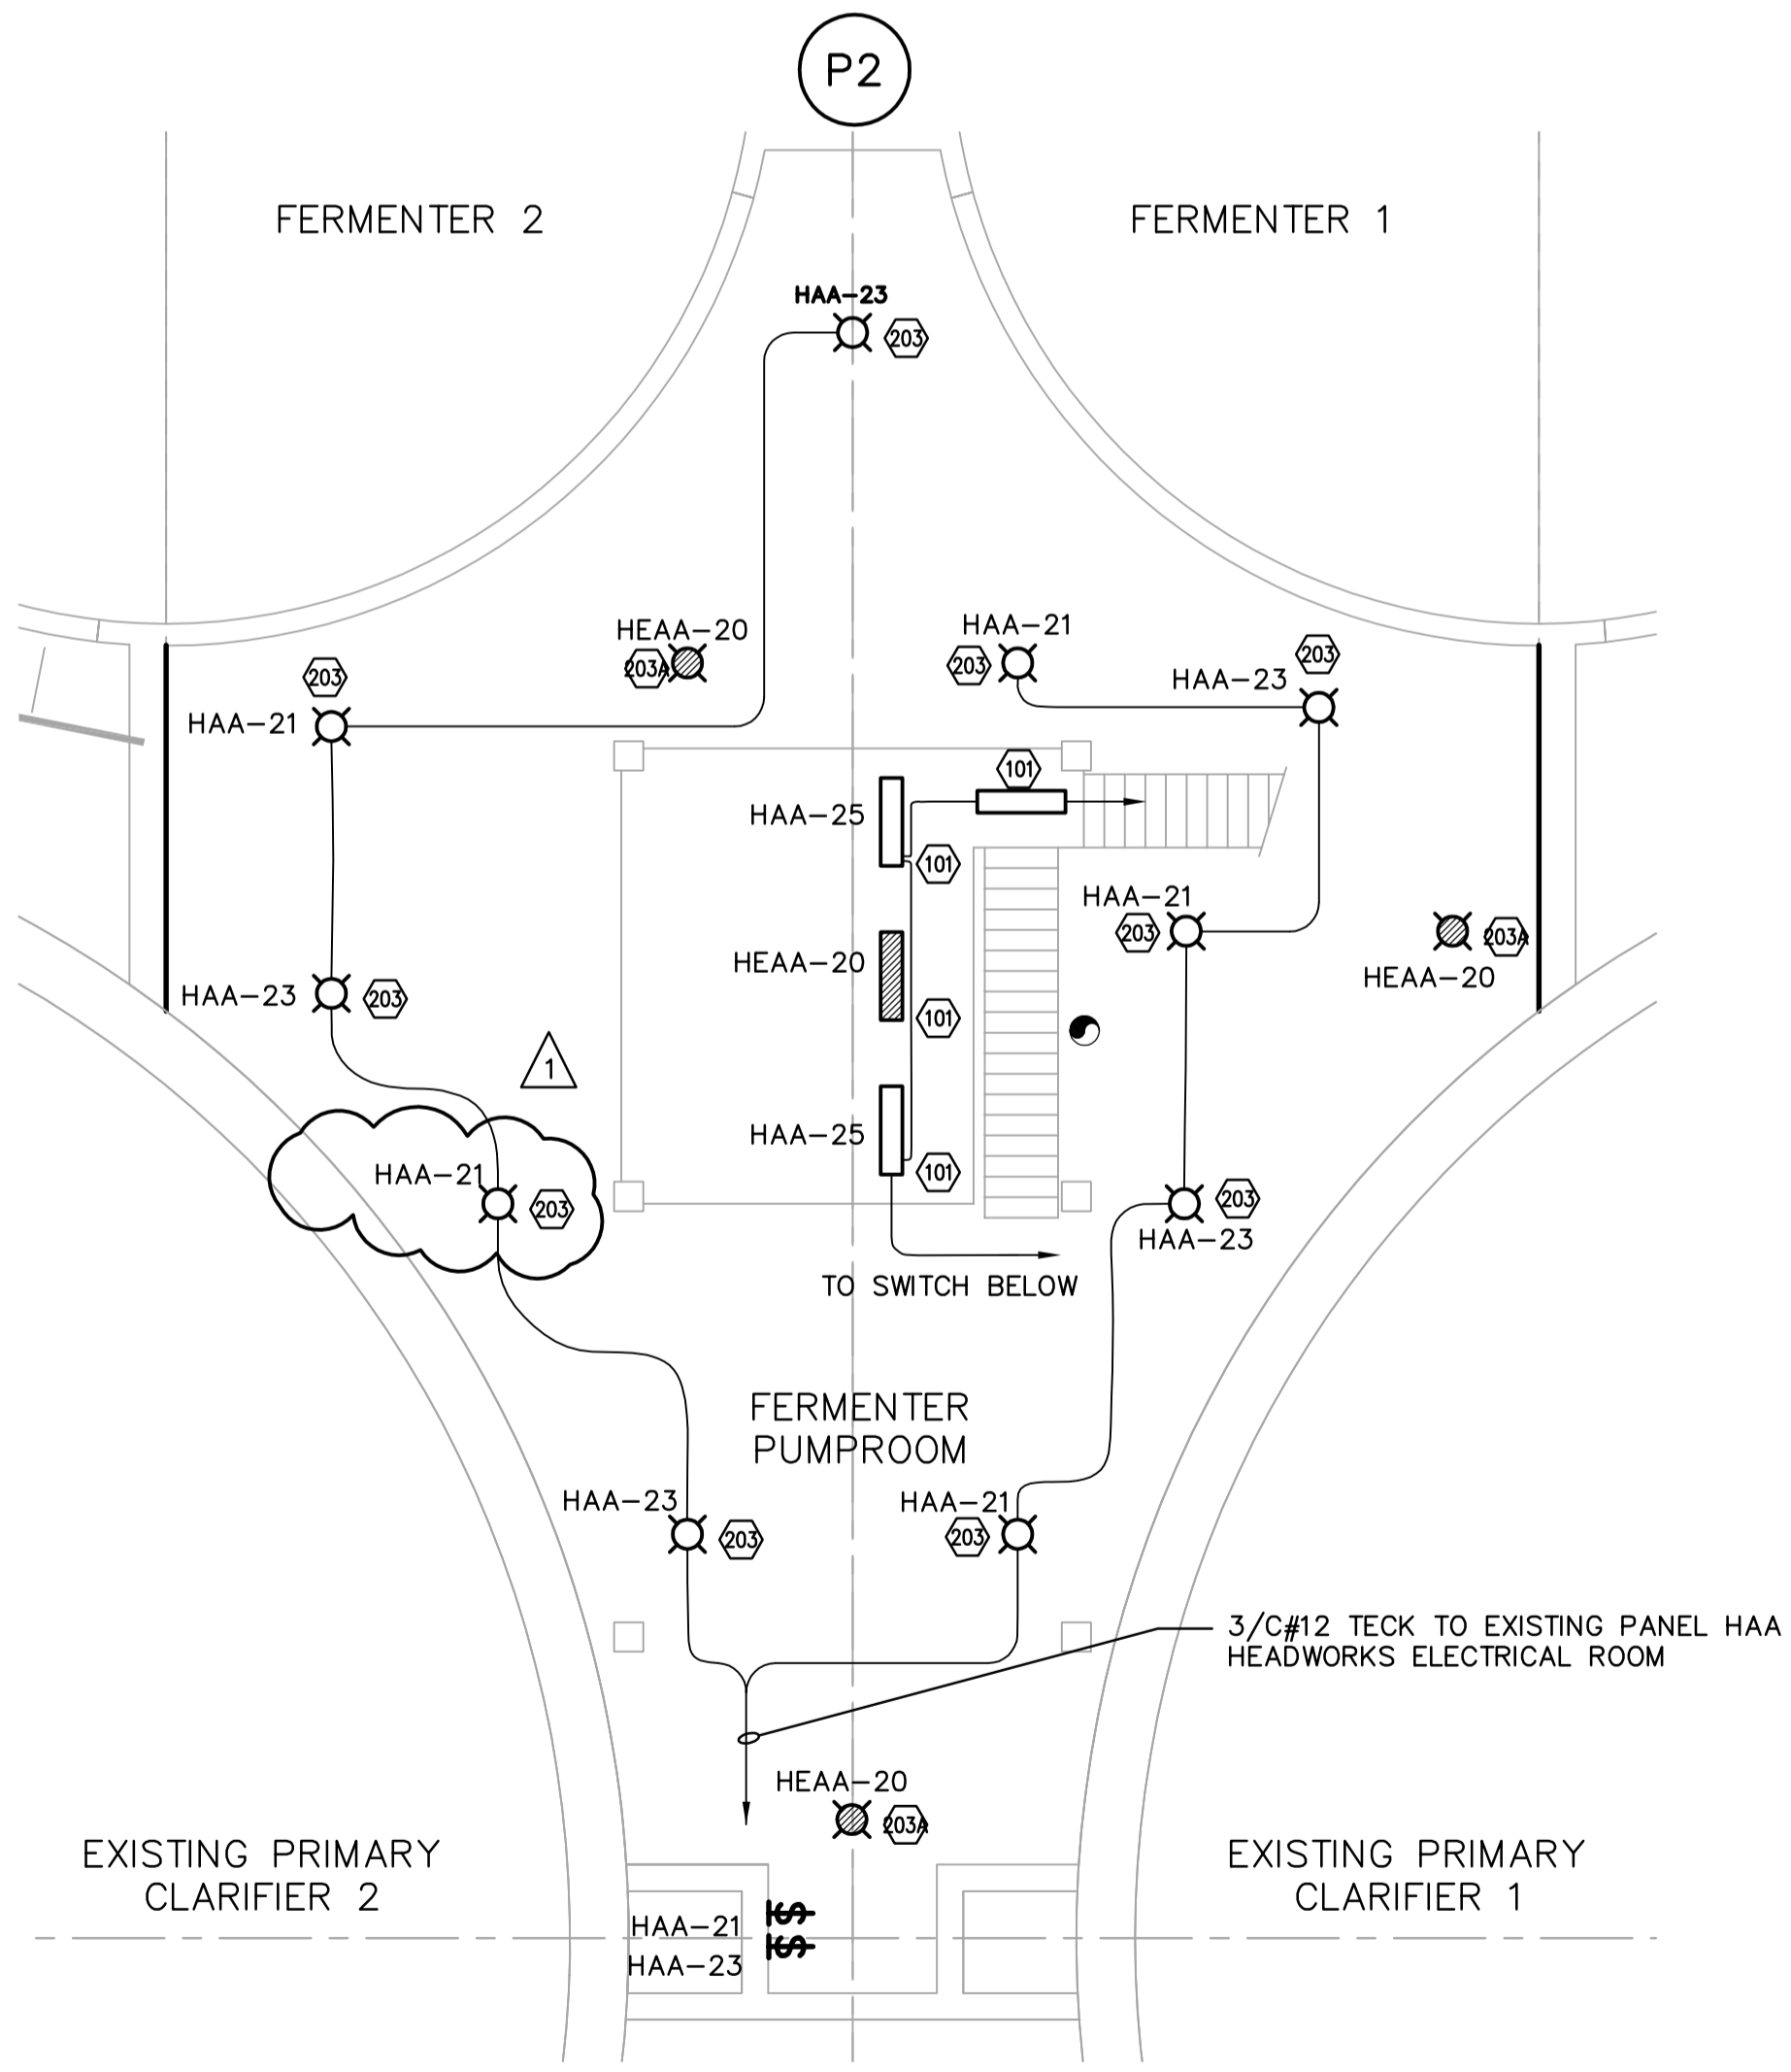

FERMENTER PUMP ROOM – LIGHTING PLAN
SCALE: 1:100

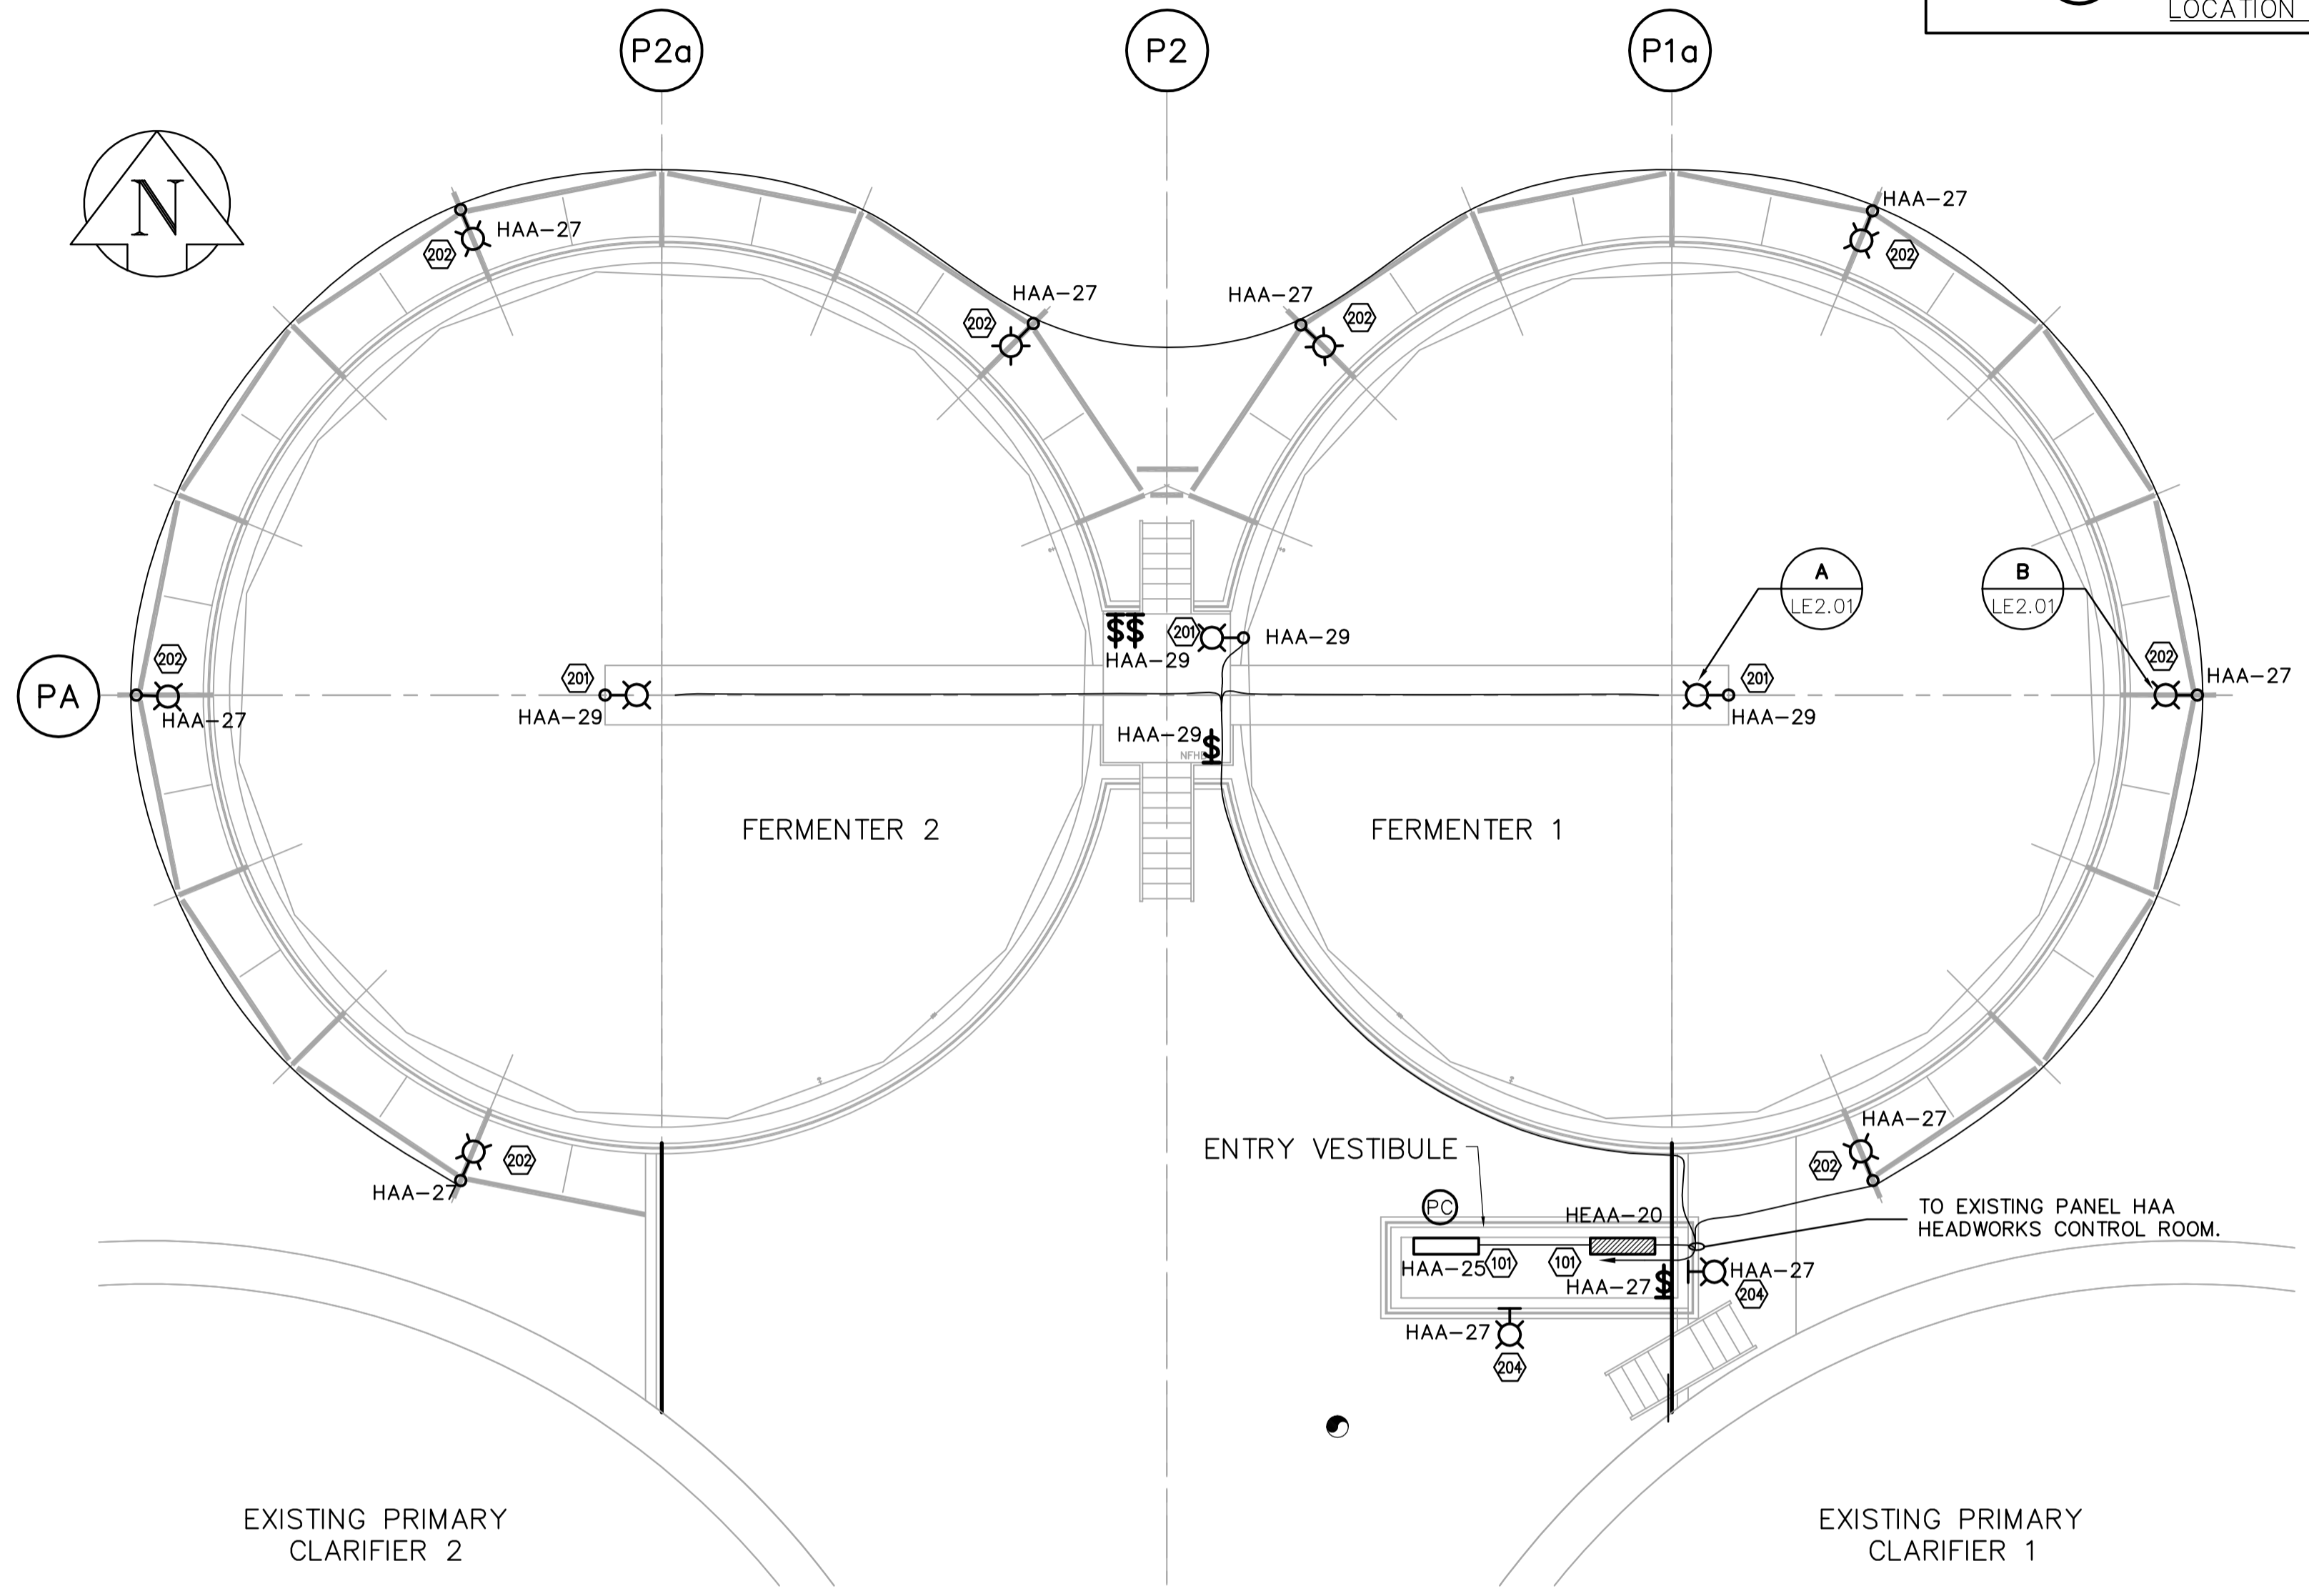

FERMENTER ROOF – LIGHTING PLAN
SCALE: 1:100

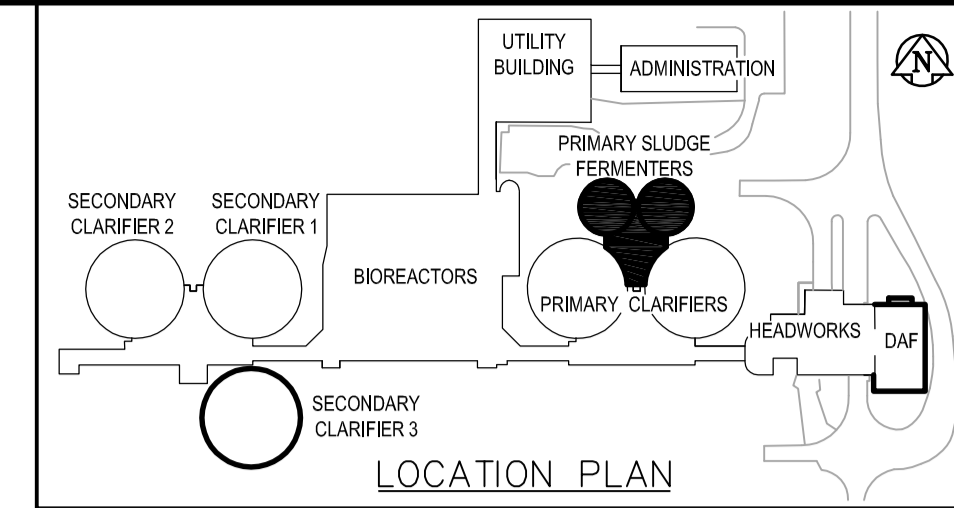

DRAWING NOTES

- ① COORDINATE LUMINAIRE CONNECTIONS WITH MECHANICAL PIPING AND DUCTWORK. WHERE REQUIRED SUSPEND LUMINAIRES BELOW SUCH EQUIPMENT.

GENERAL NOTES

- 1. COORDINATE WITH OTHER TRADES TO PREVENT CONFLICTS.
- 2. USE PVC JACKETED HITECK CABLE FOR ALL POWER WIRING.
- 3. WIRING FOR LIGHTING, RECEPTACLES AND COMMUNICATIONS TO IN RIGID ALUMINUM CONDUIT.
- 4. ALL CONDUIT TO BE 21mmØ MINIMUM UNLESS OTHERWISE NOTED.



B.M. ELEV.		EarthTech A Tyco International Ltd. Company		ENGINEER'S SEAL	
DESIGNED BY	GSN	CHECKED BY	PS	ORIGINAL SIGNED BY	P. STRYK
DRAWN BY	ERC	APPROVED BY	JEH	DATE	2006/04/26
HOR. SCALE: AS NOTED		RELEASED FOR CONSTRUCTION BY:		CONSULTANT DRAWING NO.	
VERTICAL SCALE:		J. VEILLEUX		FE1.01	
NO.	REVISIONS	DATE	BY	DATE	2005/11/22
01	21-2006 ADDENDUM 3	06/05/19	ERC	DATE	2006/04/26
00	ISSUED FOR TENDER	06/04/26	ERC		

THE CITY OF WINNIPEG
WATER AND WASTE DEPARTMENT
ENGINEERING DIVISION

WEWPC
BIOLOGICAL NUTRIENT REMOVAL UPGRADE
CONTRACT 3

ELECTRICAL
AREA F- PRIMARY SLUDGE FERMENTERS
LIGHTING AND SYSTEMS PLANS

CITY FILE NUMBER
SHEET OF
CITY DRAWING NUMBER