


MAIN FLOOR PLUMBING PLAN
SCALE: 1:50

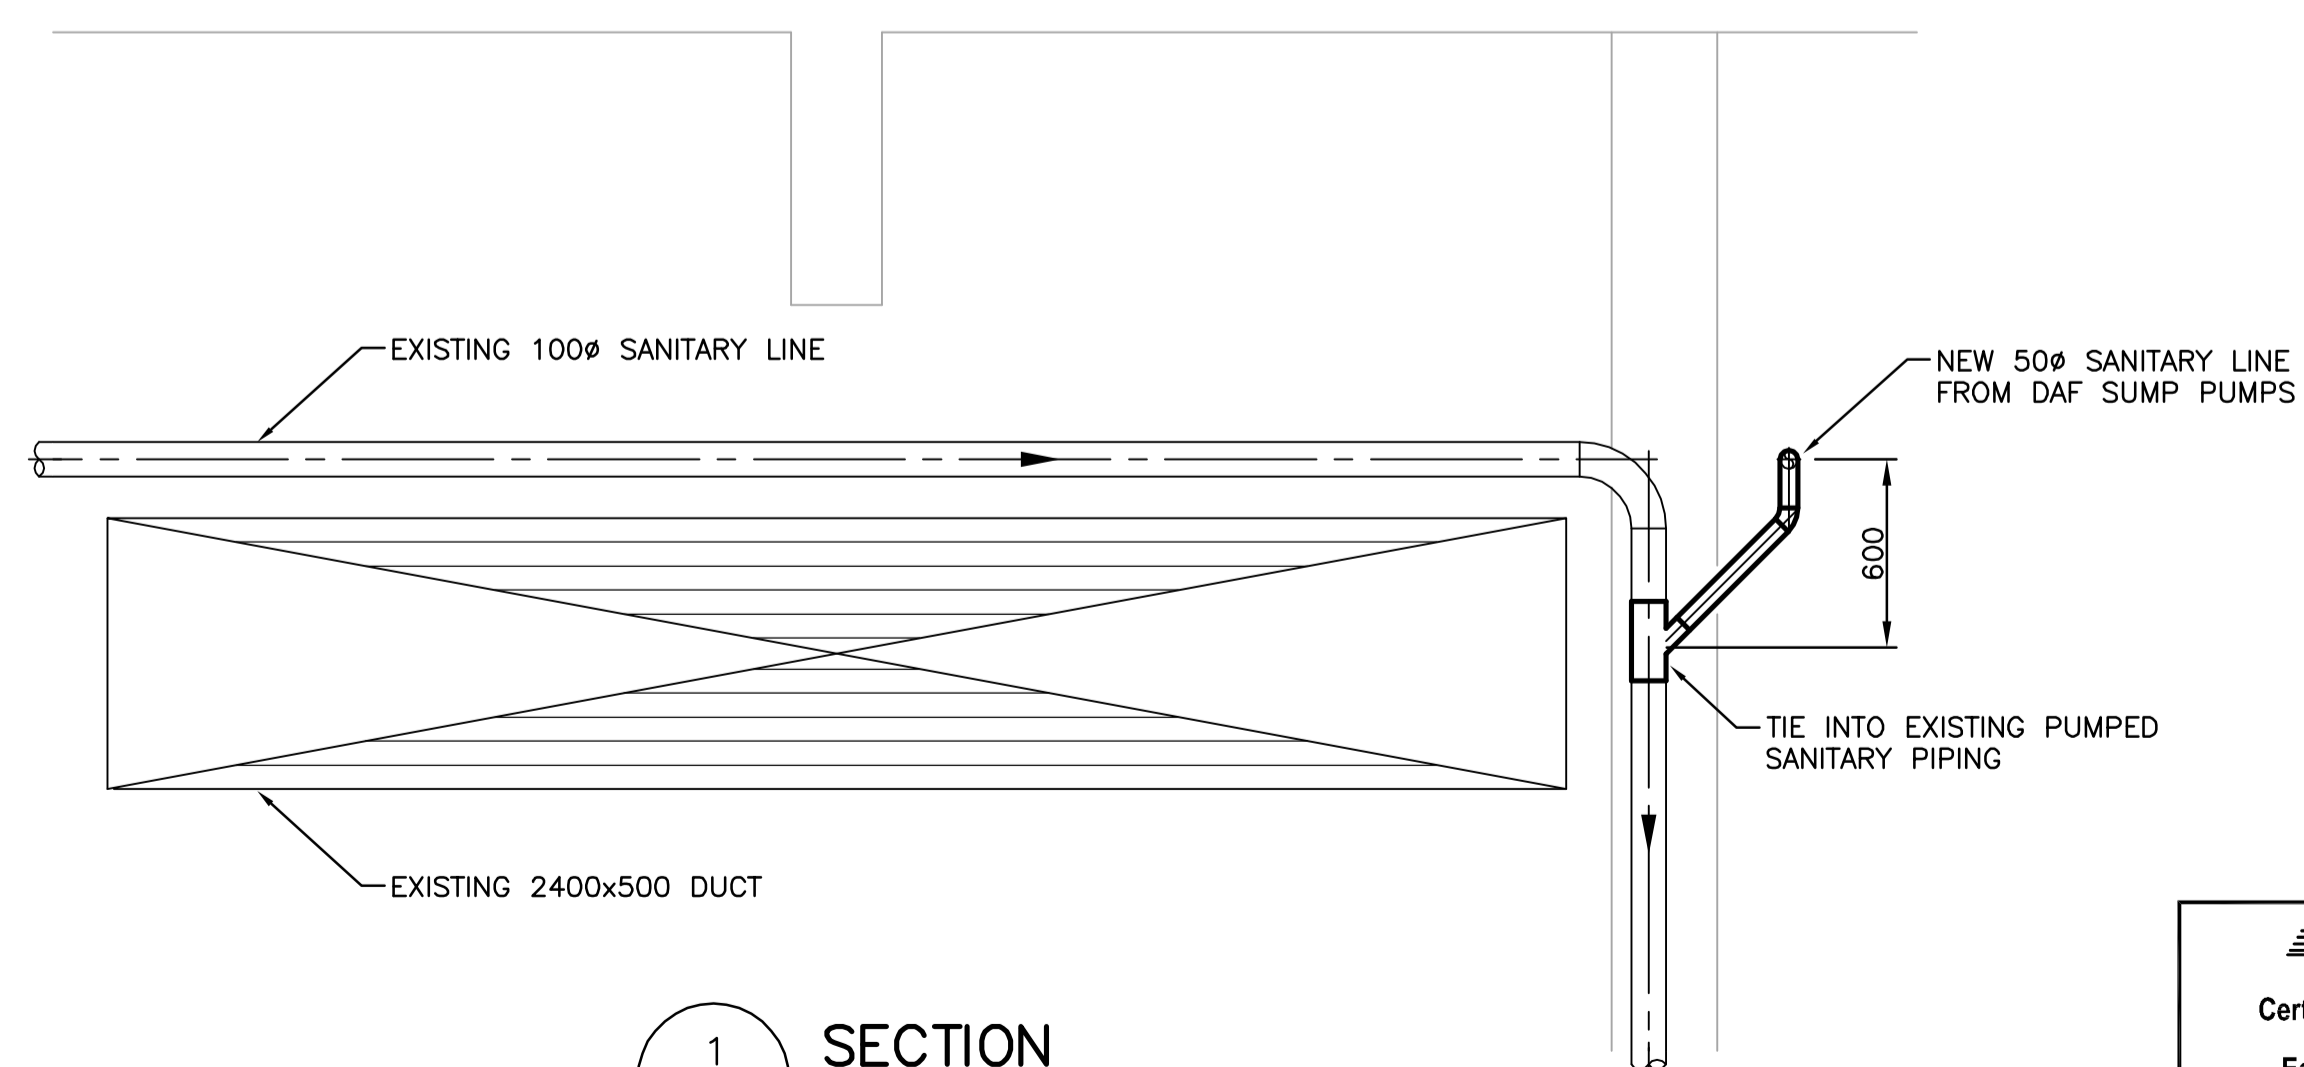

1 SECTION
HM1.01 SCALE 1:25



DRAWING NOTES

- ① 50 ϕ PS TO CONNECT INTO EXISTING 100 ϕ SANITARY RISER APPROXIMATELY 600m BELOW HORIZONTAL RUN. SEE SECTION.
- ② 50 ϕ PS SEE DRAWING TM1.01 FOR CONTINUATION.
- ③ EXISTING 100 ϕ SANITARY LINE FROM SUMP PUMPS LOCATED IN LOWER LEVEL OF HEADWORKS.

GENERAL NOTES

- 1. COORDINATE WITH OTHER TRADES SO AS TO PREVENT CONFLICTS.

B.M. ELEV. DESIGNED BY: PVL DRAWN BY: DL HOR. SCALE: AS NOTED VERTICAL SCALE: NO. REVISIONS DATE BY	EarthTech A Tyco International Ltd. Company		ENGINEER'S SEAL ORIGINAL SIGNED BY A. BURACHYNSKY 2006/04/26	THE CITY OF WINNIPEG WATER AND WASTE DEPARTMENT ENGINEERING DIVISION WEWPCC BIOLOGICAL NUTRIENT REMOVAL UPGRADE CONTRACT 3 MECHANICAL AREA H - HEADWORKS MAIN FLOOR PLUMBING PLAN	CITY FILE NUMBER
	CHECKED BY: PVL APPROVED BY: JEH RELEASED FOR CONSTRUCTION BY: J. VEILLEUX	CONSULTANT DRAWING NO. HM1.01	SHEET OF		
	DATE: 2006/01/04 DATE: 2006/04/26	CITY DRAWING NUMBER	CITY DRAWING NUMBER		
	00 ISSUED FOR TENDER 06/04/26 DC	CITY DRAWING NUMBER	CITY DRAWING NUMBER		