




1 WALL SECTION AT DOORS
SA3.01 1:10

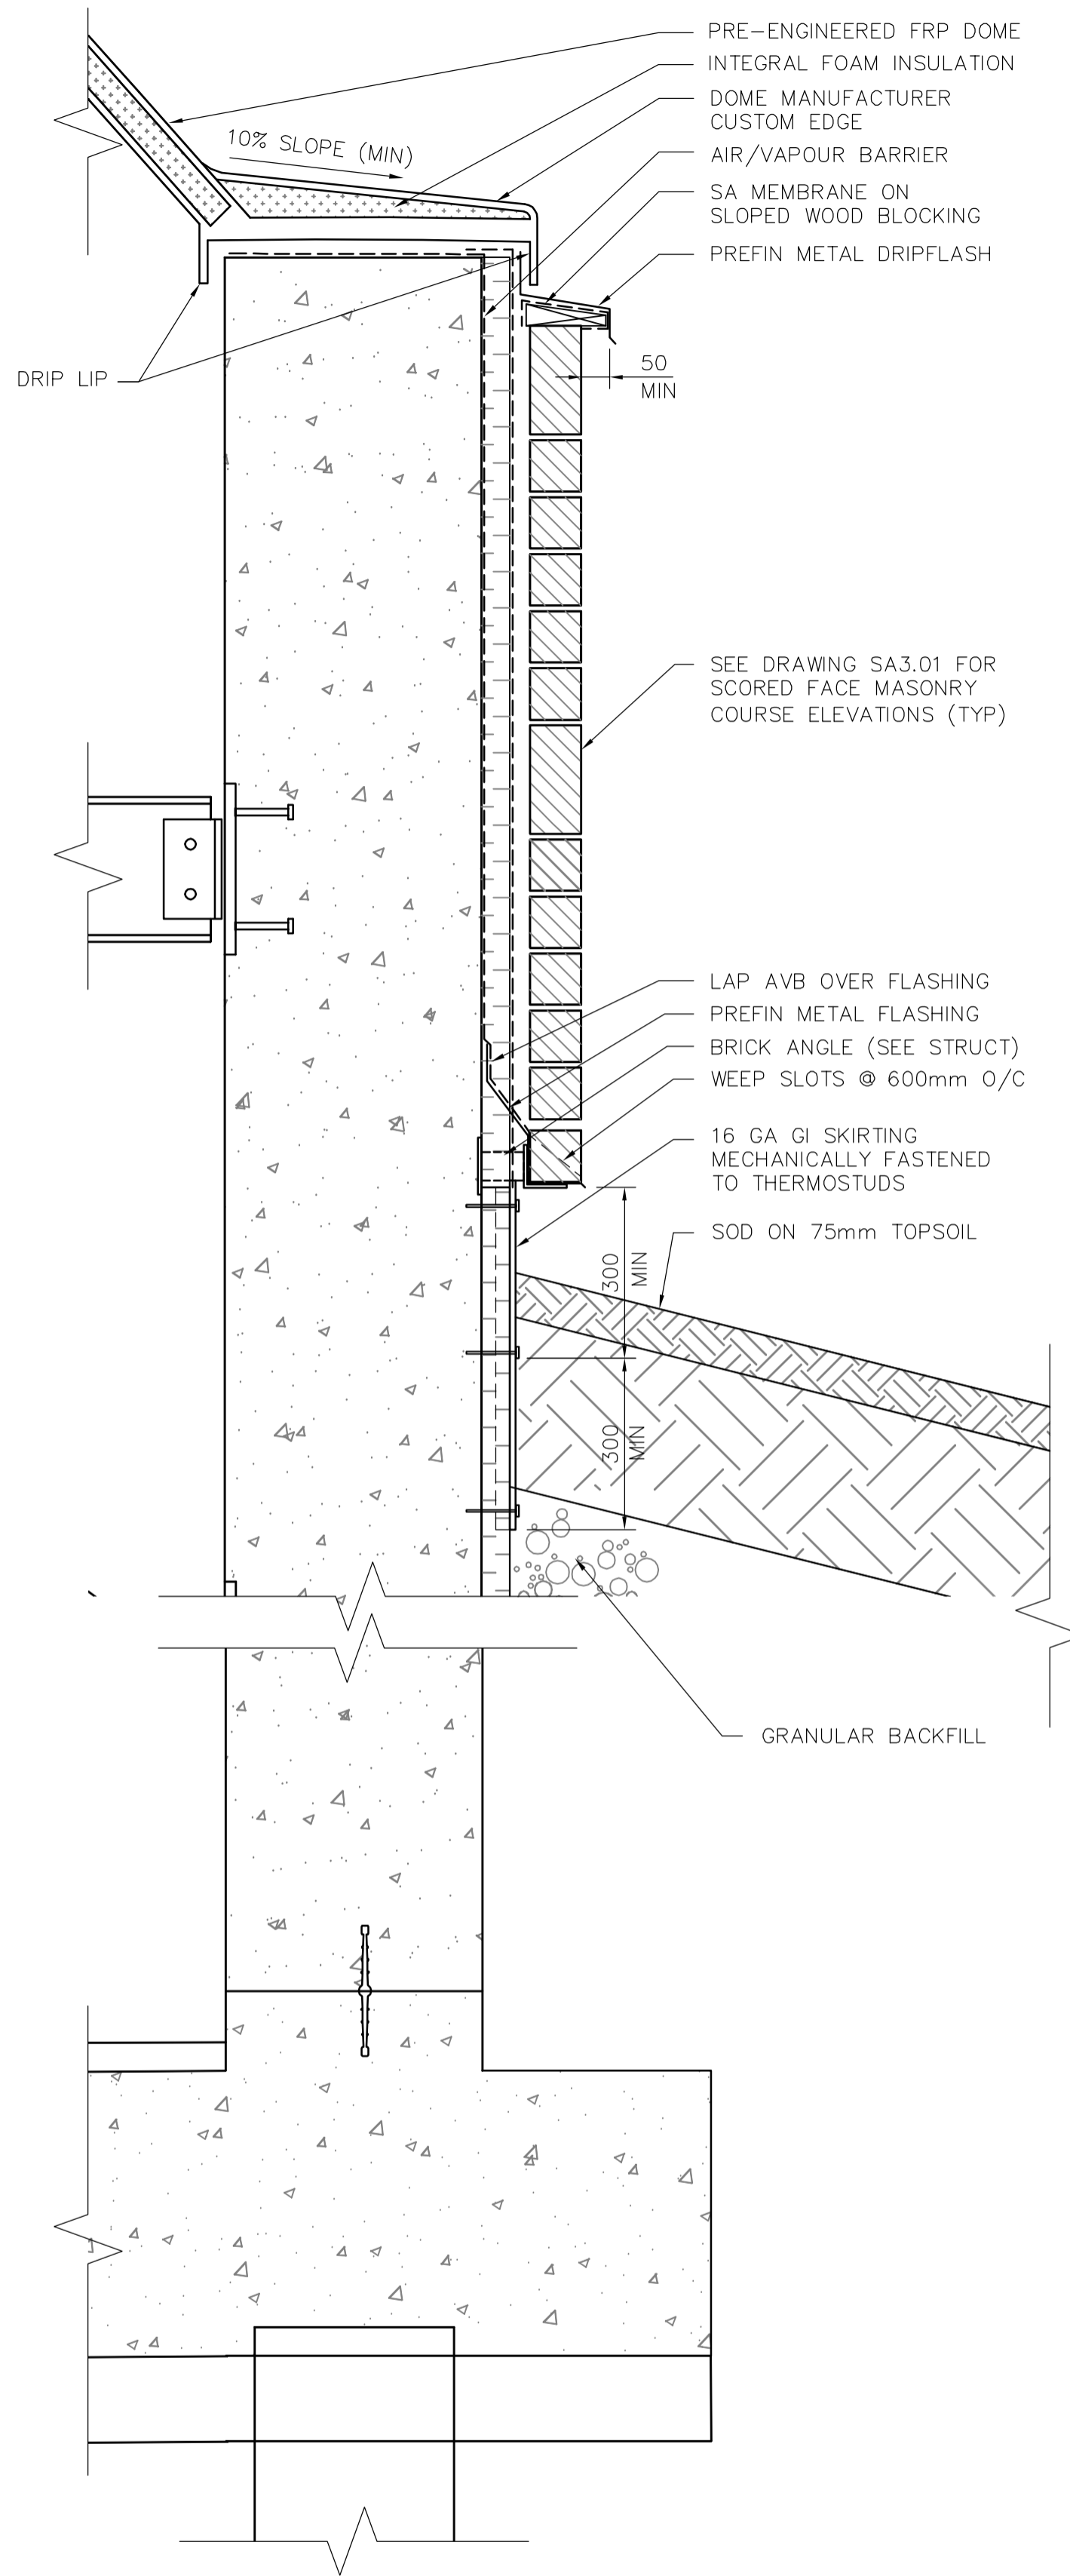


2 CLARIFIER WALL SECTION (TYP)
SA3.01 1:10

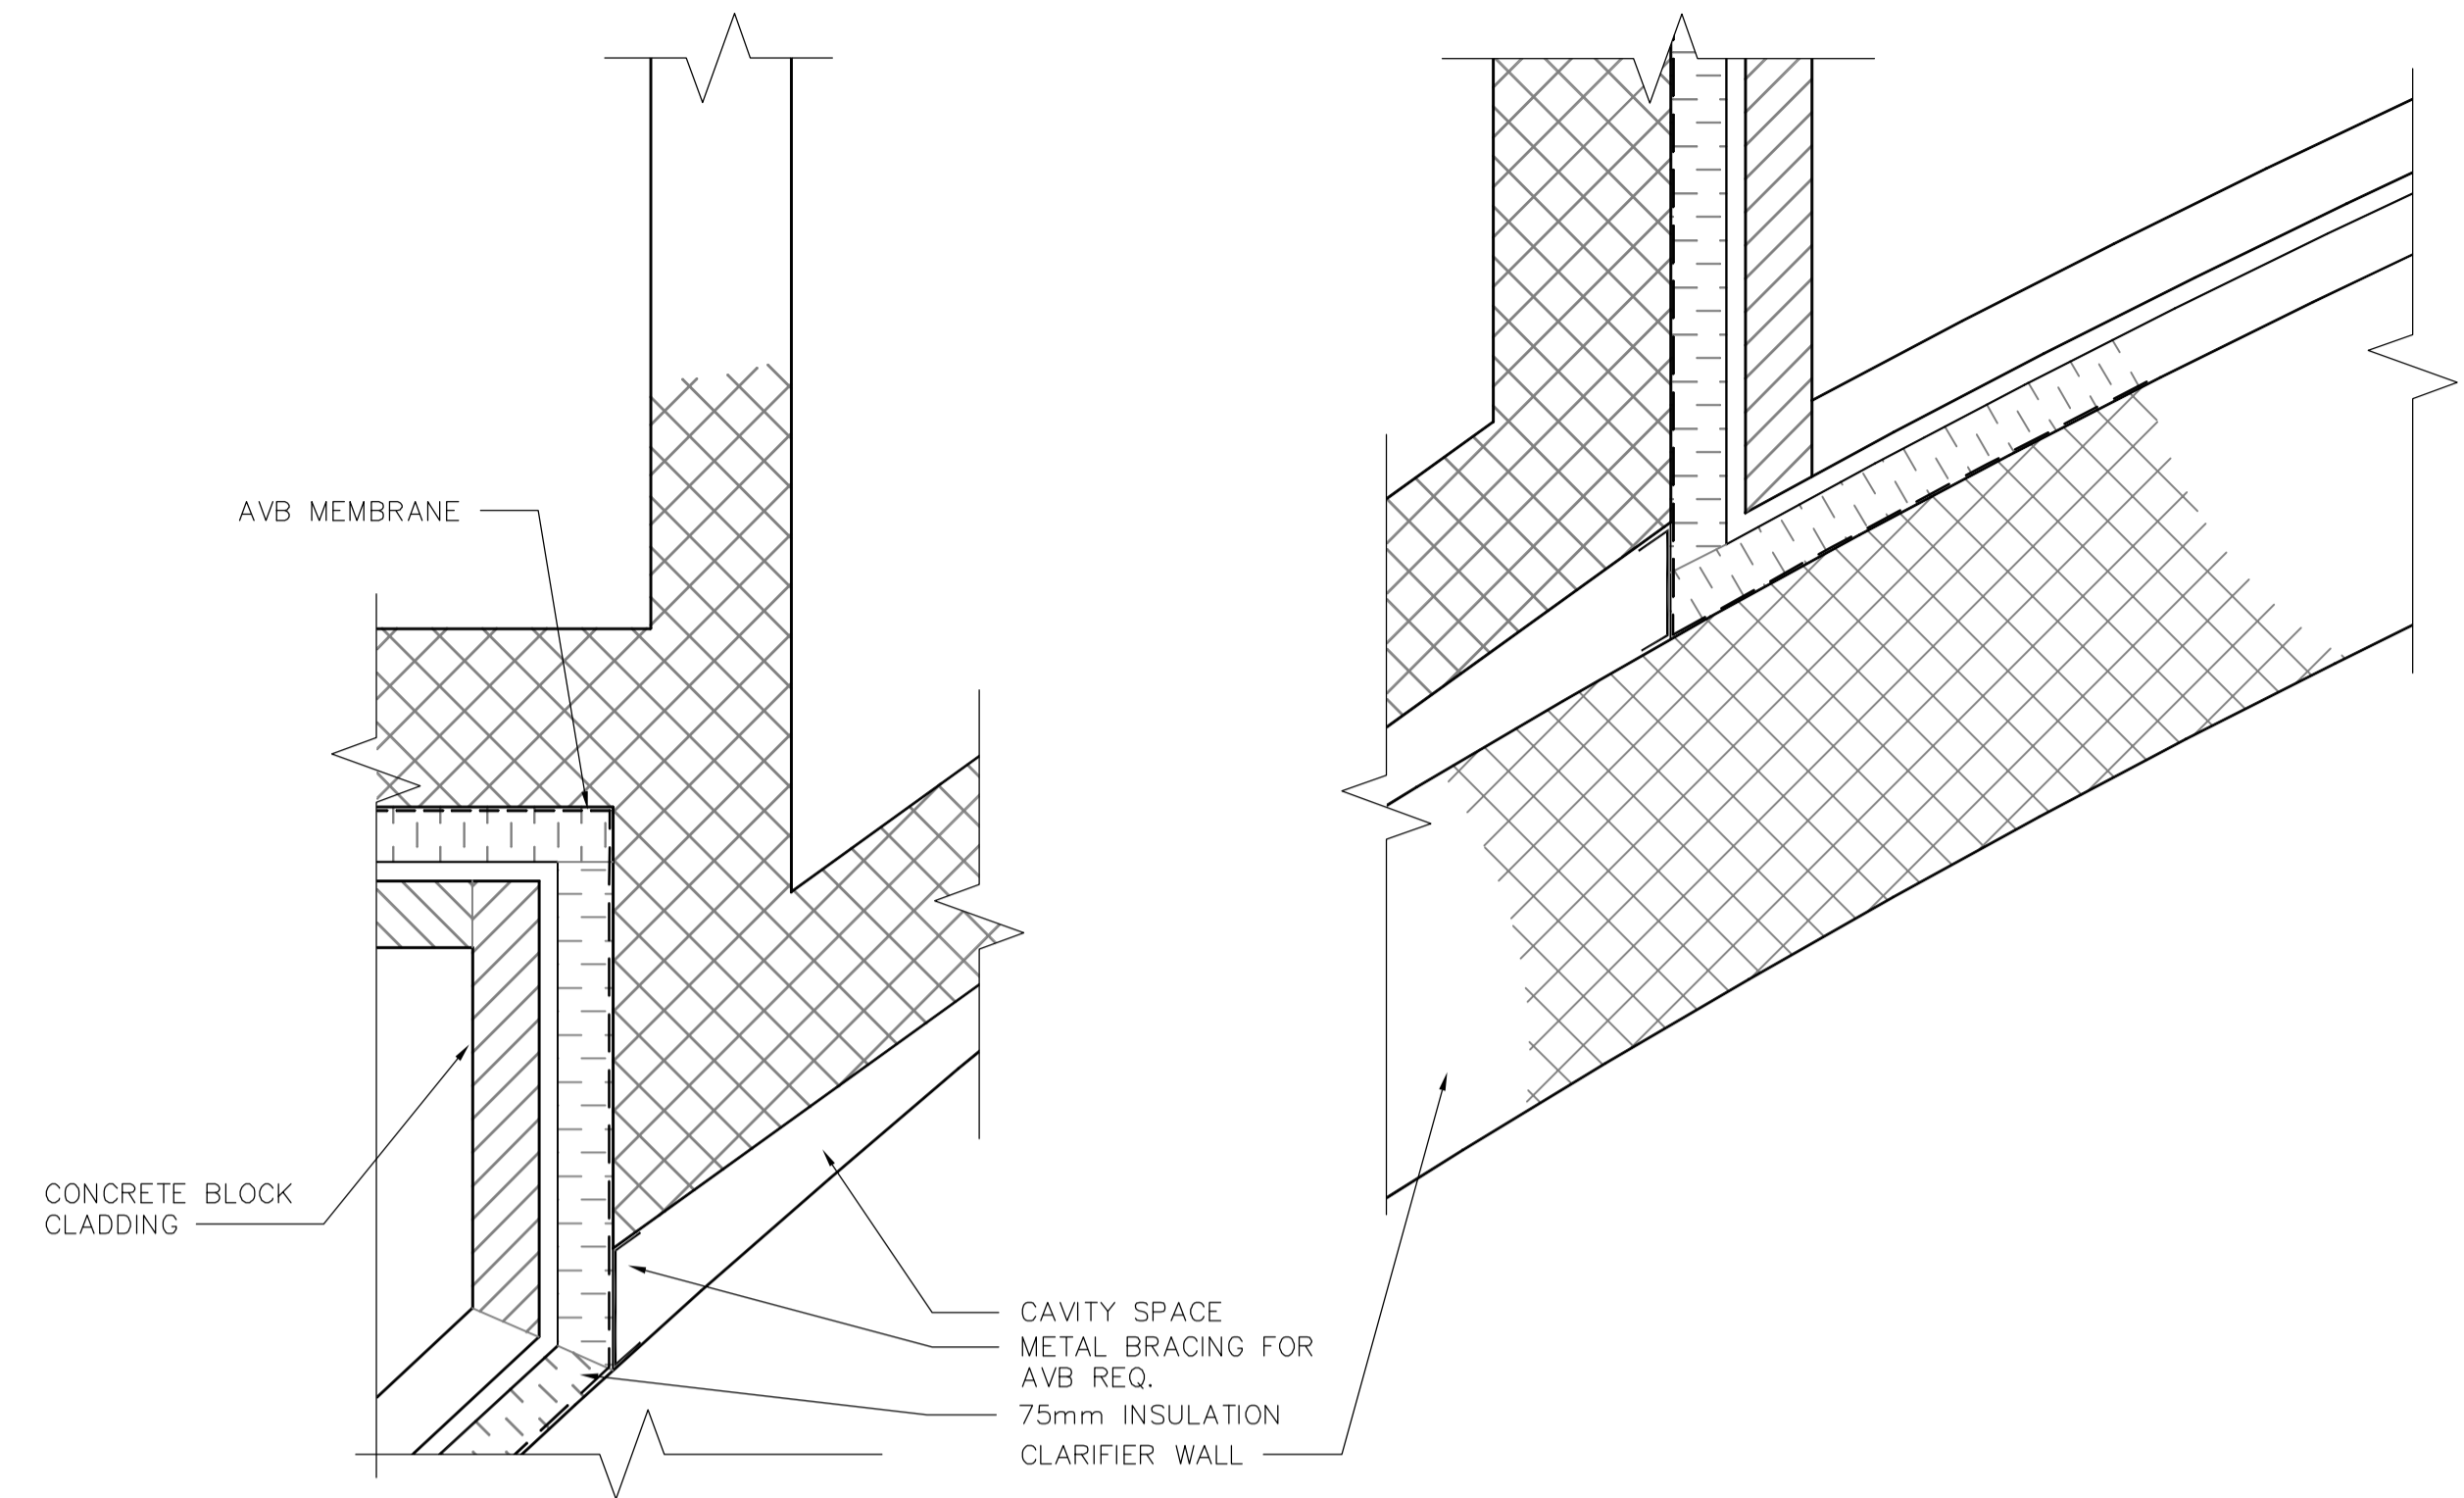

4 BUILDING TIE-IN PLAN DETAIL
SA1.02 1:10

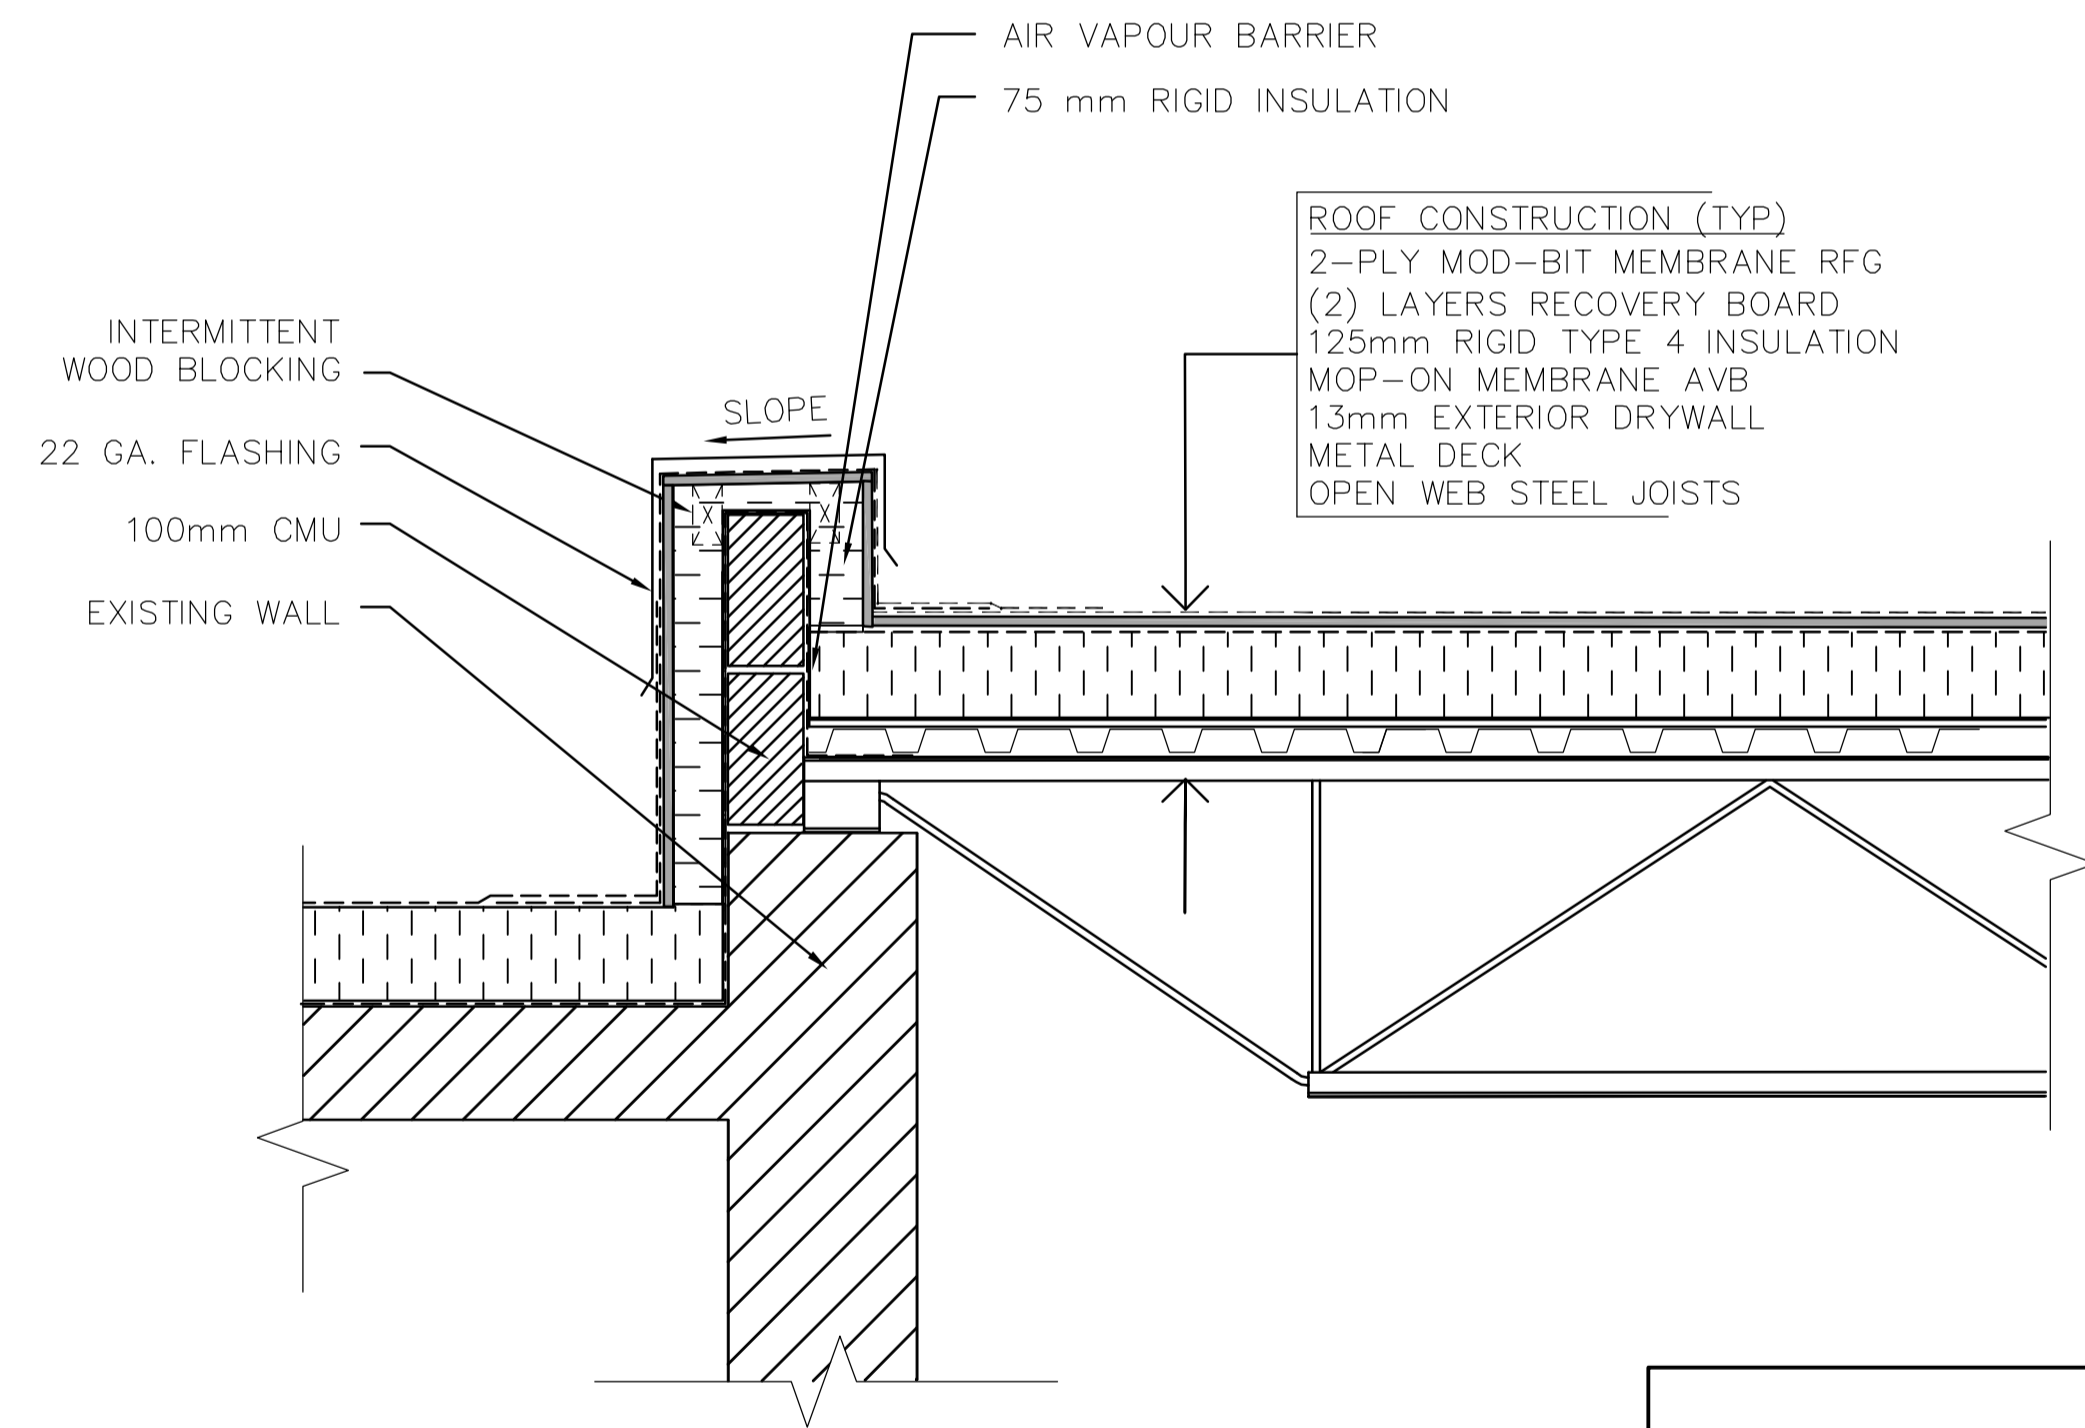

3 ROOF TIE-IN SECTION DETAIL
SA3.01 1:10

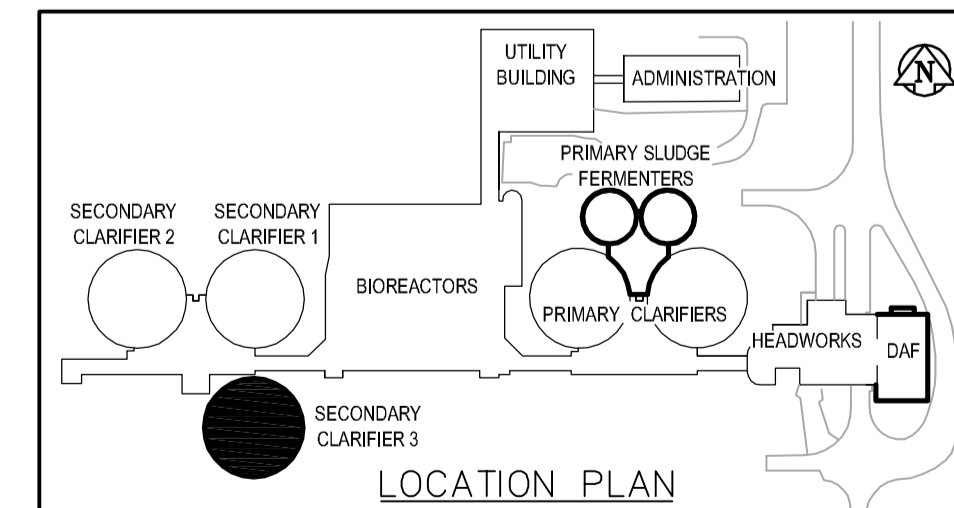

B.M. ELEV.					
DESIGNED BY	NC	CHECKED BY	NC	ENGINEER'S SEAL	
DRAWN BY	LK/AL	APPROVED BY	JEH	ORIGINAL SIGNED BY	N. COOPER
SCALE:	AS SHOWN	RELEASED FOR CONSTRUCTION BY:	J. VEILLEUX	2006/04/26	
00 ISSUED FOR TENDER	06/04/26	DATE	2006/02/26	DATE	2006/04/26
NO. REVISIONS		DATE		DATE	
				CONSULTANT DRAWING NO.	SA4.01

THE CITY OF WINNIPEG
WATER AND WASTE DEPARTMENT
ENGINEERING DIVISION

WEWPCC
BIOLOGICAL NUTRIENT REMOVAL UPGRADE
CONTRACT No. 3

ARCHITECTURAL
AREA S - SECONDARY CLARIFIER 3
SECTION AND DETAILS

CITY FILE NUMBER
SHEET 4 OF 4
CITY DRAWING NUMBER