



PROJECT: WINNIPEG WATER TREATMENT PLANT	CLENT: City of Winnipeg (Earth Tech)	TEST HOLE NO: 05-58
LOCATION: East Side of PR 207 South of Aqueduct Crossing N 5523944.7 E 648427.5	PROJECT NO. 3398-055-00-01	
CONTRACTOR: Paddock Drilling	METHOD: Acker SS, 125mm SSA	ELEVATION (m):
SAMPLE TYPE <input checked="" type="checkbox"/> GRAB <input type="checkbox"/> SHELBY TUBE <input checked="" type="checkbox"/> SPLIT SPOON <input type="checkbox"/> BULK <input type="checkbox"/> NO RECOVERY <input type="checkbox"/> CORE		

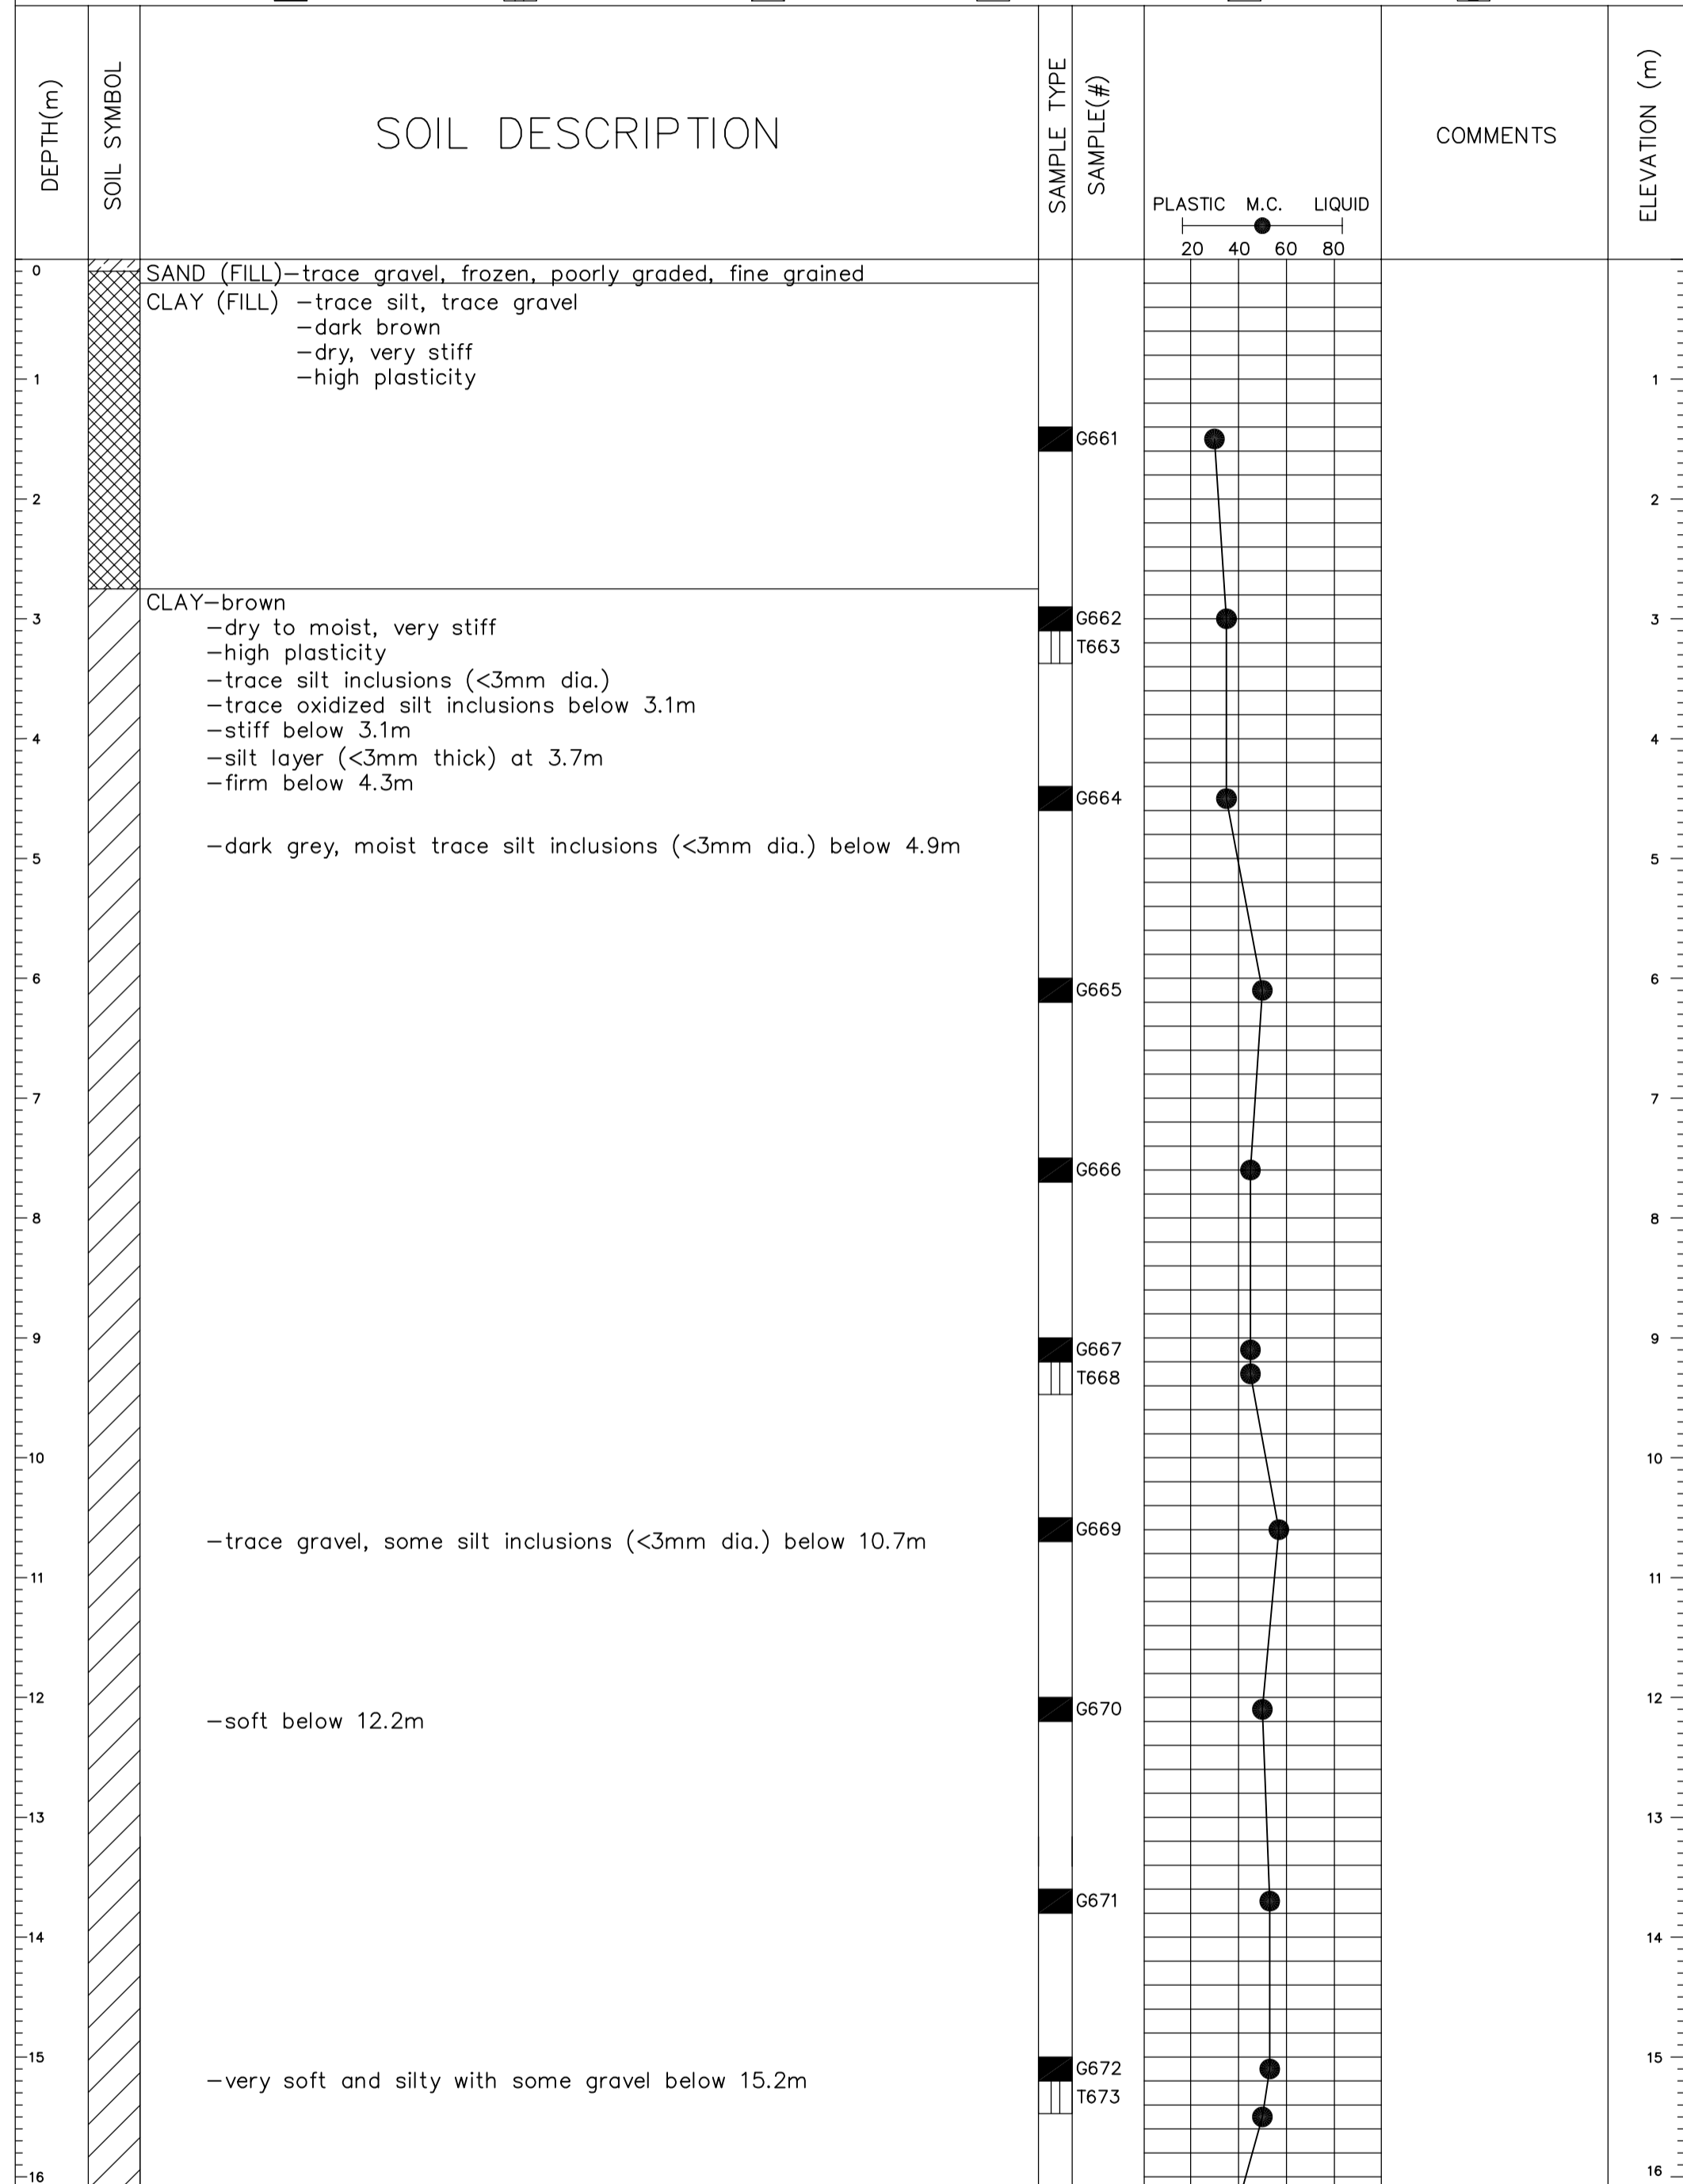

LOGGED BY: Andrea Hachkowski	COMPLETION DEPTH: 20.73m
REVIEWED BY: Nelson Ferreira	COMPLETION DATE: 1/18/06
PROJECT ENGINEER: Ken Skatfield	PAGE 1 of 2

PROJECT: WINNIPEG WATER TREATMENT PLANT	CLENT: City of Winnipeg (Earth Tech)	TEST HOLE NO: 05-58
LOCATION: East Side of PR 207 South of Aqueduct Crossing N 5523944.7 E 648427.5	PROJECT NO. 3398-055-00-01	
CONTRACTOR: Paddock Drilling	METHOD: Acker SS, 125mm SSA	ELEVATION (m):
SAMPLE TYPE <input checked="" type="checkbox"/> GRAB <input type="checkbox"/> SHELBY TUBE <input checked="" type="checkbox"/> SPLIT SPOON <input type="checkbox"/> BULK <input type="checkbox"/> NO RECOVERY <input type="checkbox"/> CORE		

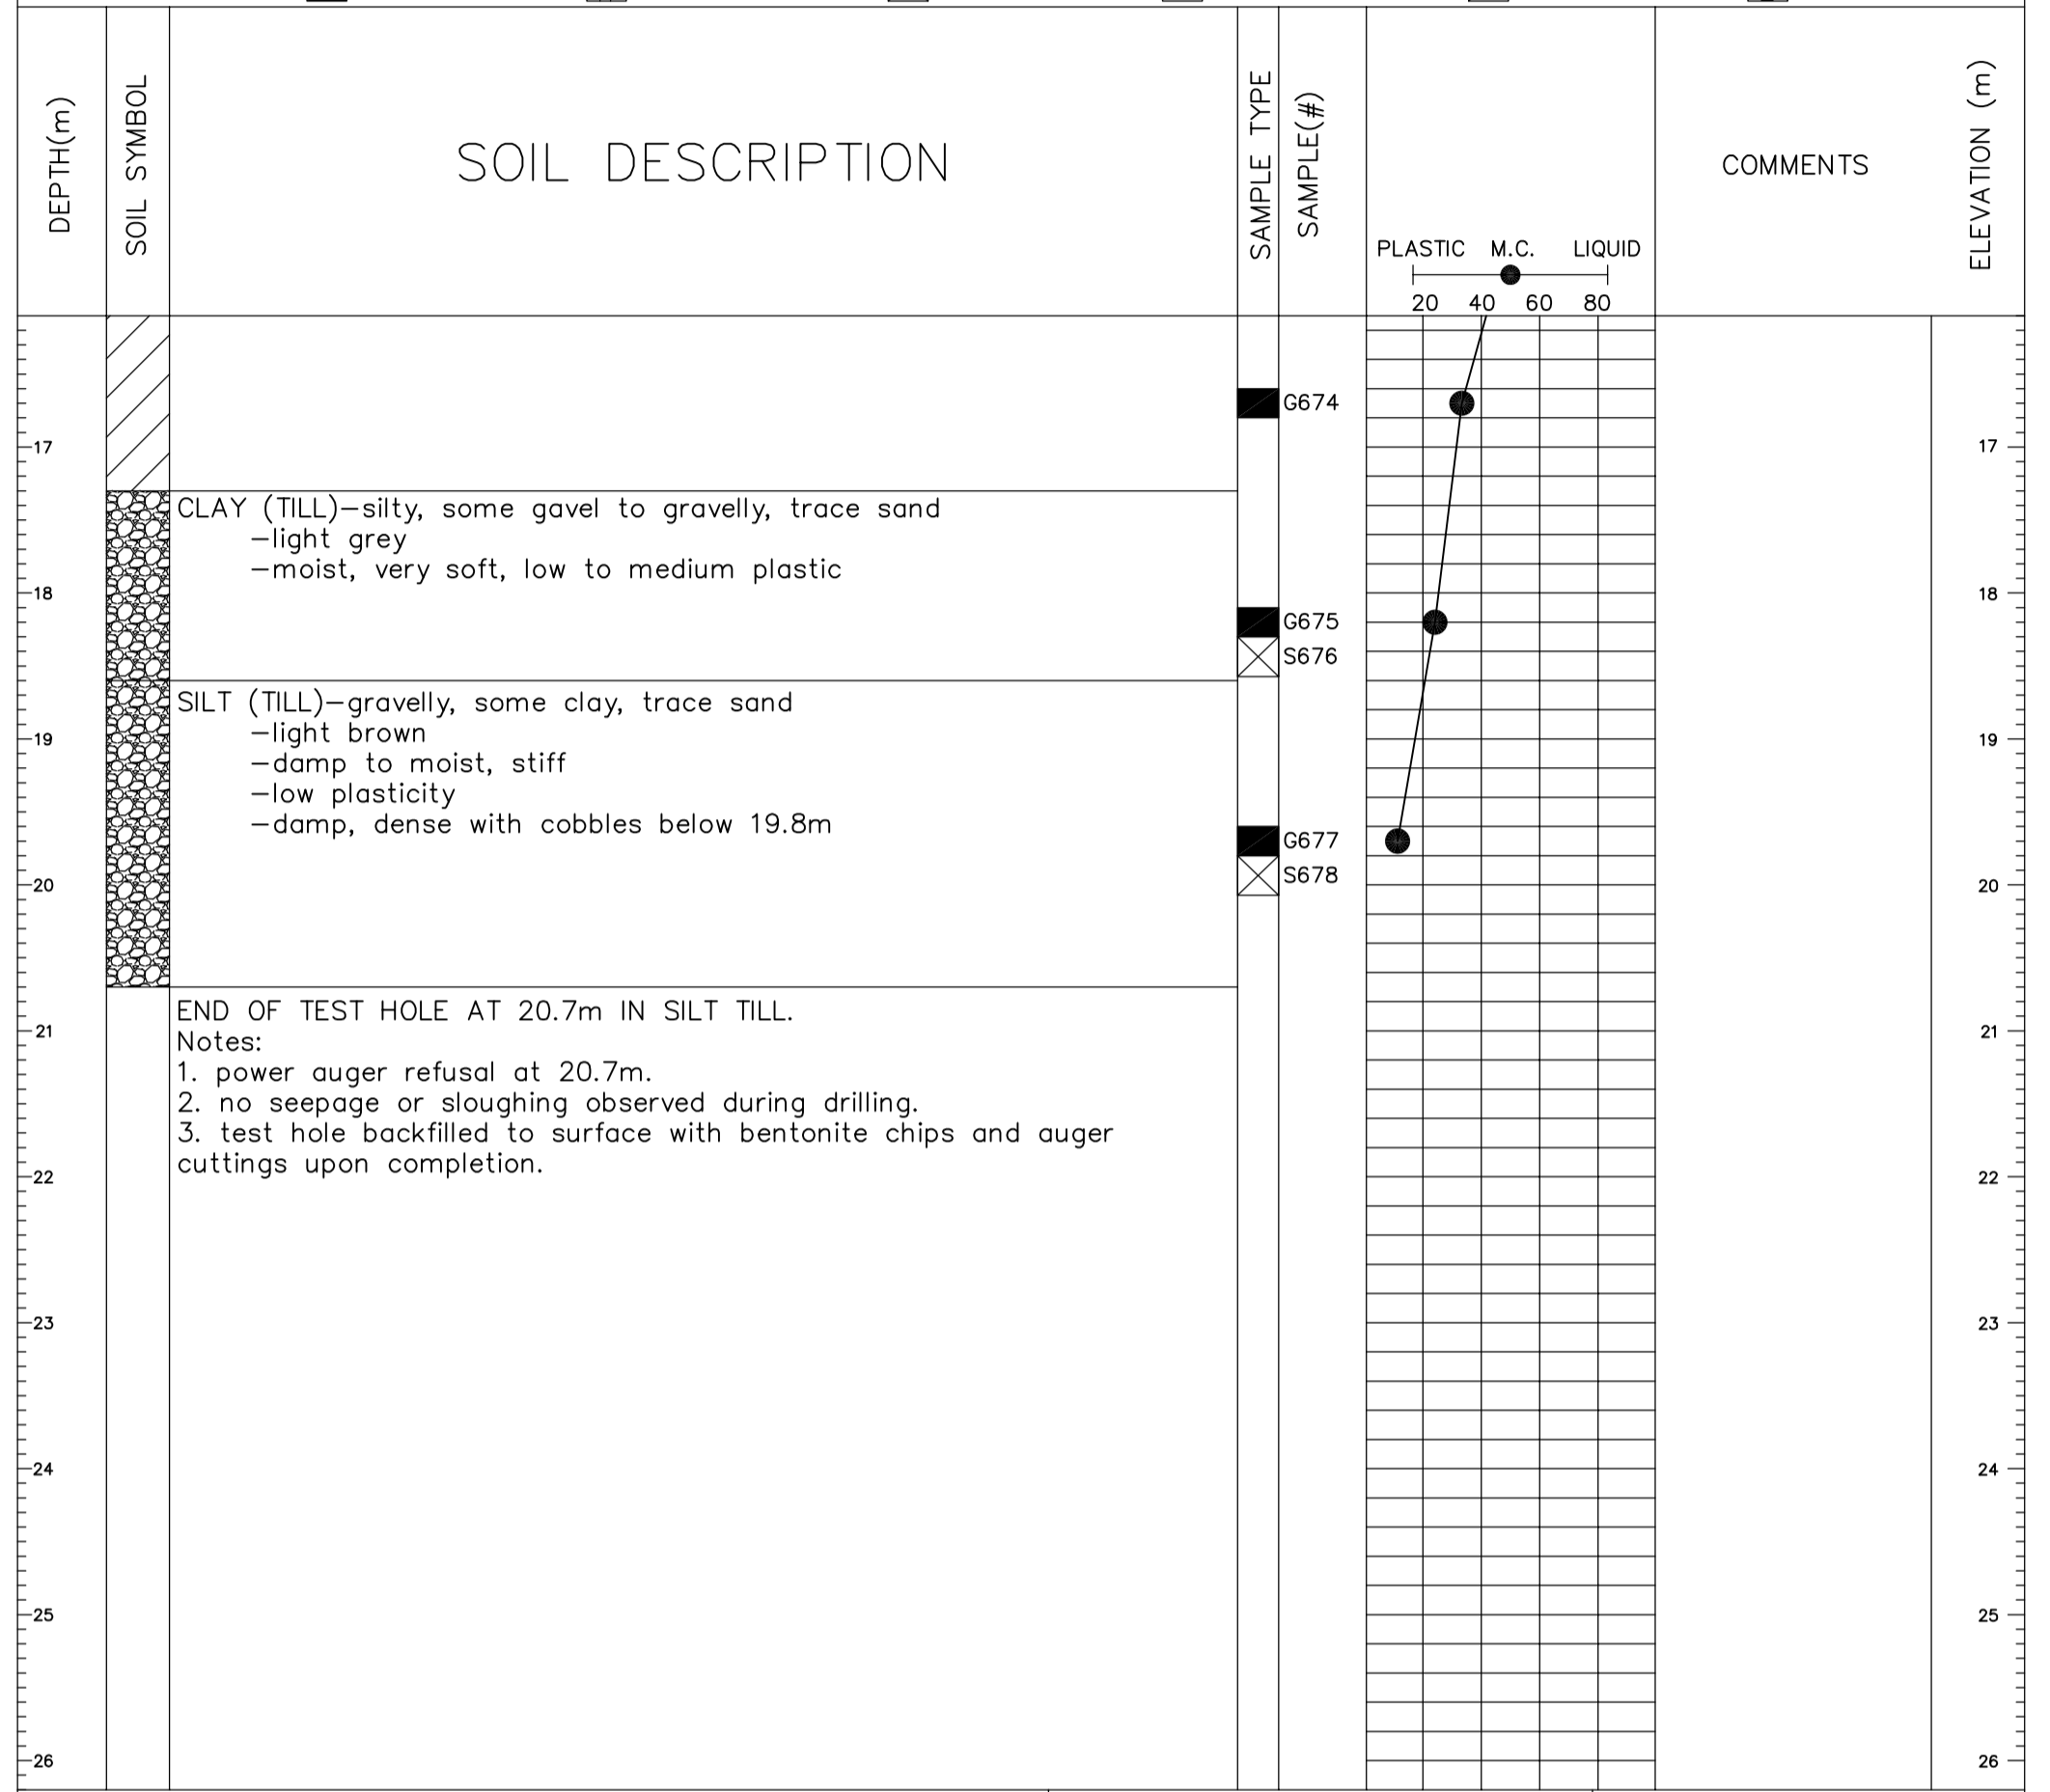

END OF TEST HOLE AT 20.7m IN SILT TILL.  
Notes:  
1. power auger refusal at 20.7m.  
2. no seepage or sloughing observed during drilling.  
3. test hole backfilled to surface with bentonite chips and auger cuttings upon completion.

LOGGED BY: Andrea Hachkowski	COMPLETION DEPTH: 20.73m
REVIEWED BY: Nelson Ferreira	COMPLETION DATE: 1/18/06
PROJECT ENGINEER: Ken Skatfield	PAGE 2 of 2

- NOTES:
- SEE SITE PLAN SHEET FOR THE LOCATION OF THIS BORING TEST HOLE.
  - SEE GEOTECHNICAL REPORT FOR BORING LOGS OF NEARBY TEST HOLES AND OTHER AVAILABLE SOIL INFORMATION.

Released to the City of Winnipeg for Tendering Purposes  
ORIGINAL SIGNED  
Eric Christiansen P.Eng.  
Director of Highway Planning & Design  
Manitoba Transportation & Government Services  
Date: MAY 16, 2006  
MTGS Plan No. 7161

<p>Certificate of Authorization Earth Tech Canada Inc. No. 730 Expiry: April 30, 2007</p>	<table border="1"> <tr> <th>B.M.</th> <th>ELEV.</th> </tr> <tr> <td> </td> <td> </td> </tr> <tr> <td> </td> <td> </td> </tr> <tr> <td> </td> <td> </td> </tr> </table>	B.M.	ELEV.							<p>Frederickson Cooper ARCHITECTS</p>	<p>A Terra International Ltd. Company</p>	<p>ENGINEER'S SEAL</p> <p>ORIGINAL SIGNED BY ASNEE POCHANART May 16, 2006</p> <p>CONSULTANT DRAWING NO. WN-S0152</p>	<p>THE CITY OF WINNIPEG WATER AND WASTE DEPARTMENT ENGINEERING DIVISION</p> <p>WINNIPEG WATER TREATMENT PROGRAM - PROVINCIAL ROAD #207 UPGRADE</p> <p>STRUCTURAL PR #207 BRIDGE BOREHOLE LOGS</p>	<p>CITY FILE NUMBER</p> <p>SHEET OF</p> <p>CITY DRAWING NUMBER</p> <p>1-0601N-A-80152-001-00D</p>						
		B.M.	ELEV.																	
<table border="1"> <tr> <td>DESIGNED BY</td> <td>AP</td> <td>CHECKED BY</td> <td>EBL</td> </tr> <tr> <td>DRAWN BY</td> <td>KC</td> <td>APPROVED BY</td> <td>AHL</td> </tr> <tr> <td>SCALE:</td> <td>AS NOTED</td> <td>RELEASED FOR CONSTRUCTION BY:</td> <td>R. SOROKOWSKI</td> </tr> <tr> <td>NO. REVISIONS</td> <td>DATE</td> <td>DATE</td> <td>DATE</td> </tr> <tr> <td>00</td> <td>ISSUED FOR TENDER 06/05/16</td> <td>KC</td> <td>2006/04/07</td> </tr> </table>	DESIGNED BY	AP	CHECKED BY	EBL	DRAWN BY	KC	APPROVED BY	AHL	SCALE:	AS NOTED	RELEASED FOR CONSTRUCTION BY:	R. SOROKOWSKI	NO. REVISIONS	DATE	DATE	DATE	00	ISSUED FOR TENDER 06/05/16	KC	2006/04/07
DESIGNED BY	AP	CHECKED BY	EBL																	
DRAWN BY	KC	APPROVED BY	AHL																	
SCALE:	AS NOTED	RELEASED FOR CONSTRUCTION BY:	R. SOROKOWSKI																	
NO. REVISIONS	DATE	DATE	DATE																	
00	ISSUED FOR TENDER 06/05/16	KC	2006/04/07																	