




D SIZE 22" x 34" (559mm x 864mm)

PLOT: 6/29/2006 9:35:39 AM


UMA FILE NAME: 0265-378-00_01-E-1001_RX.dwg Saved By: cjt

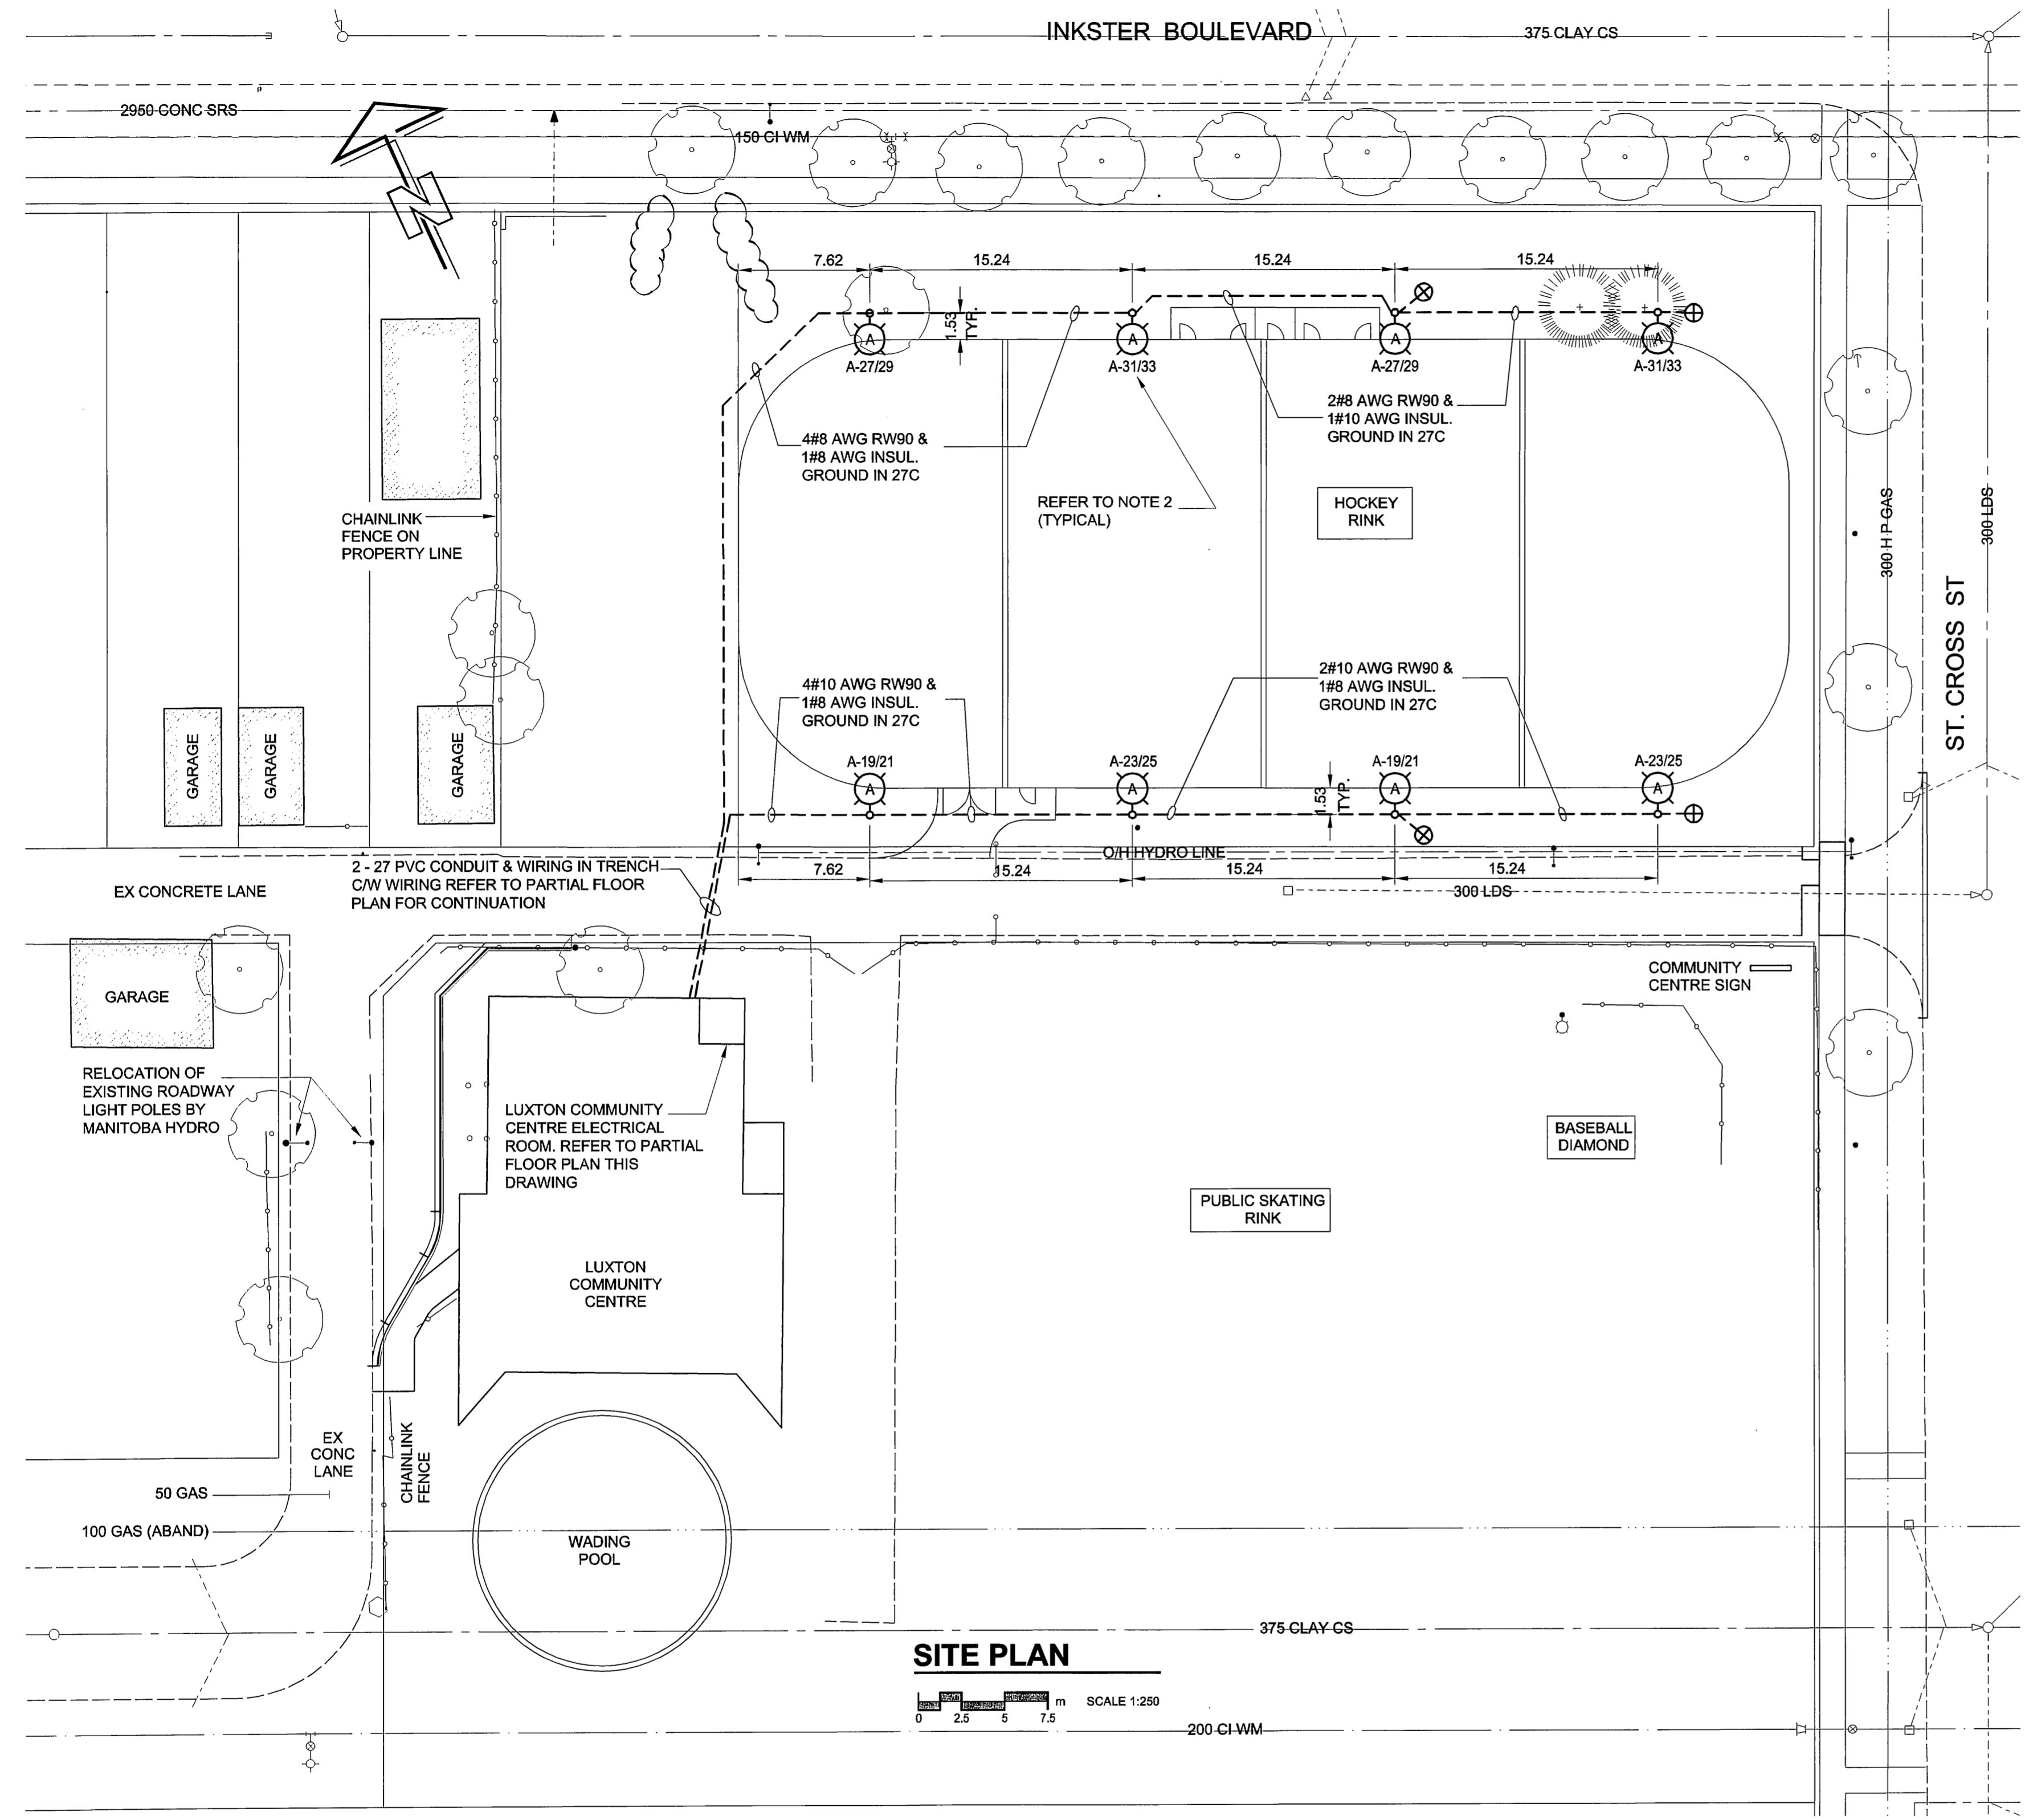

 SITE PLAN

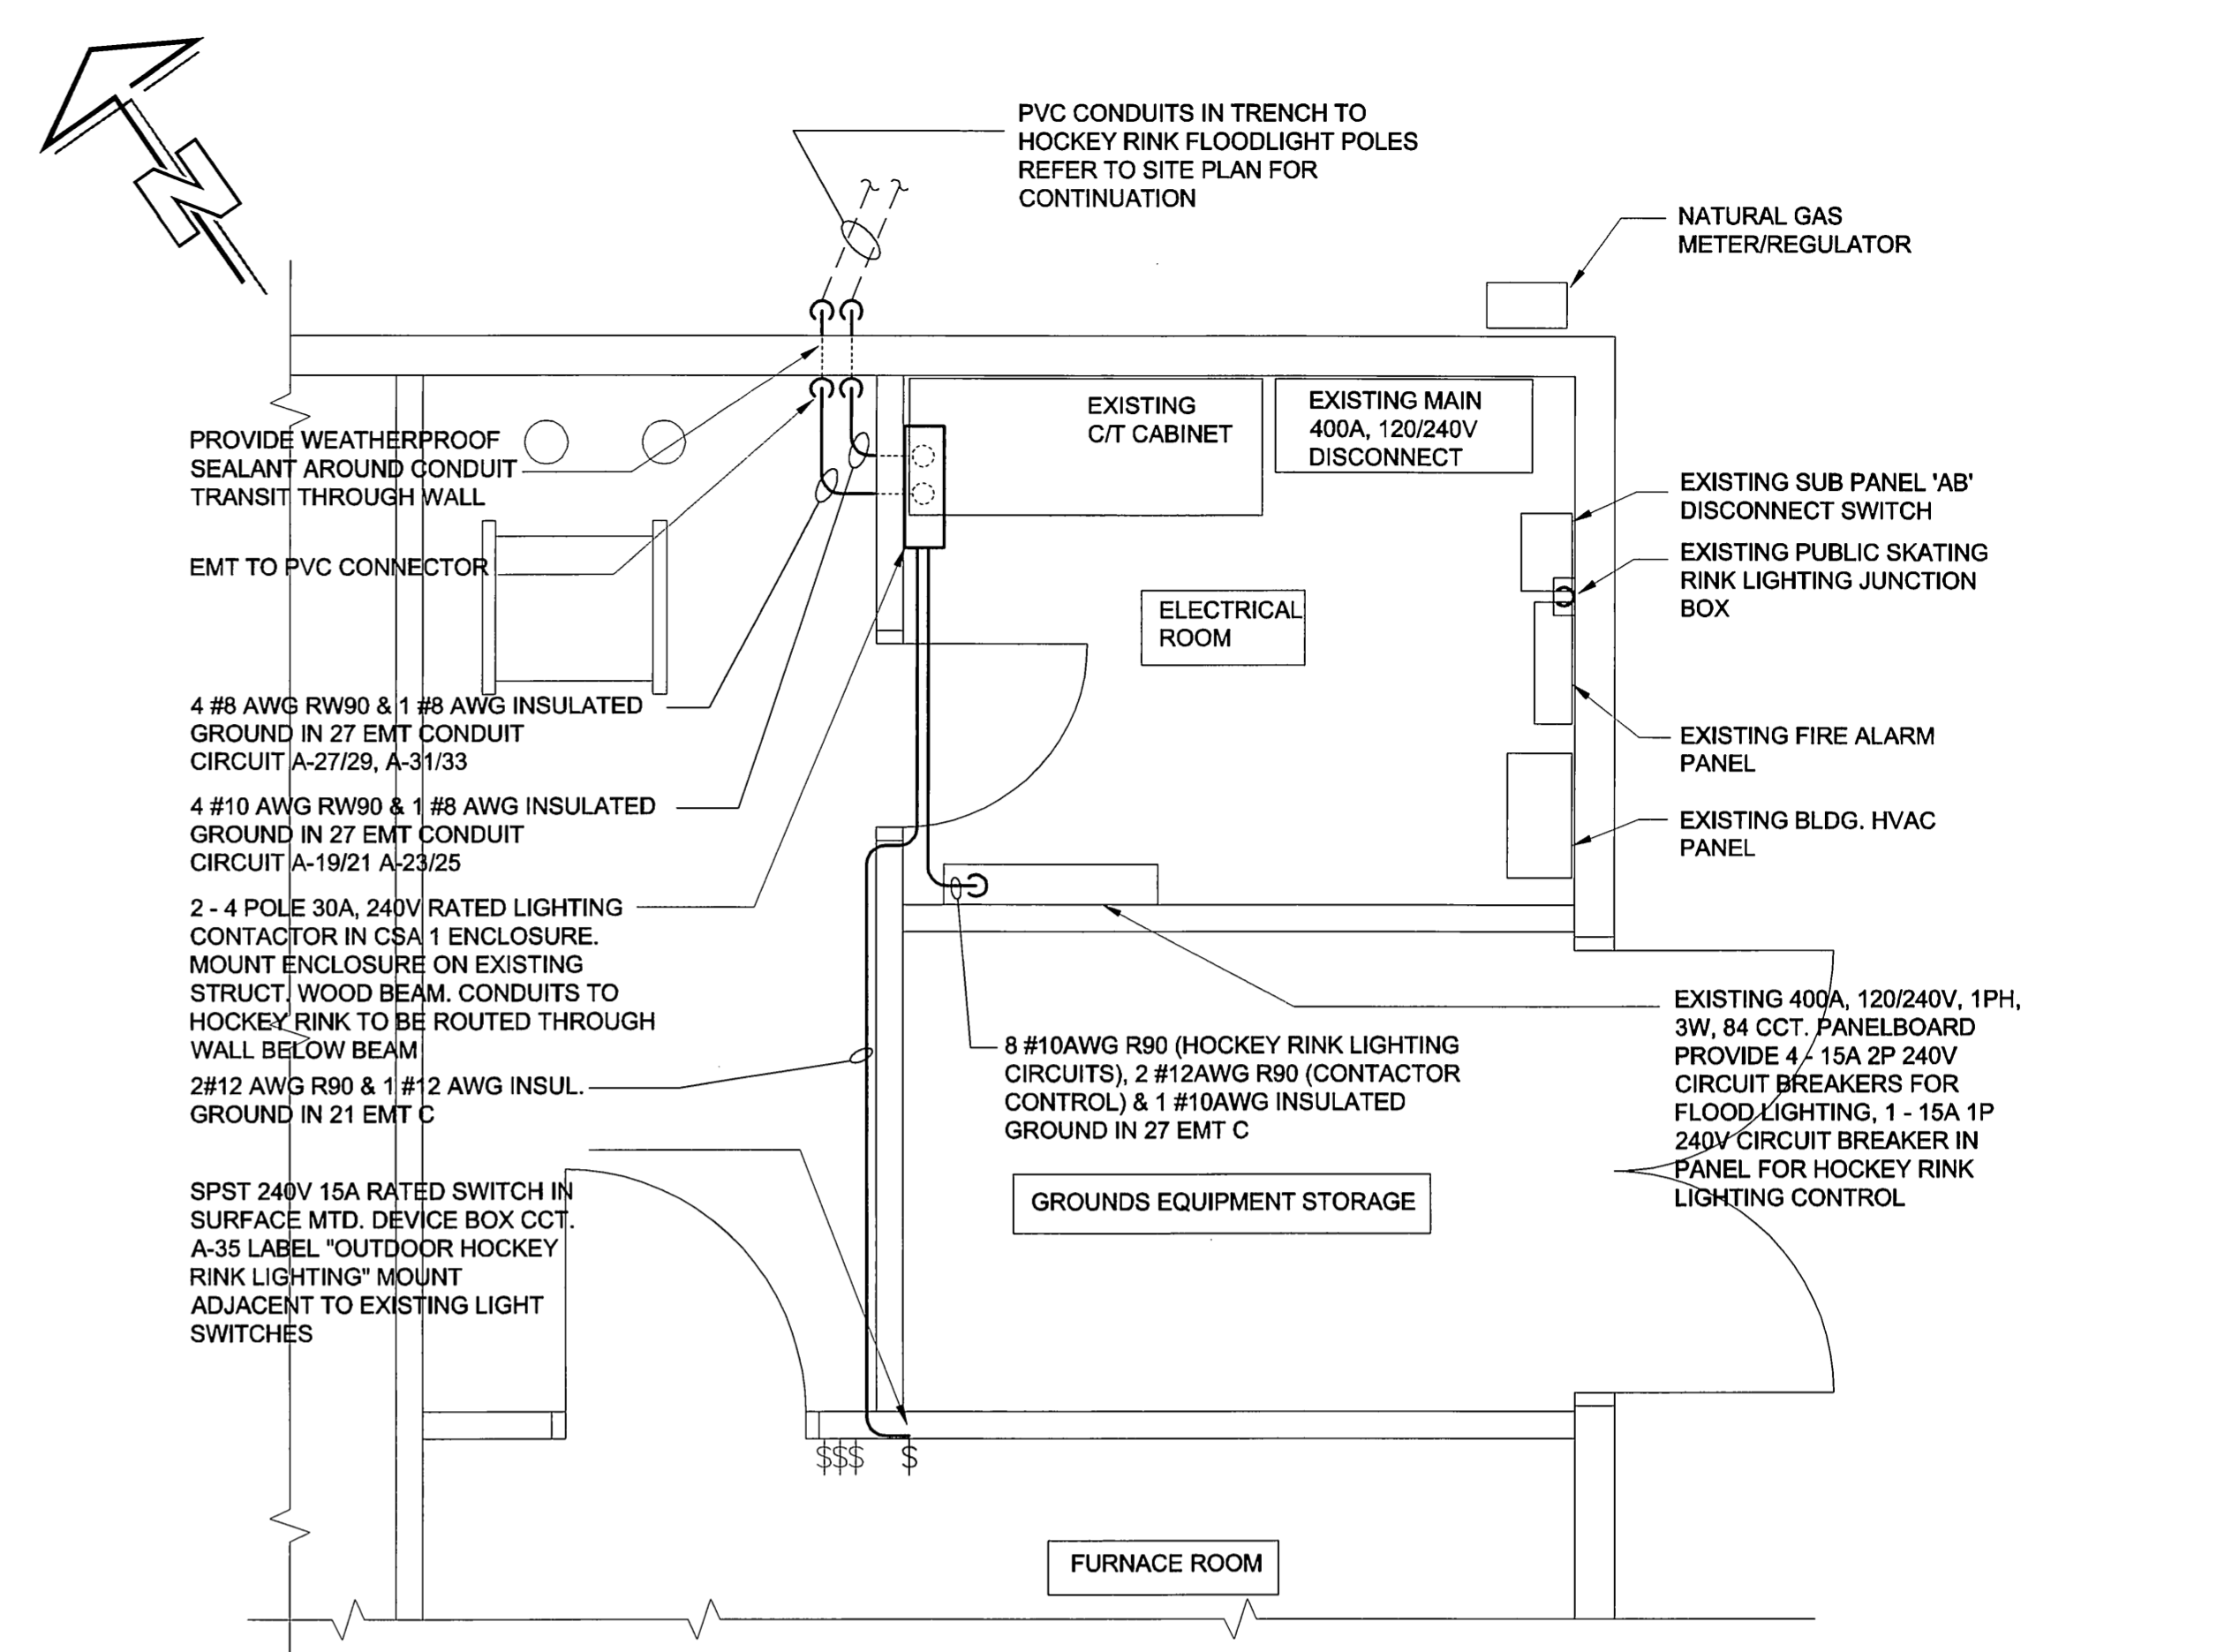

PARTIAL FLOOR PLAN

 

NOTES

- REFER TO DRAWINGS CS-1 TO CS-6 FOR ELECTRICAL WORK DESCRIPTION, LIGHT POLE SYSTEMS, LIGHTING POLE CONCRETE BASES AND TRENCH DETAIL.
- CONTRACTOR TO SUBMIT FLOOD LIGHT SHOP DRAWINGS C/W LIGHTING LEVELS FOR HOCKEY RINK AREA INCLUDING AIMING ANGLES. FLOOD LIGHTS TO BE INSTALLED AND AIMED AS PER SUBMITTED AND APPROVED SHOP DRAWINGS. ALLOW FOR ENGINEER AND CITY OF WINNIPEG REPRESENTATIVE TO WITNESS FINAL INSTALLATION, START UP AND FINAL ADJUSTMENTS OF FLOOD LIGHT AIMING DURING DARK SKY CONDITIONS.

LEGEND

- EXISTING LIGHT STANDARD
- EXISTING HYDRO POLE
- NEW POLE MOUNTED FLOOD LIGHT
- A-27/29 20mm Ø X 3m LONG COPPER CLAD GROUND ROD C/W BARE #8 AWG COPPER GROUND CONDUCTOR TO FLOODLIGHT POLE GROUND LUG & CIRCUIT GROUND
- PVC CONDUIT & CABLING IN TRENCH


LOCATION APPROVED UNDERGROUND STRUCTURES

SUPR. U/G STRUCTURES	DATE	COMMITTEE
NOTE: LOCATION OF UNDERGROUND STRUCTURES AS SHOWN ARE BASED ON THE BEST INFORMATION AVAILABLE. BUT NO GUARANTEE IS GIVEN THAT ALL EXISTING UTILITIES ARE SHOWN OR THAT THE GIVEN LOCATIONS ARE EXACT. CONFIRMATION OF EXISTENCE AND EXACT LOCATION OF ALL SERVICES MUST BE OBTAINED FROM THE INDIVIDUAL UTILITIES BEFORE PROCEEDING WITH CONSTRUCTION.		
B	REVISED AS PER CITY COMMENTS	06/08/29
A	ISSUED FOR BID	08/05/17 WJD
NO.	REVISIONS	YYMMDD BY

DESIGNED BY	SCK	CHECKED BY	
DRAWN BY	SCK	APPROVED BY	<i>[Signature]</i>
HOR. SCALE	AS NOTED	RELEASED FOR CONSTRUCTION	
VERT. SCALE			
DATE	06/29/29	DATE	

UMA | AECOM

©2006 UMA ENGINEERING LTD. ALL RIGHTS RESERVED.

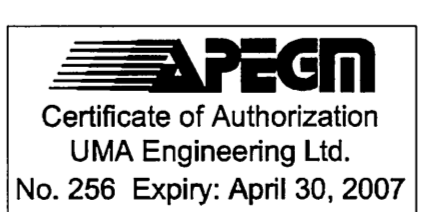

PROFESSIONAL'S SEAL
 CERTIFICATE OF AUTHORIZATION
 UMA Engineering Ltd.
 No. 256 Expiry: April 30, 2007

THE CITY OF WINNIPEG PUBLIC WORKS DEPARTMENT

LUXTON COMMUNITY CENTRE SITE DEVELOPMENT PROJECT
 Luxton / St. John's Park / Seven Oaks

Building Communities Initiative Plan
 ELECTRICAL - PLANS AND DETAILS

CITY DRAWING NUMBER
 SHEET 1 OF 1
 REV B

TENDER NO. 225-2006