




THE CITY OF WINNIPEG

PUBLIC WORKS DEPARTMENT
ENGINEERING DIVISION

KENASTON UNDERPASS PROJECT BID OPPORTUNITY No. 23-2006

KENASTON BOULEVARD RECONSTRUCTION ROAD WORKS, LDS AND MISCELLANEOUS UNDERGROUND WORKS

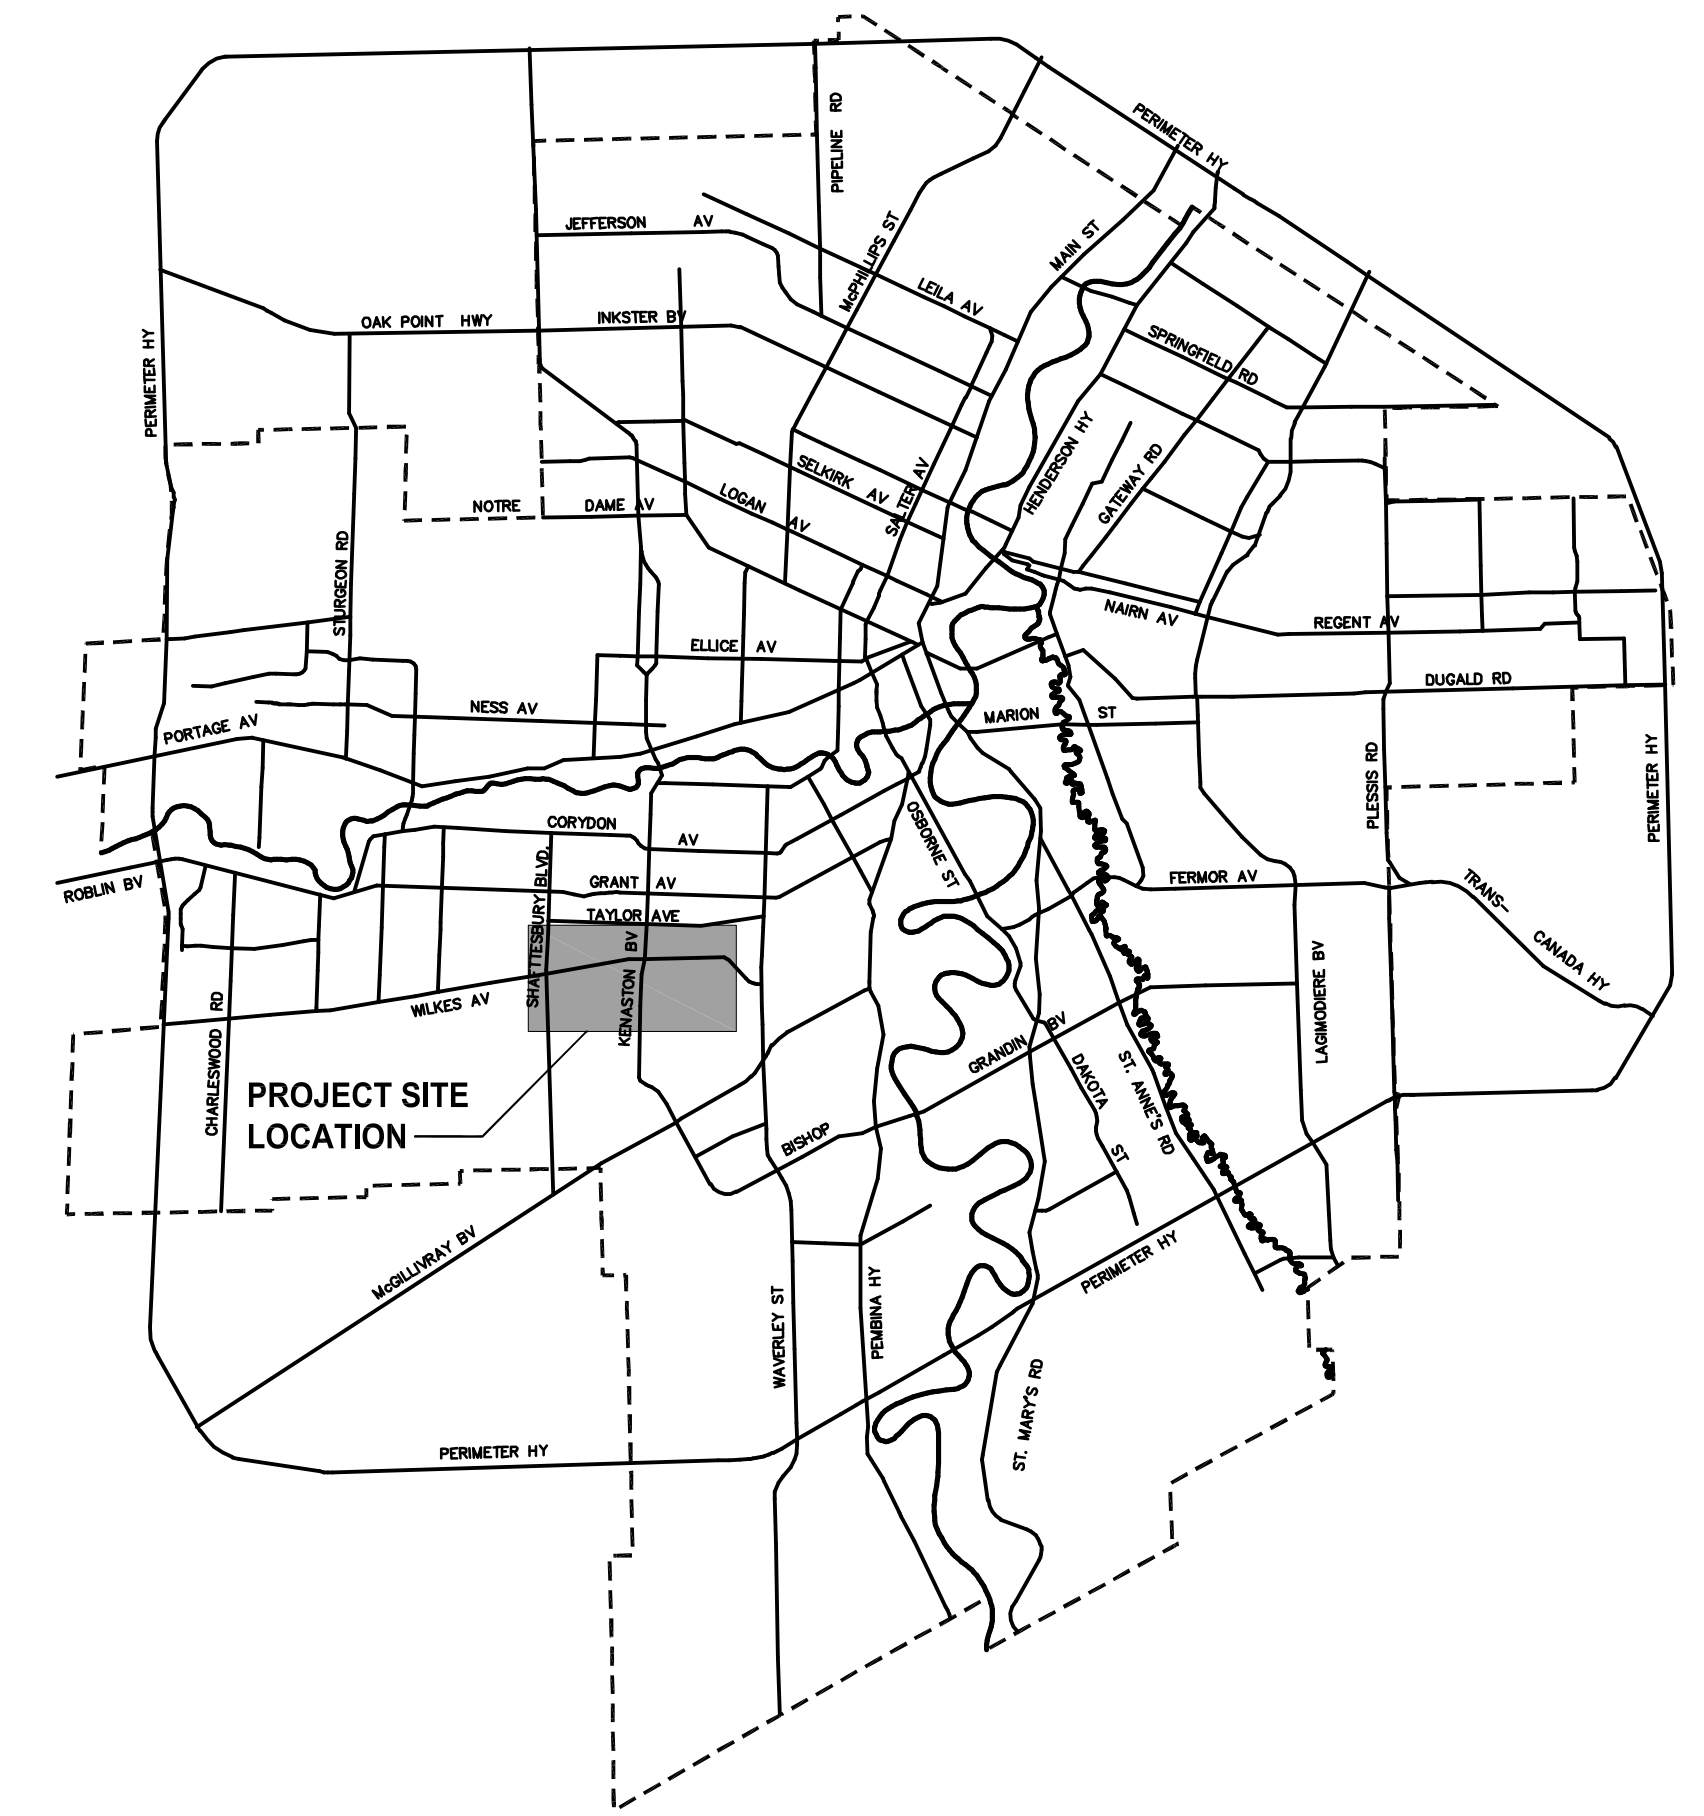

DRAWING INDEX

CITY DWG. No. CONSULTANT DRW. No. SHEET No. SHEET TITLE

P-3258-172	113703042-G06	1 of 52	COVER & DRAWING LIST
P-3258-173	113703042-G07	2 of 52	SITE PLAN - LIMITS OF WORKS
P-3258-174	113703042-H10	3 of 52	HORIZONTAL GEOMETRY - OVERALL DRAWING & KEY PLAN
RAMP TO WILKES AVENUE			
P-3258-175	113703042-H11	4 of 52	RAMP TO WILKES AVENUE - HORIZONTAL GEOMETRY
KENASTON BOULEVARD			
P-3258-176	113703042-H12	5 of 52	KENASTON BOULEVARD - HORIZONTAL GEOMETRY - STA 1+063 TO STA 1+375
P-3258-177	113703042-H13	6 of 52	KENASTON BOULEVARD - HORIZONTAL GEOMETRY - STA 1+375 TO STA 1+725
P-3258-178	113703042-H14	7 of 52	KENASTON BOULEVARD - HORIZONTAL GEOMETRY - STA 1+725 TO STA 1+925
P-3258-179	113703042-H15	8 of 52	KENASTON BOULEVARD - HORIZONTAL GEOMETRY - STA 1+925 TO STA 2+125
TAYLOR AVENUE			
P-3258-180	113703042-H16	9 of 52	TAYLOR AVENUE - HORIZONTAL GEOMETRY - STA 0+233 TO STA 0+436
LORIMER BOULEVARD			
P-3258-181	113703042-H17	10 of 52	LORIMER BOULEVARD - HORIZONTAL GEOMETRY - STA +511.029 TO STA 0+700
P-3258-182	113703042-H18	11 of 52	LORIMER BOULEVARD - HORIZONTAL GEOMETRY - STA 0+700 TO WILKES AVENUE
P-3258-183	113703042-G08	12 of 52	PAVEMENT DRAWING KEY PLAN
RAMP TO WILKES AVENUE			
P-3258-184	113703042-T24	13 of 52	RAMP TO WILKES AVENUE - HORIZONTAL & VERTICAL ALIGNMENT - STA 1+150 TO STA 1+425
P-3258-185	113703042-T25	14 of 52	RAMP TO WILKES AVENUE - HORIZONTAL & VERTICAL ALIGNMENT - STA 1+425 TO STA 1+600
KENASTON BOULEVARD			
P-3258-186	113703042-T26	15 of 52	KENASTON BOULEVARD - HORIZONTAL & VERTICAL ALIGNMENT - STA 1+063 TO STA 1+375
P-3258-187	113703042-T27	16 of 52	KENASTON BOULEVARD NORTH BOUND - HORIZONTAL & VERTICAL ALIGNMENT - STA 1+375 TO STA 1+725
P-3258-188	113703042-T28	17 of 52	KENASTON BOULEVARD SOUTH BOUND - HORIZONTAL & VERTICAL ALIGNMENT - STA 1+375 TO STA 1+725
P-3258-189	113703042-T29	18 of 52	KENASTON BOULEVARD - HORIZONTAL & VERTICAL ALIGNMENT - STA 1+725 TO STA 1+975
P-3258-190	113703042-T30	19 of 52	KENASTON BOULEVARD - HORIZONTAL & VERTICAL ALIGNMENT - STA 1+975 TO STA 2+125
TAYLOR AVENUE			
P-3258-191	113703042-T31	20 of 52	KENASTON BOULEVARD / TAYLOR AVENUE - HORIZONTAL & VERTICAL ALIGNMENT - STA 0+232 TO STA 0+435
P-3258-192	113703042-T32	21 of 52	KENASTON BOULEVARD AT TAYLOR AVENUE - INTERSECTION PAVEMENT GRADES & JOINT LOCATIONS
LORIMER BOULEVARD			
P-3258-193	113703042-T35	22 of 52	LORIMER BOULEVARD - HORIZONTAL & VERTICAL ALIGNMENT - STERLING LYON PARKWAY TO STA 0+700
P-3258-194	113703042-T36	23 of 52	LORIMER BOULEVARD - HORIZONTAL & VERTICAL ALIGNMENT - STA 0+700 TO WILKES AVENUE
DETAILS			
P-3258-195	113703042-T37	24 of 52	PAVEMENT CROSS SECTIONS & DETAILS
P-3258-196	113703042-T38	25 of 52	PAVEMENT CROSS SECTIONS & DETAILS
P-3258-197	113703042-T39	26 of 52	PAVEMENT CROSS SECTIONS & DETAILS
P-3258-198	113703042-T40	27 of 52	KENASTON BOULEVARD / DND PROPERTY - SURFACE WORKS RESTORATION
P-3258-199	113703042-D01	28 of 52	KENASTON BOULEVARD - ROAD WORKS DECOMMISSIONING
P-3258-200	113703042-D02	29 of 52	KENASTON BOULEVARD - RAILWAY DETOUR DECOMMISSIONING
P-3258-201	113703042-T41	30 of 52	KENASTON BOULEVARD / DETOUR ROAD - TRAFFIC DIVERSION PHASE 1,2 & 3

CITY DWG. No. CONSULTANT DRW. No. SHEET No. SHEET TITLE

KENASTON BOULEVARD AT BRIDGE			
P-3258-202	113703042-S27	31 of 52	KENASTON BOULEVARD - CONCRETE TRAFFIC BARRIER - CONCRETE LAYOUT & DETAILS
P-3258-203	113703042-S28	32 of 52	KENASTON BOULEVARD - CONCRETE TRAFFIC BARRIER - REINFORCING LAYOUT & DETAILS
P-3258-204	113703042-S29	33 of 52	KENASTON BOULEVARD - CONCRETE SLOPE PAVING - CONCRETE LAYOUT & DETAILS
P-3258-205	113703042-S30	34 of 52	KENASTON BOULEVARD - CONCRETE SLOPE PAVING - REINFORCING LAYOUT & DETAILS
P-3258-206	113703042-S31	35 of 52	KENASTON BOULEVARD - RETAINING WALL - LAYOUT & DETAILS
KENASTON BOULEVARD			
D-8891	113703042-D03	36 of 52	KENASTON BOULEVARD - UNDERGROUND SERVICES DECOMMISSIONING - STA 1+200 TO RAILWAY BRIDGE
D-8892	113703042-D04	37 of 52	KENASTON BOULEVARD - UNDERGROUND SERVICES DECOMMISSIONING - RAILWAY BRIDGE TO TAYLOR AVENUE
LD-3273	113703042-U24	38 of 52	KENASTON BOULEVARD - LAND DRAINAGE SYSTEM - STA 1+200 TO STA 1+450
LD-3274	113703042-U25	39 of 52	KENASTON BOULEVARD - LAND DRAINAGE SYSTEM - STA 1+450 TO STA 1+700
LD-3275	113703042-U26	40 of 52	KENASTON BOULEVARD - LAND DRAINAGE SYSTEM - STA 1+700 TO STA 2+054
LD-3276	113703042-U27	41 of 52	KENASTON BOULEVARD - LAND DRAINAGE SYSTEM - MISCELLANEOUS UNDERGROUND DETAILS
LD-3277	113703042-U28	42 of 52	KENASTON BOULEVARD - LAND DRAINAGE SYSTEM - MISCELLANEOUS UNDERGROUND DETAILS
WILKES AVENUE			
LD-3278	113703042-U29	43 of 52	WILKES AVENUE - WEST DITCH REGRADING - STA 0+254 TO STA 0+468
LD-3279	113703042-U30	44 of 52	CN RIVERS SUBDIVISION - NORTH CN DITCHING - STA 0+149 TO STA 0+450
LD-3294	113703042-U31	45 of 52	CN RIVERS SUBDIVISION - NORTH CN DITCHING - STA 0+450 TO STA 0+755
P-3258-207	113703042-E07	46 of 52	KENASTON BOULEVARD - ELECTRICAL LAYOUT DETAILS
LANDSCAPING			
P-3258-208	113703042-L01	47 of 52	LANDSCAPING PLAN - STERLING LYON PARKWAY TO STA 1+220 & DETAILS
P-3258-209	113703042-L02	48 of 52	LANDSCAPING PLAN - STA 1+220 TO CENTER LINE OF CN UNDERPASS BRIDGE
P-3258-210	113703042-L03	49 of 52	PLANTING BED ENLARGEMENTS - STA 1+580 TO STA 1+700
P-3258-211	113703042-L04	50 of 52	LANDSCAPING PLAN - CENTER LINE OF CN UNDERPASS BRIDGE TO STA 1+900
P-3258-212	113703042-L05	51 of 52	PLANTING BED ENLARGEMENTS & DETAILS - STA 1+600 TO STA 1+700
P-3258-213	113703042-L06	52 of 52	LANDSCAPING PLAN - KENASTON BOULEVARD STA 1+900 TO STA 2+140 - LORIMER BOULEVARD STA 0+500 TO 0+930



Stantec Consulting Ltd.

WINNIPEG

MANITOBA

MANITOBA

RELEASED FOR CONSTRUCTION BY:
R. FINGAS, P.ENG.

DATE: 06.03.03

CONSULTANT DRAWING No.
113703042-G06

CITY DRAWING No.
P-3258-172

CAD FILE DRAWING No.
ku-01-665.dwg