

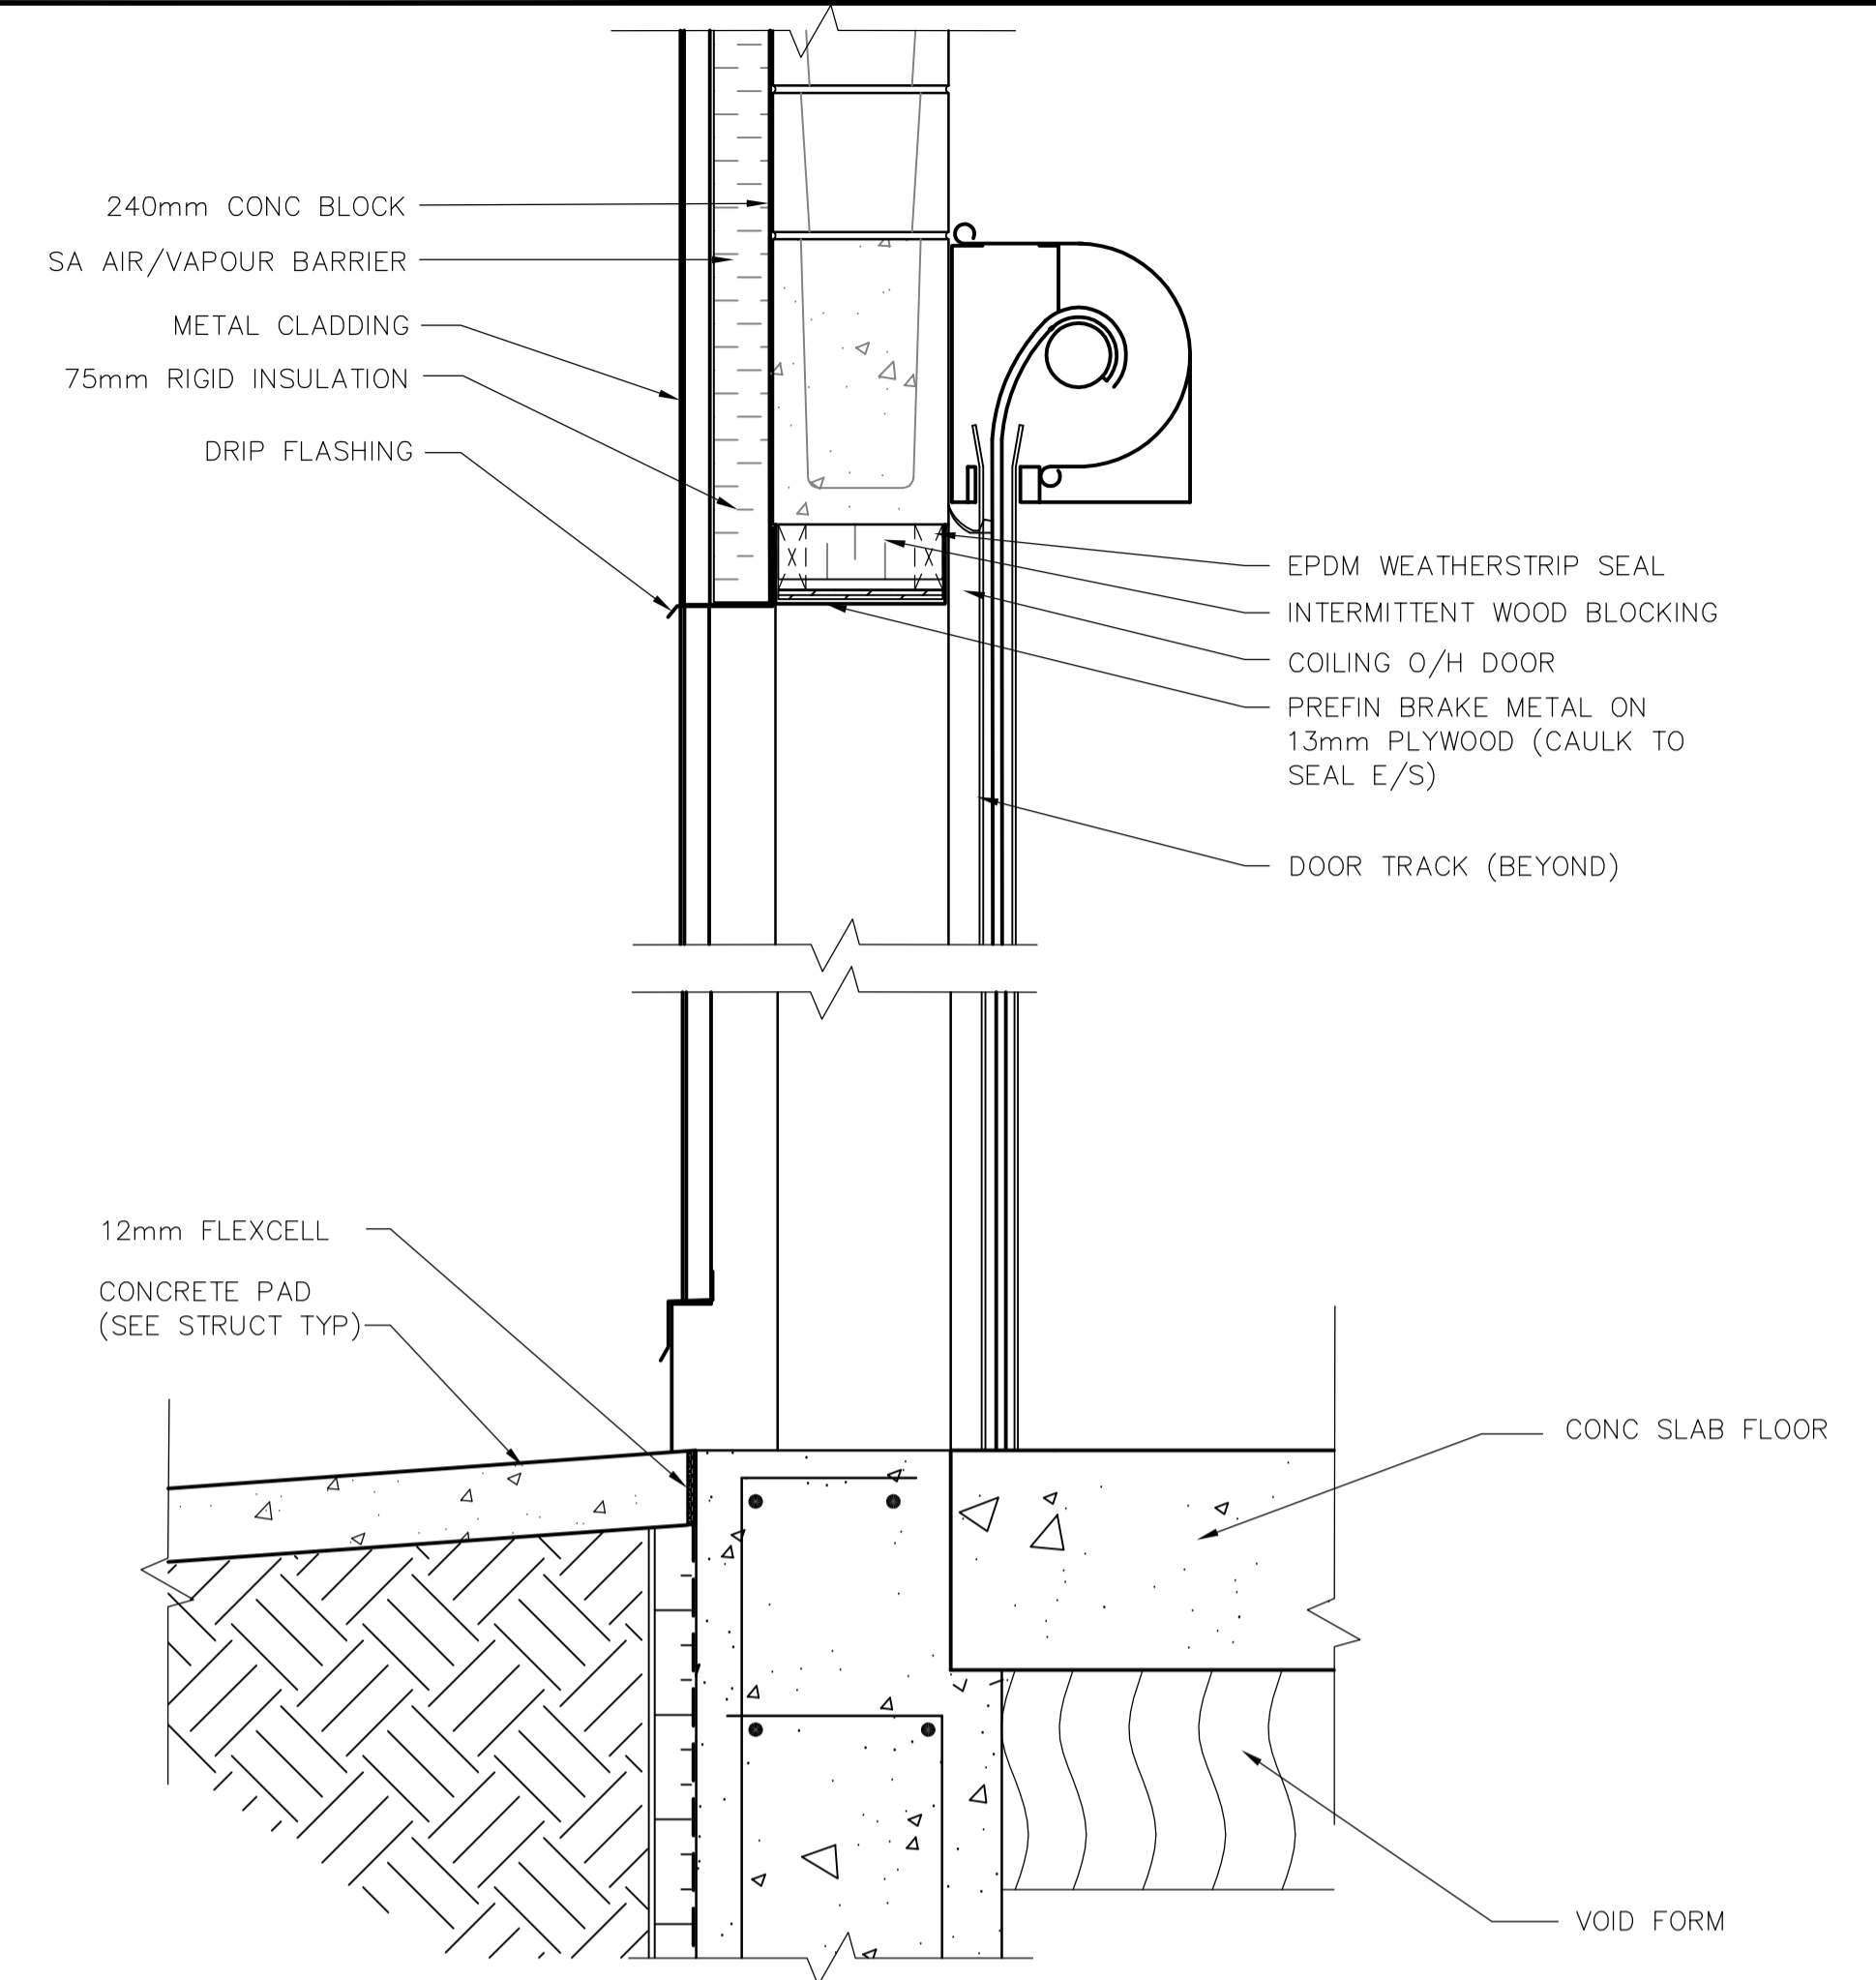



1 FOUNDATION WALL SECTION DETAIL  
A3.01 1:10

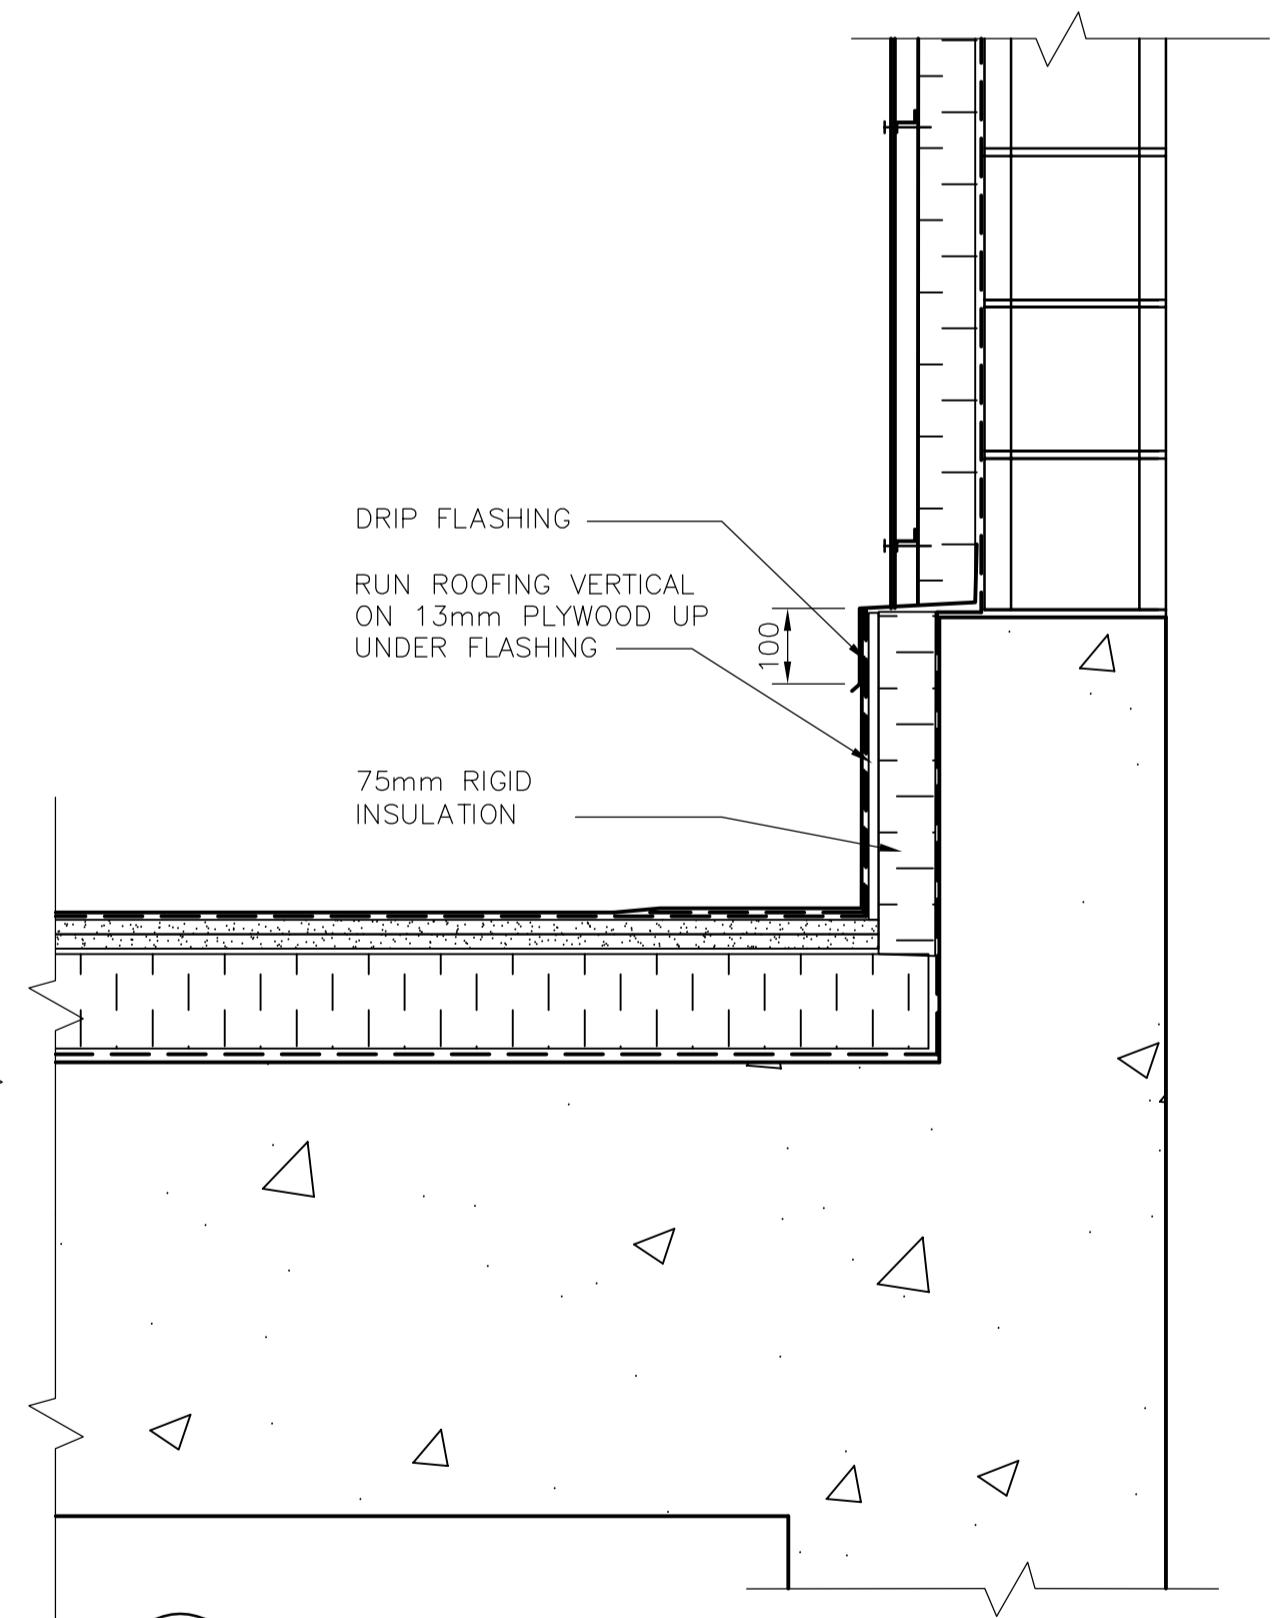

4 OVERHEAD COILING DOOR SECTION DETAIL  
A3.02 1:10

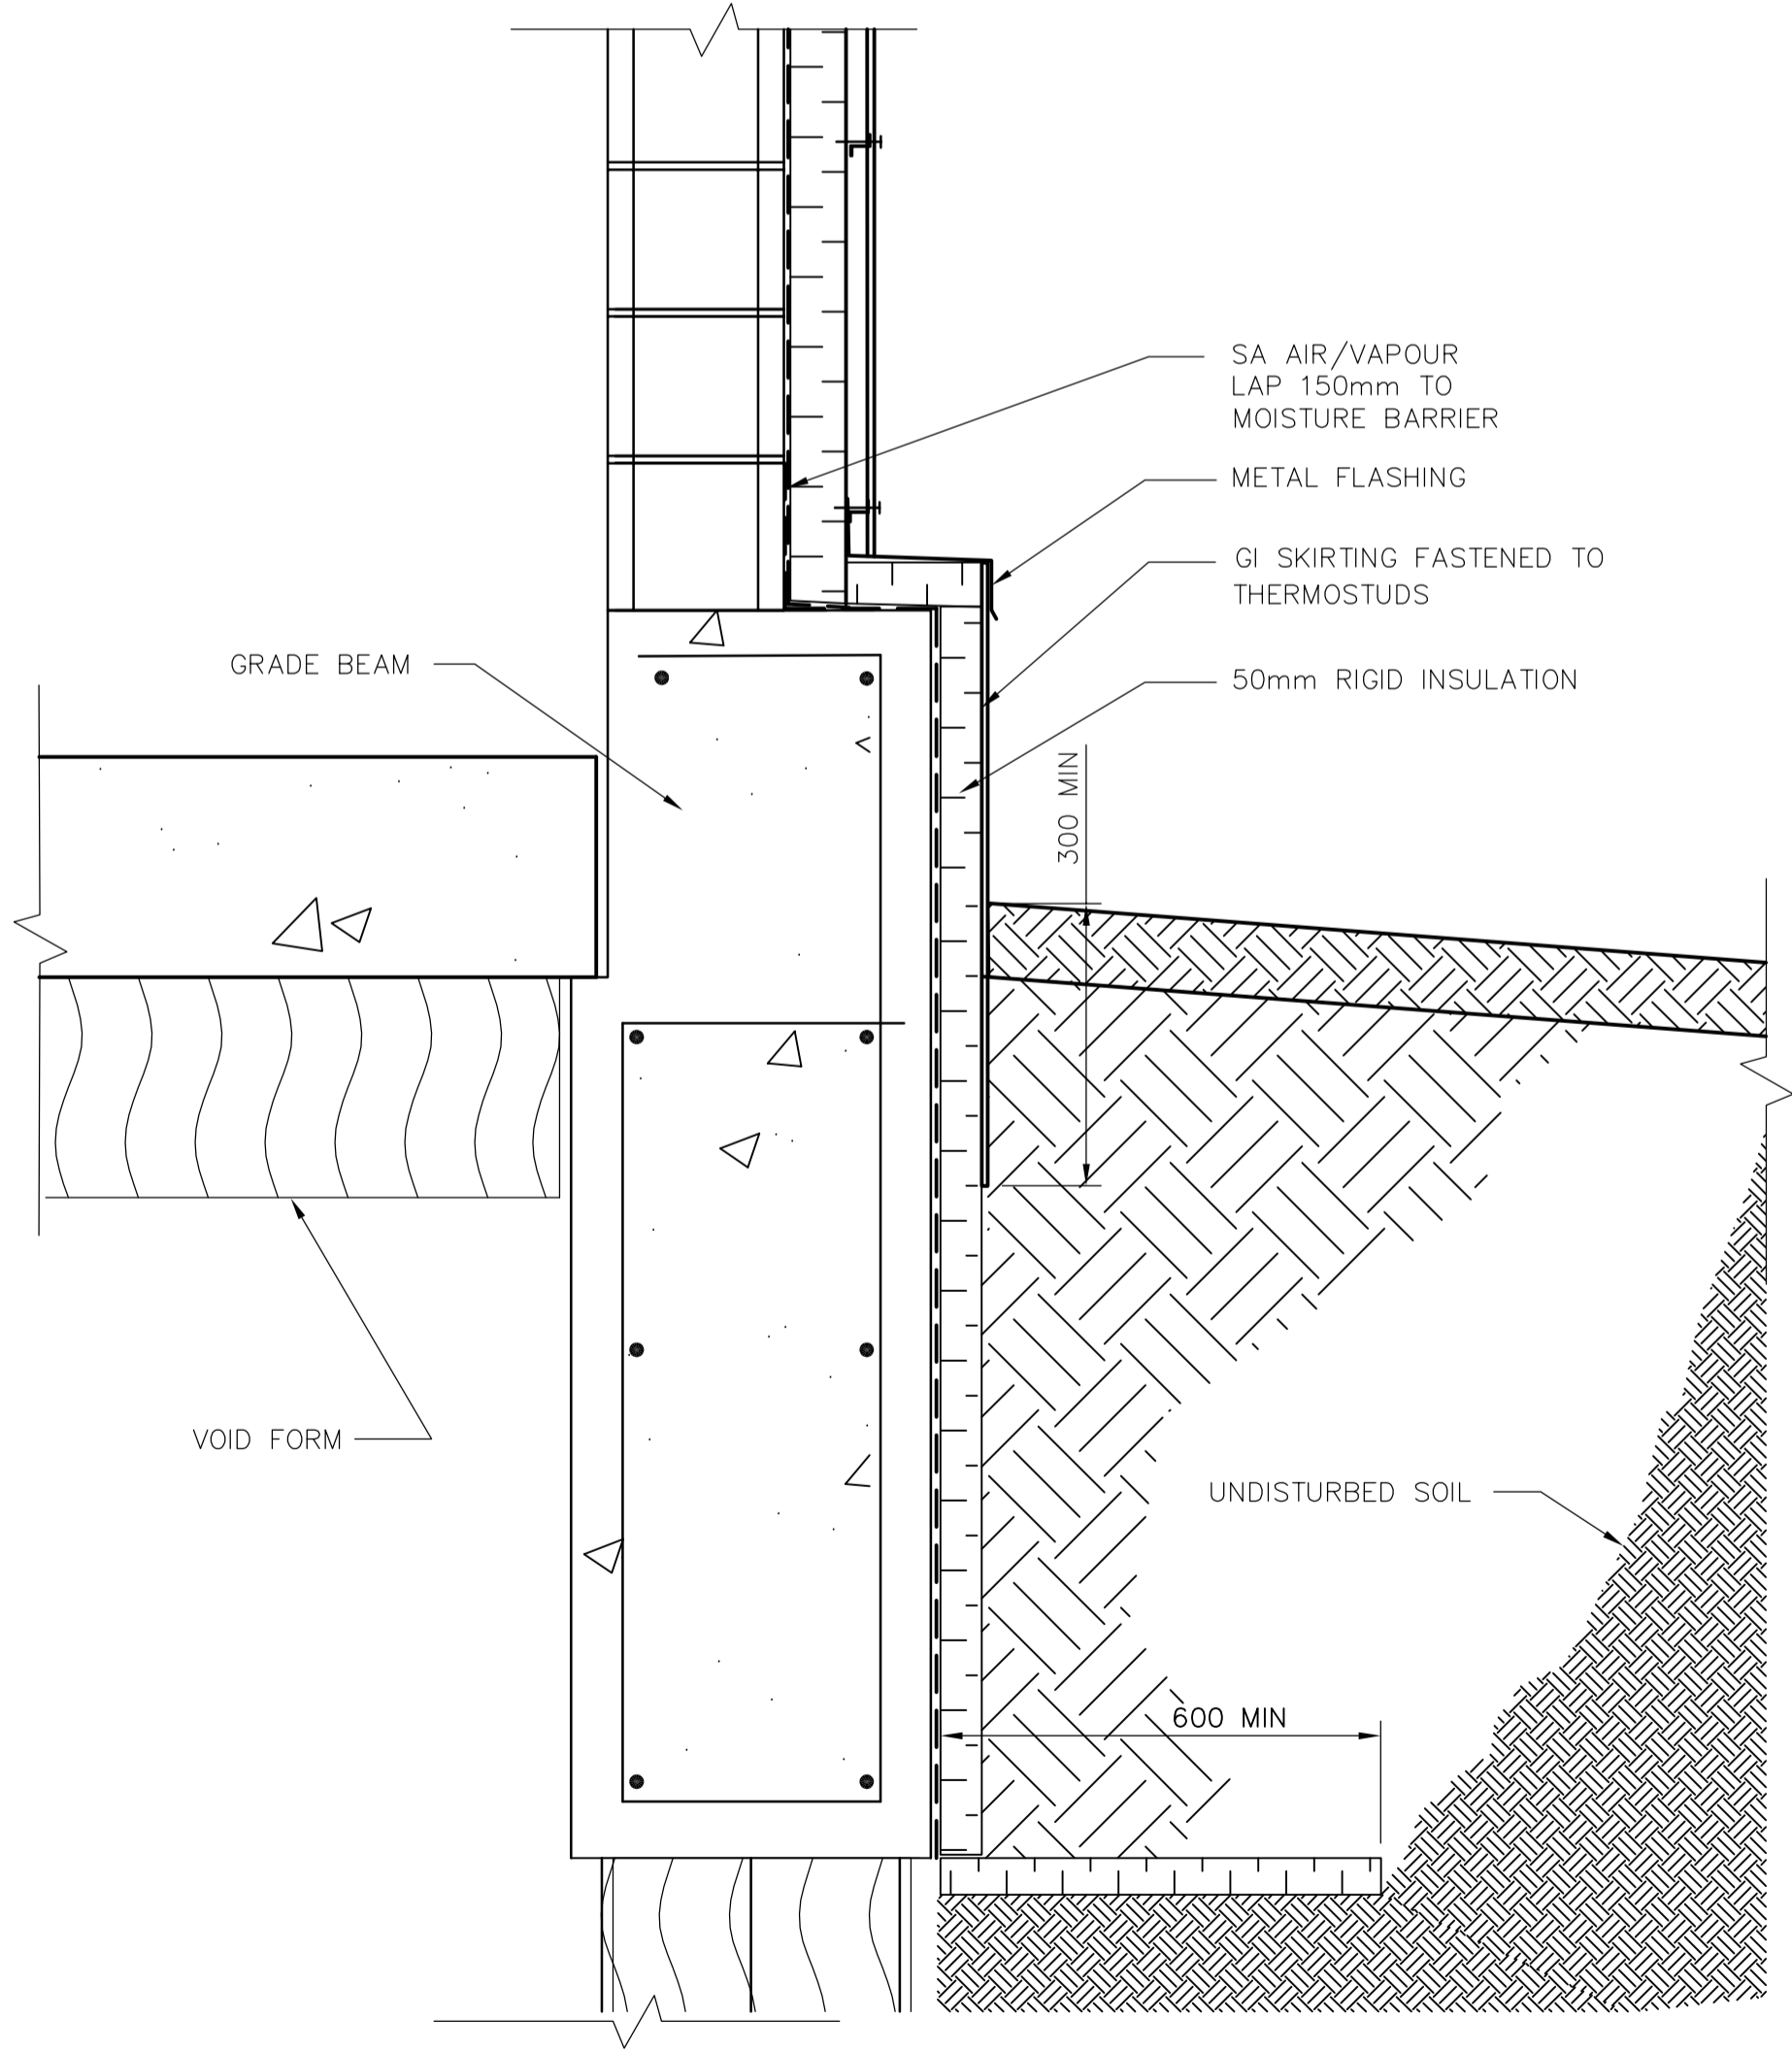

2 ROOF TO WALL SECTION  
A3.01 1:125

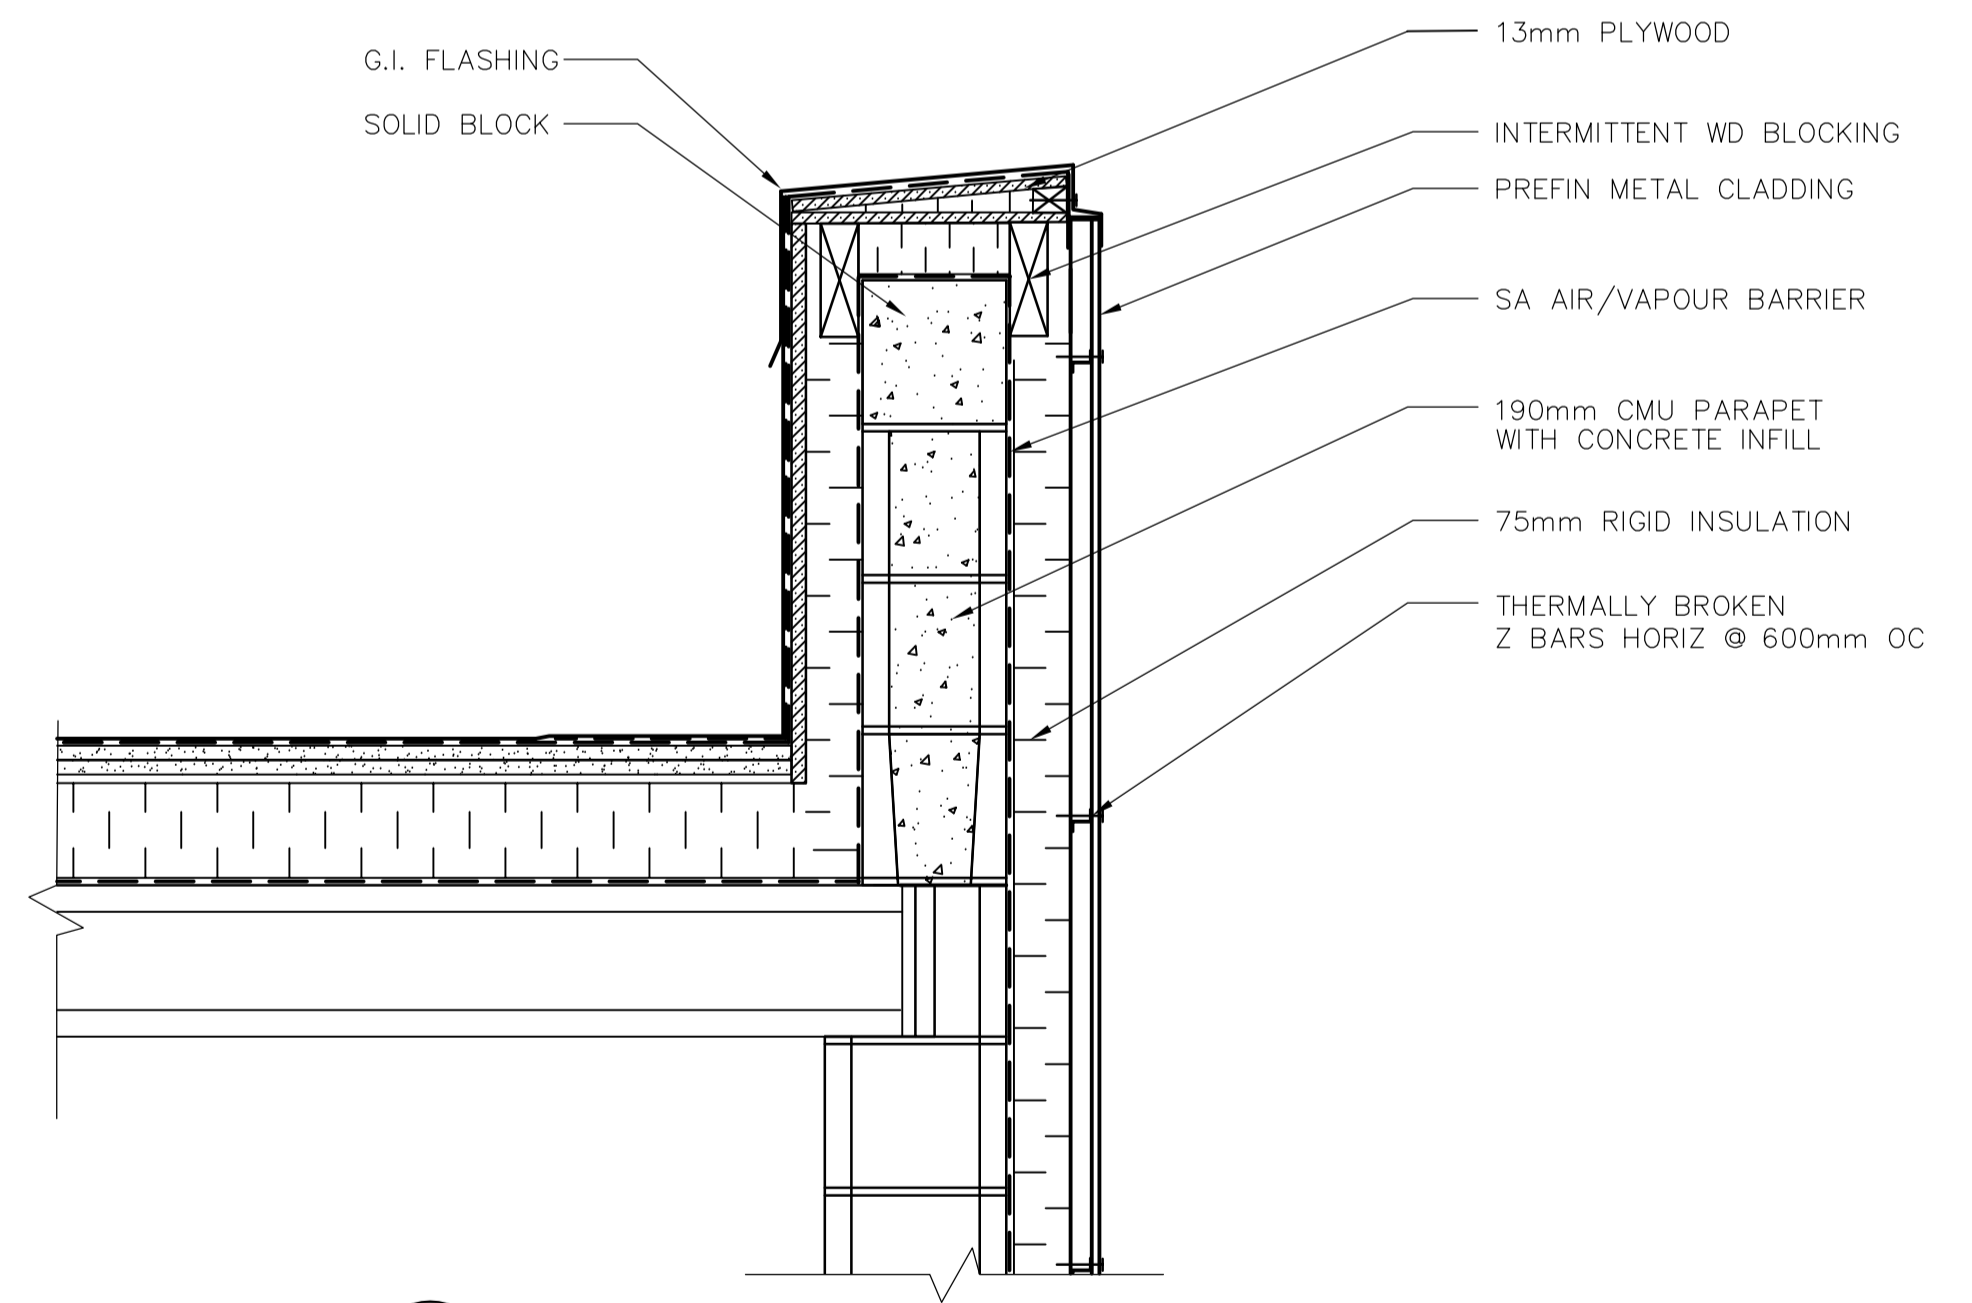

5 PARAPET DETAIL (TYP)  
A3.02 1:10

3 WALL SECTION DETAIL  
A3.01 1:10



B.M. ELEV.		 A Tyco International Ltd. Company		ENGINEER'S SEAL		 THE CITY OF WINNIPEG WATER AND WASTE DEPARTMENT ENGINEERING DIVISION	
				DESIGNED BY: NC			
		DRAWN BY: AL		CHECKED BY: LK		2006/05/19	
		HOR. SCALE: AS NOTED		APPROVED BY: JEH		NEWPCC CENTRATE NUTRIENT TREATMENT NITROGEN REMOVAL FACILITY	
		RELEASED FOR CONSTRUCTION BY: K. MARTENS		CONSULTANT DRAWING NO. A4.01		CITY FILE NUMBER	
00 ISSUED FOR TENDER 06/05/15 AL		DATE: 2006/03/21		DATE: 2006/05/23		SHEET OF	
NO. REVISIONS						CITY DRAWING NUMBER	