



1 SBR, BLOWER BLDG & EXHAUST BLDG - PLUMBING PLAN
M1.01 SCALE 1:100

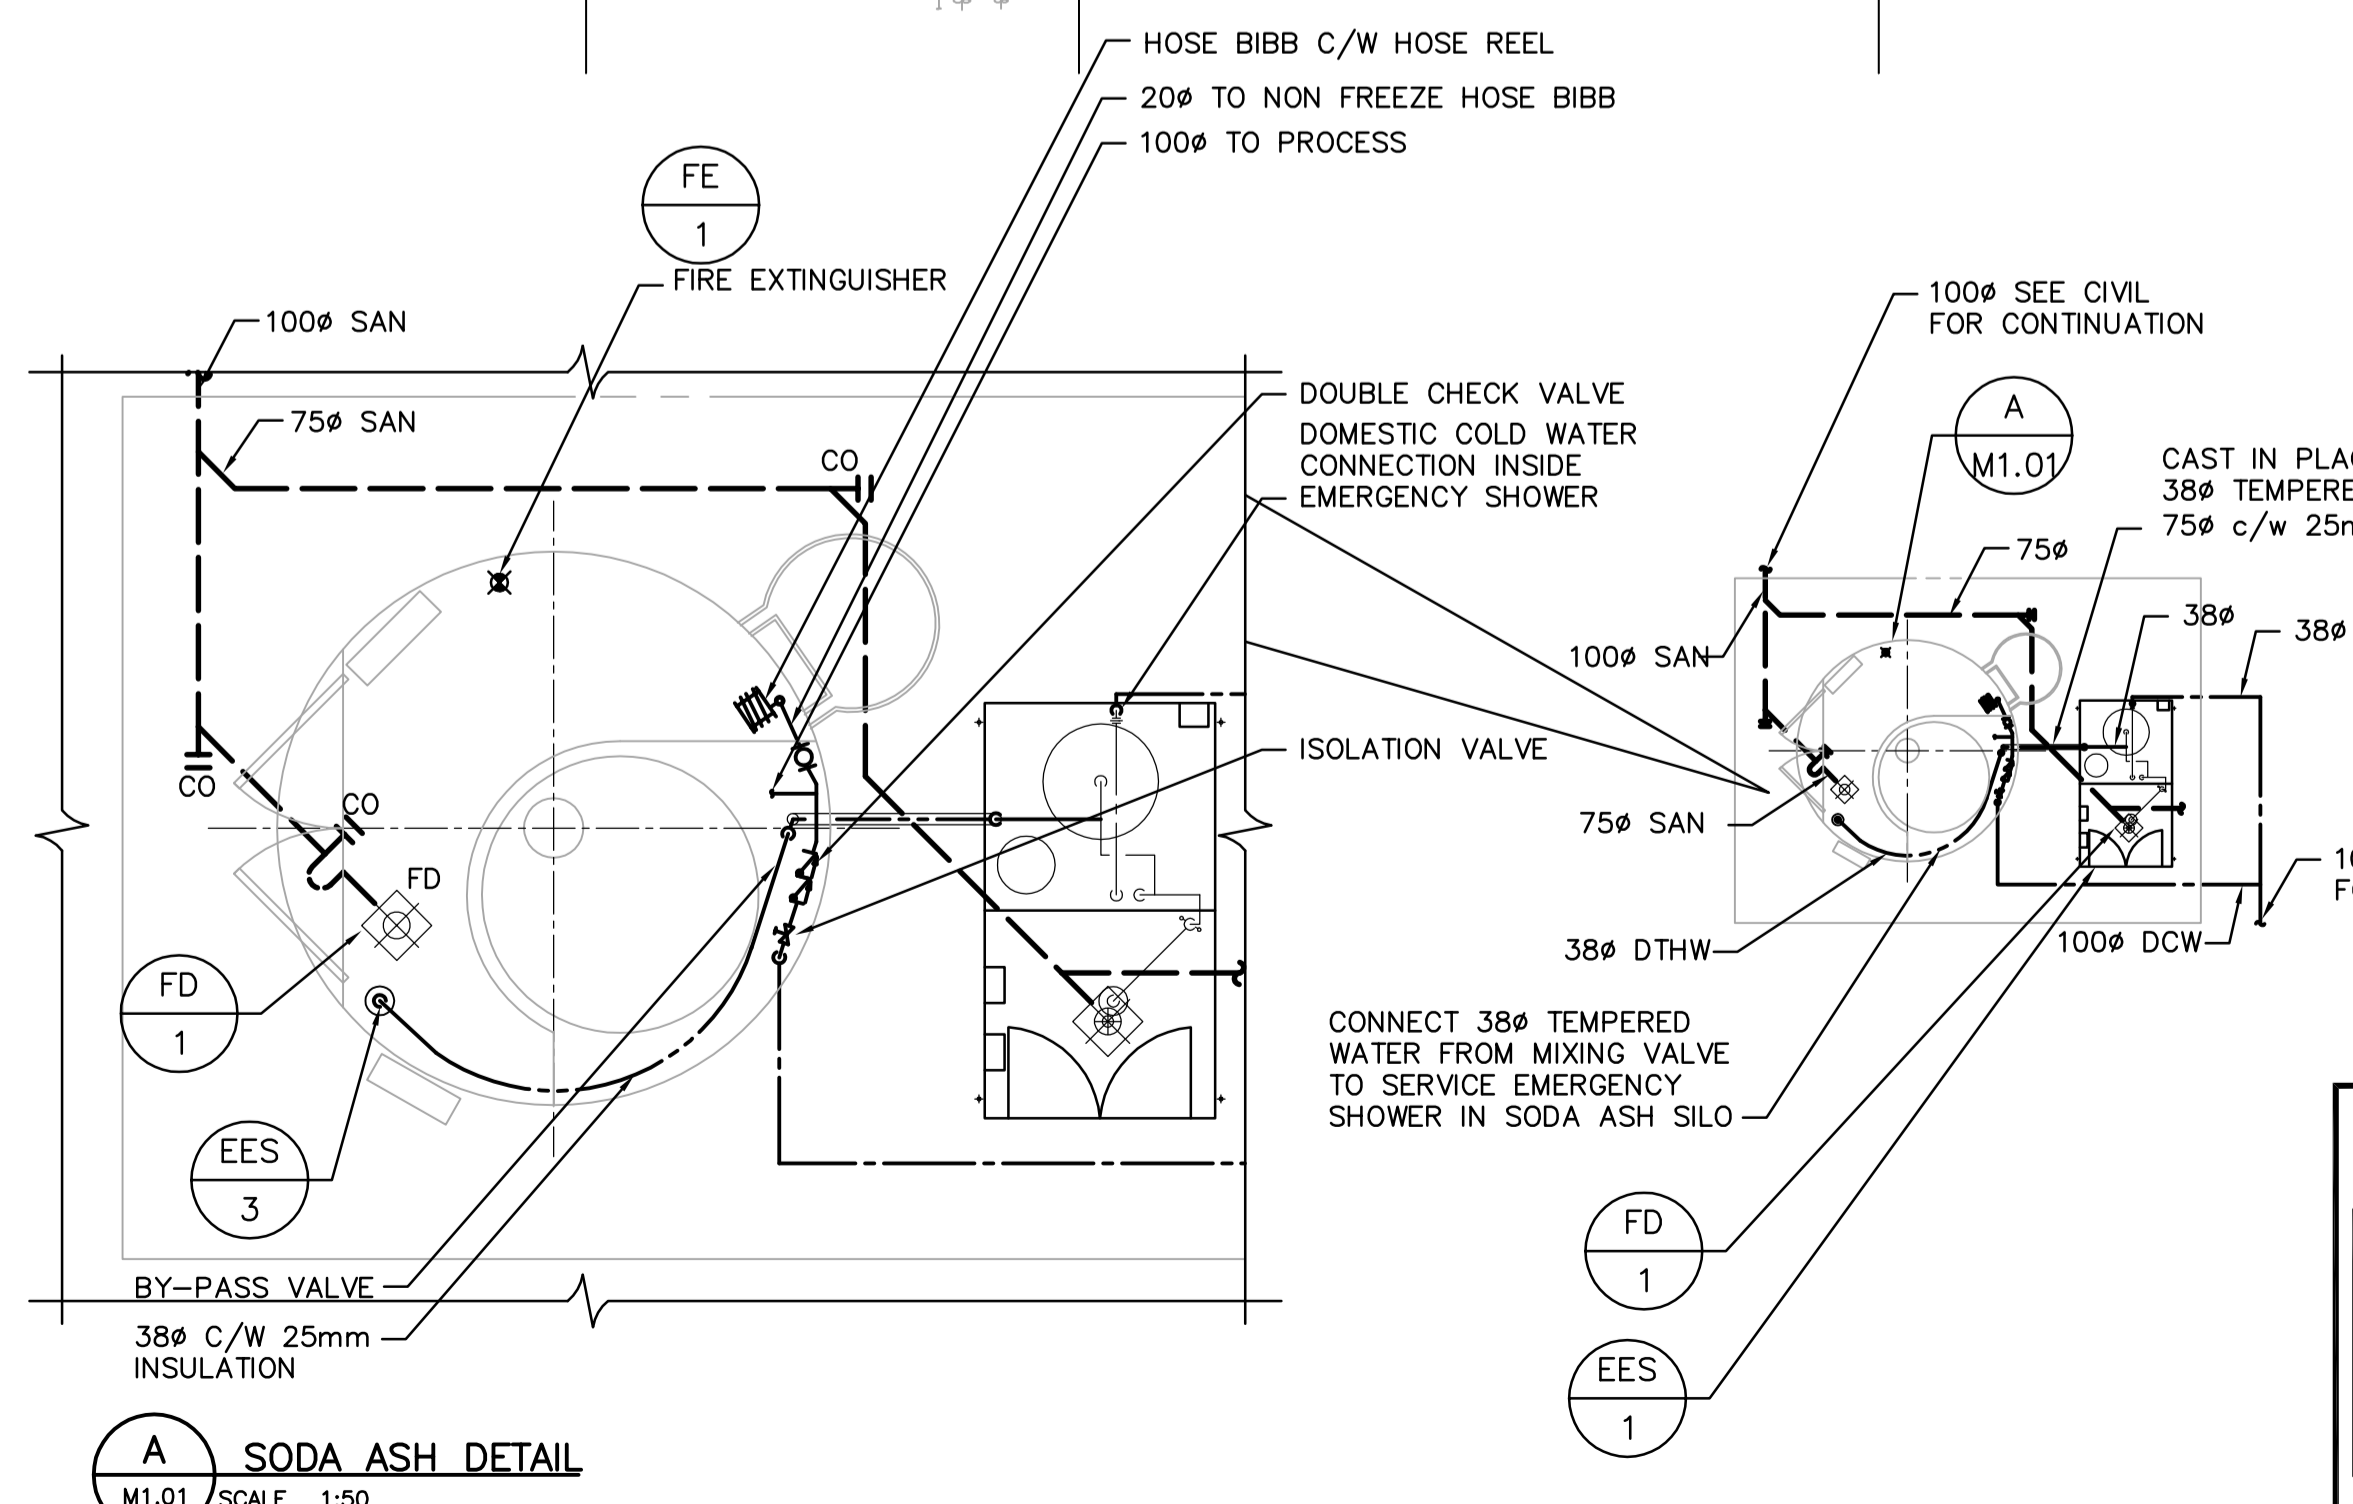

A SODA ASH DETAIL
M1.01 SCALE 1:50

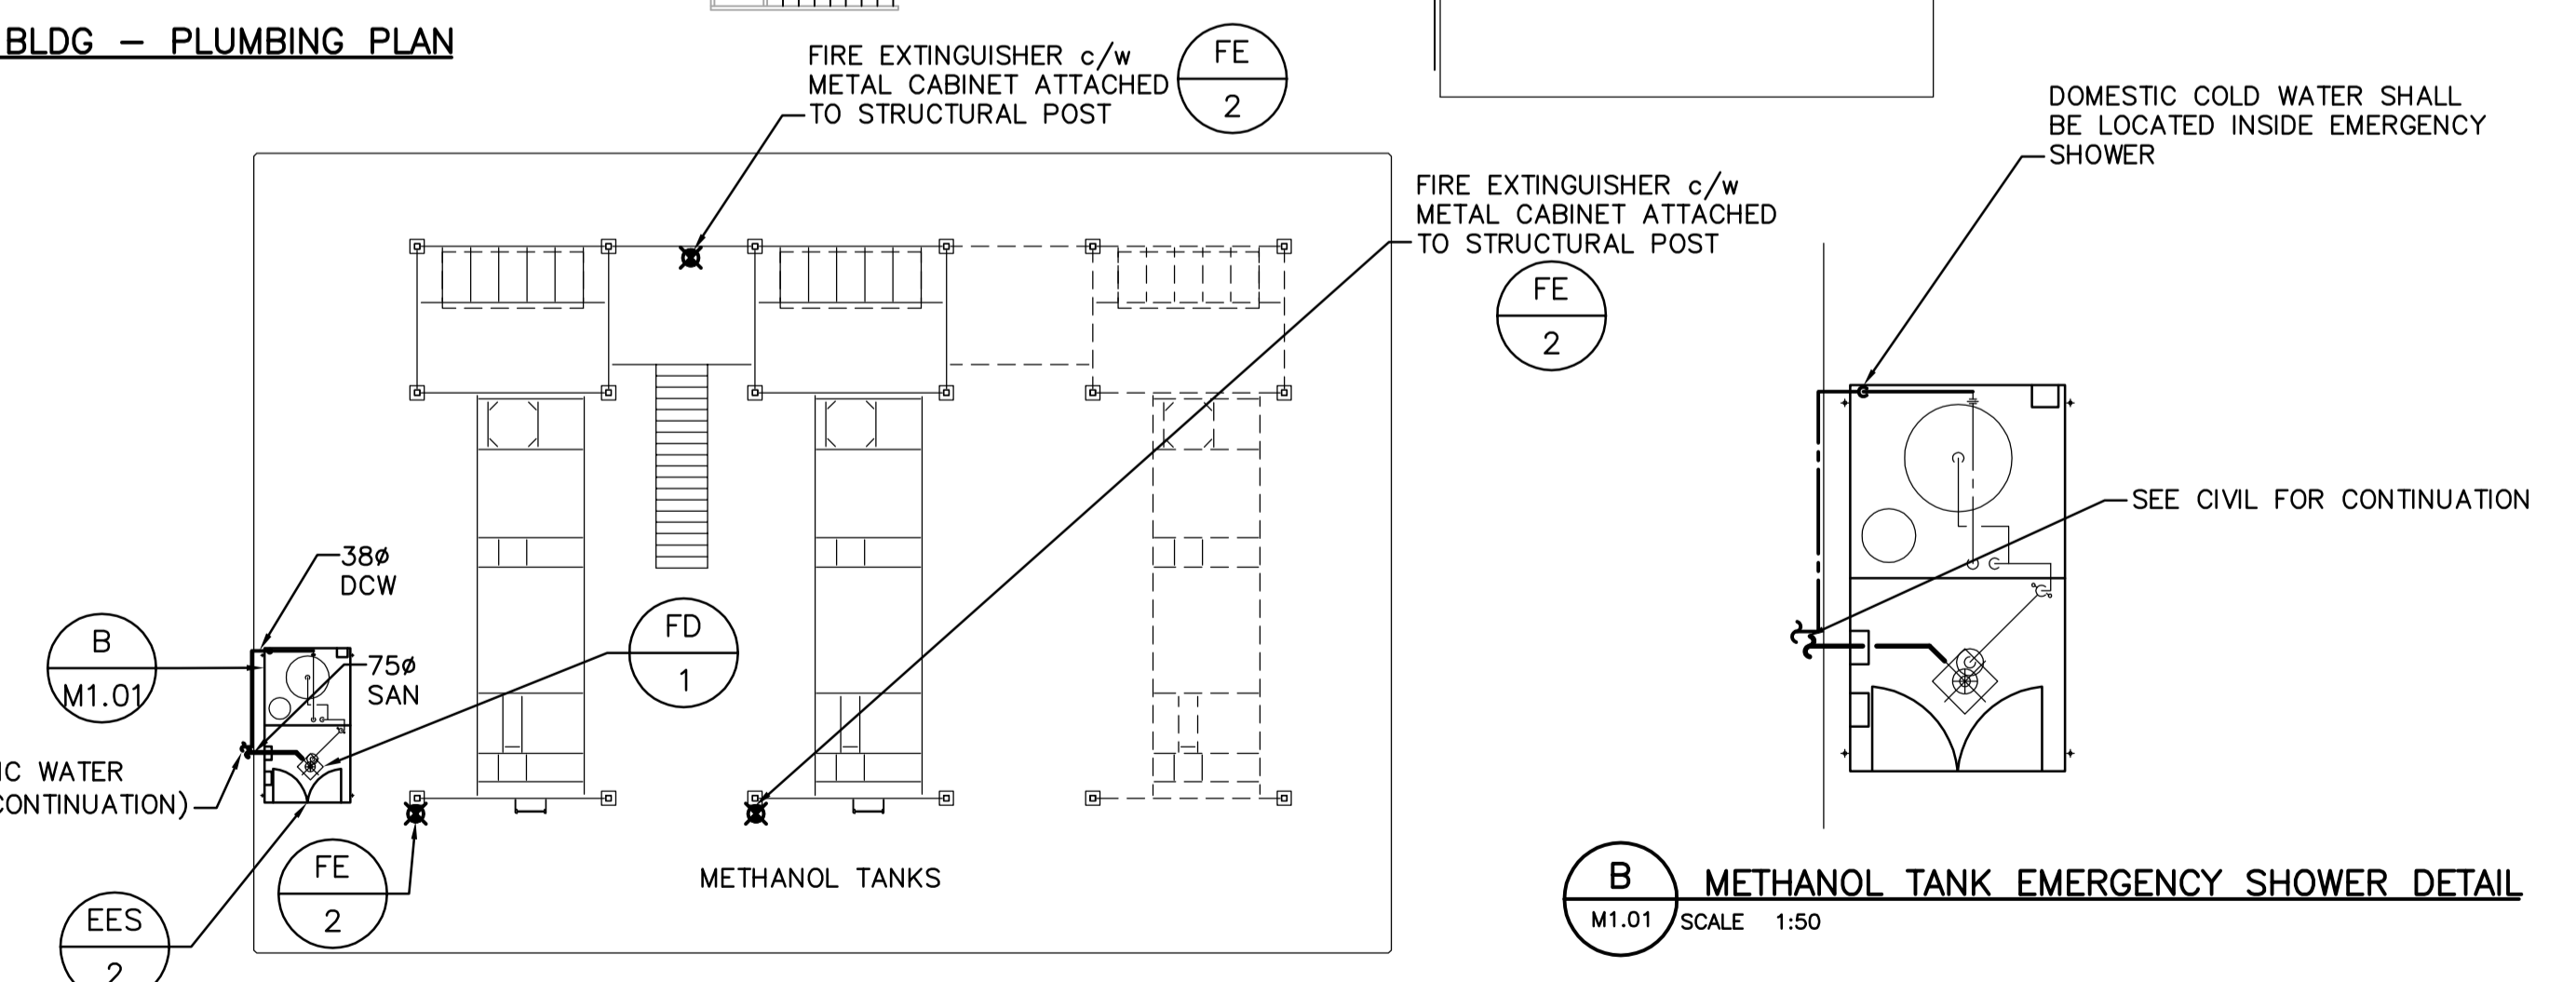

B METHANOL TANK EMERGENCY SHOWER DETAIL
M1.01 SCALE 1:50

<p>Certificate of Authorization Earth Tech Canada Inc. No. 730 Expiry: April 30, 2007</p>	B.M. ELEV.	<p>A Tyco International Ltd. Company</p>	ENGINEER'S SEAL	<p>THE CITY OF WINNIPEG WATER AND WASTE DEPARTMENT ENGINEERING DIVISION</p>				
			DESIGNED BY: AB		ORIGINAL SIGNED BY: A. BURACHYNSKY			
			DRAWN BY: DJP		2006/05/15			
			SCALE: AS NOTED		CONSULTANT DRAWING NO. M1.01			
	00 ISSUED FOR TENDER	06/05/15	DATE: 2006/05/15	RELEASED FOR CONSTRUCTION BY: K. MARTENS	DATE: 2006/05/23		NEWPC CENTRATE NUTRIENT TREATMENT NITROGEN REMOVAL FACILITY	CITY FILE NUMBER
							METHANOL TANKS - PLUMBING PLAN	SHEET OF
								CITY DRAWING NUMBER