


DRV 305 VALVE CHAMBER ROOF PLAN VIEW
1:20

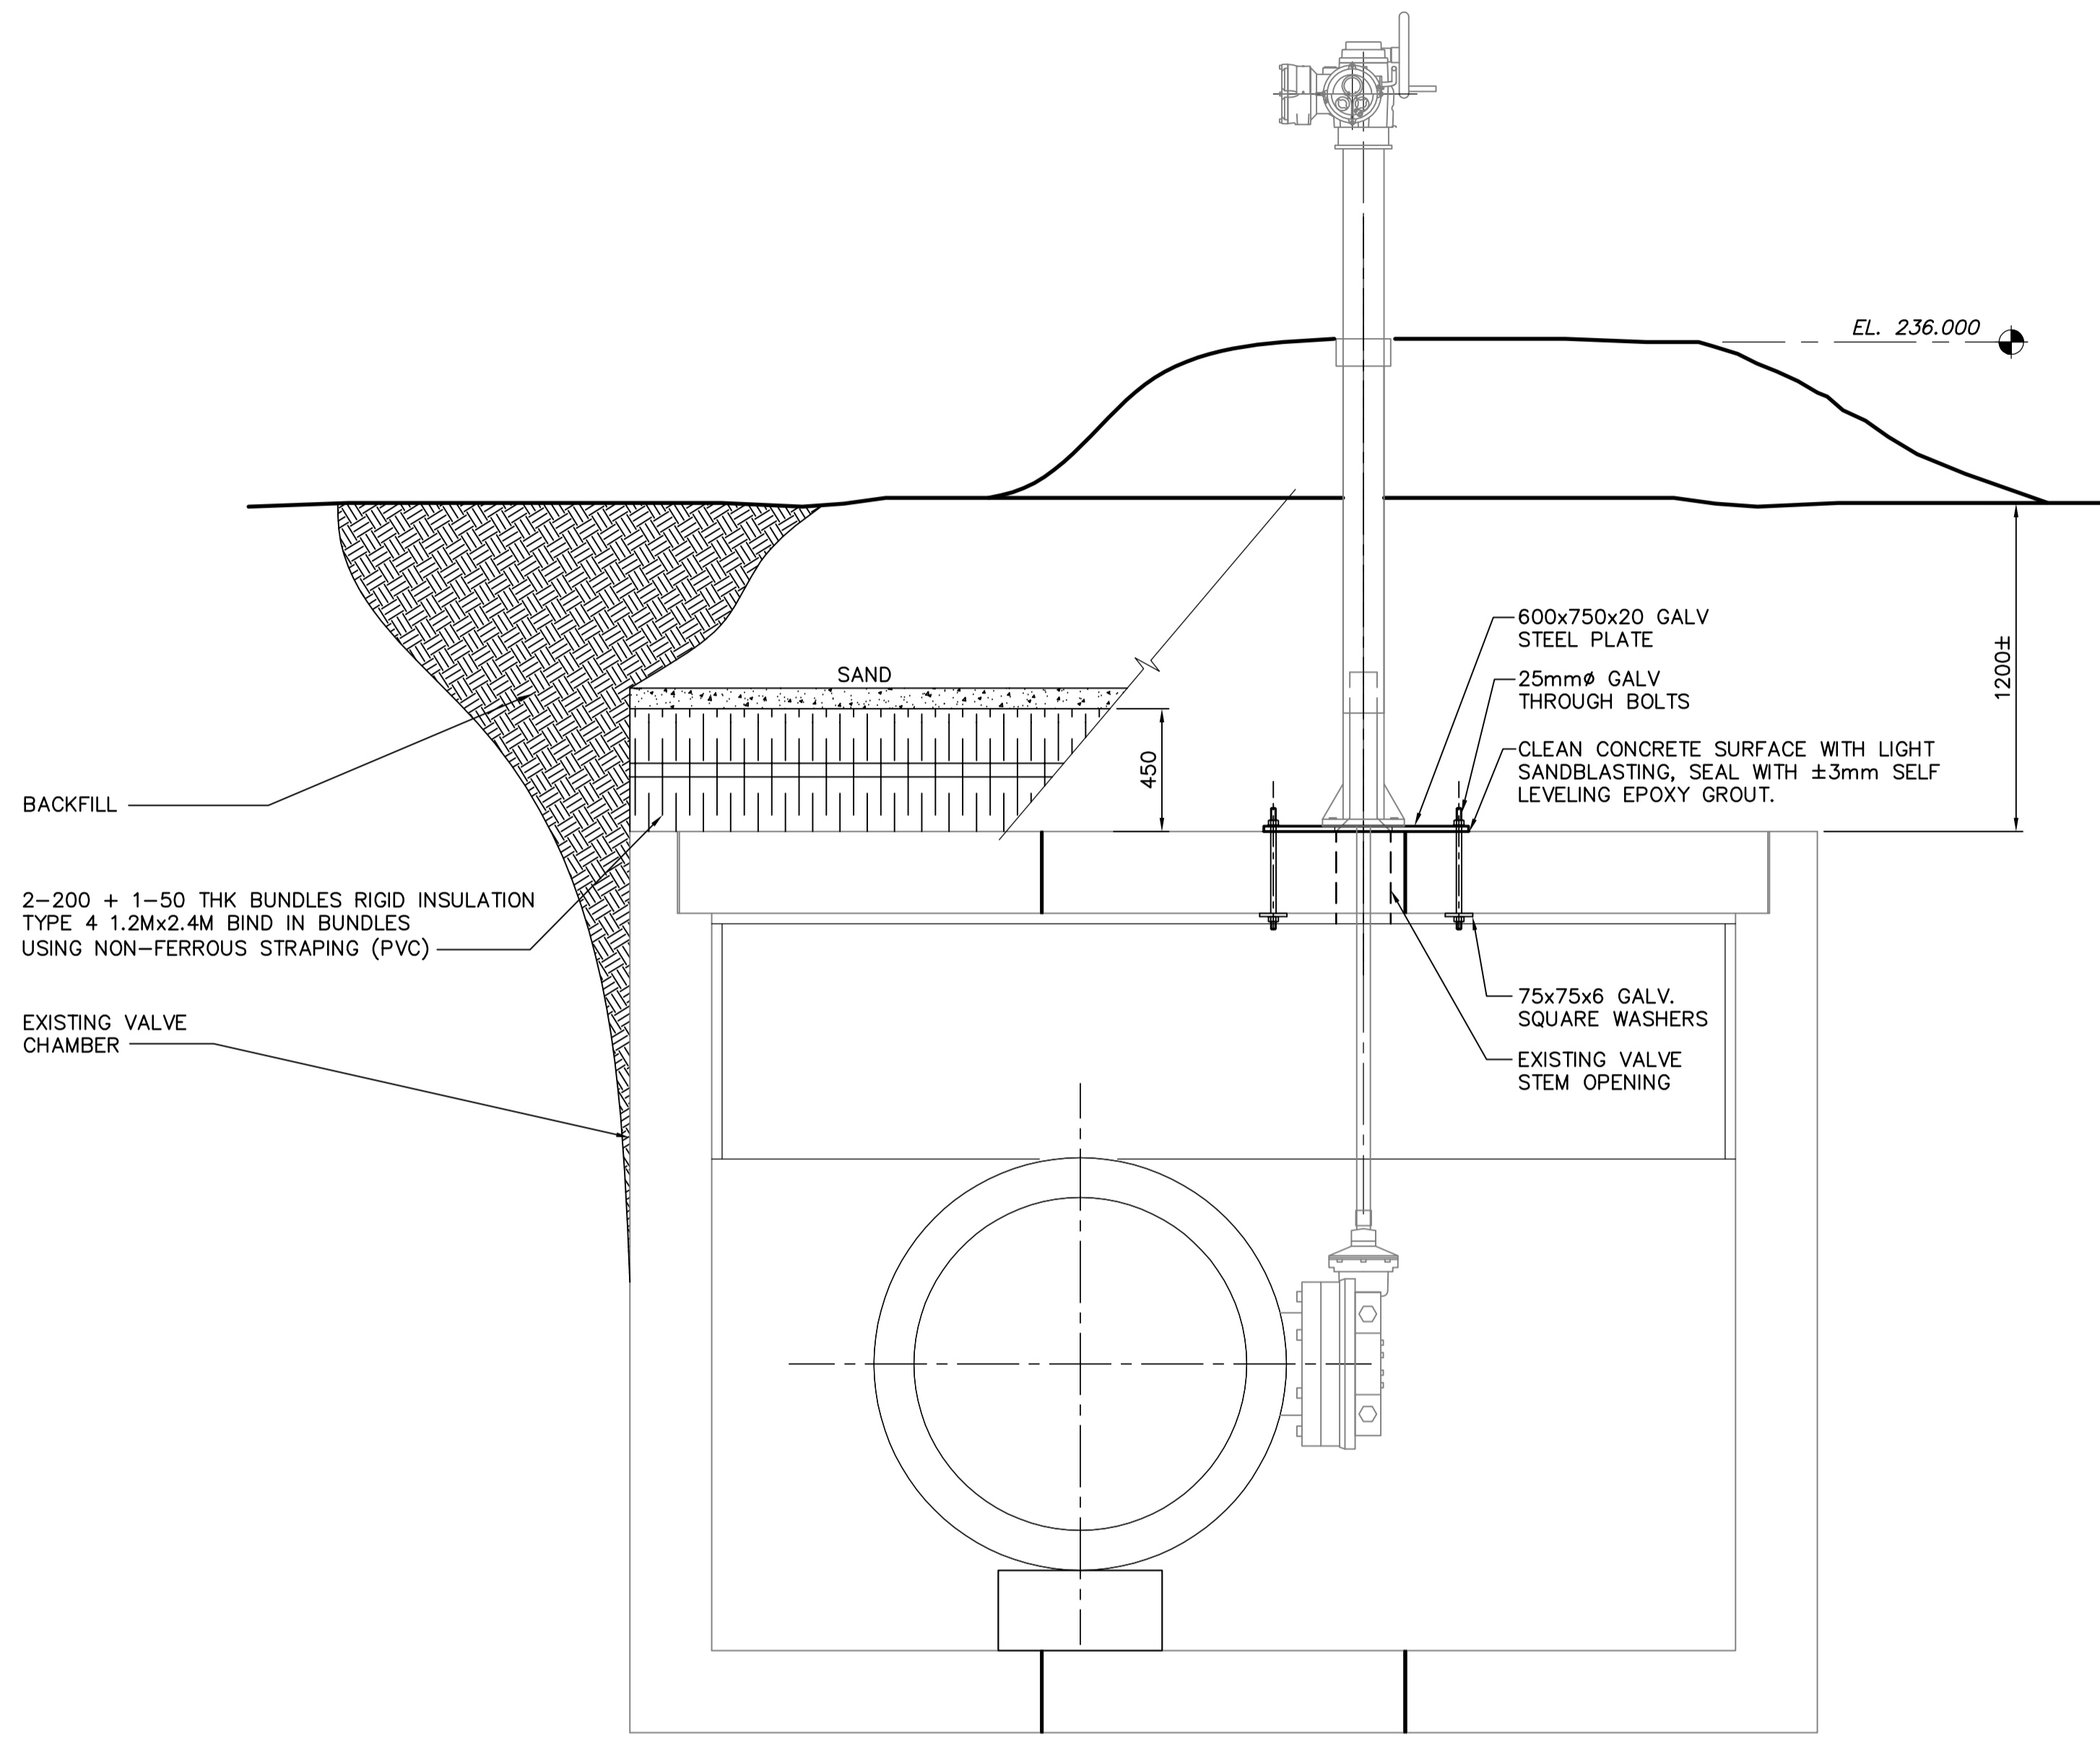

SECTION
1:20

NOTE:
FOR LOCATION OF VALVE CHAMBER REFER TO CIVIL DRAWING WD-C0100

<p>Certificate of Authorization Earth Tech Canada Inc. No. 730 Expiry: April 30, 2007</p>	B.M. ELEV.	<p>Frederickson Cooper ARCHITECTS</p>	<p>A 100 International Ltd. Company</p>	ENGINEER'S SEAL	<p>THE CITY OF WINNIPEG WATER AND WASTE DEPARTMENT ENGINEERING DIVISION</p>		
				DESIGNED BY GGP		CHECKED BY MK	ORIGINAL SIGNED BY M. KLASSEN
				DRAWN BY KK		APPROVED BY AHL	2007/03/16
				SCALE: AS SHOWN		RELEASED FOR CONSTRUCTION BY: R. SOROKOWSKI	CONSULTANT DRAWING NO. WD-S0105
00	ISSUED FOR TENDER	07/03/19	KK		WATER TREATMENT PLANT DEACON BOOSTER PUMP STATION UPGRADE	CITY FILE NUMBER	
NO.	REVISIONS	DATE	BY	DATE	DATE	SHEET OF	
				2006/12/08	2007/03/16		
						CITY DRAWING NUMBER	
						1-0601D-A-50105-001-000	
						STRUCTURAL DRV 305 VALVE CHAMBER MODIFICATIONS	